

C:\2019\1915 - PRH.MCB\DWG\1915P10_001.dwg
11/17/2019
3:45:35 PM


80' / 4" = 1" = 100'



**PRH
MEDICAL OFFICE BUILDING**
NAPLES, FLORIDA

THIS DOCUMENT CONTAINS PROPRIETARY INFORMATION AND IS THE PROPERTY OF DSC ARCHITECTS. IT IS TO BE USED ONLY FOR THE PROJECT AND SITE SPECIFICALLY IDENTIFIED HEREIN. NO PART OF THIS DOCUMENT IS TO BE REPRODUCED OR TRANSMITTED IN ANY FORM OR BY ANY MEANS, ELECTRONIC OR MECHANICAL, INCLUDING PHOTOCOPYING, RECORDING, OR BY ANY INFORMATION STORAGE AND RETRIEVAL SYSTEM, WITHOUT THE PRIOR WRITTEN PERMISSION OF DSC ARCHITECTS. COPYRIGHT 2019. ALL RIGHTS RESERVED.

DSC ARCHITECTS
7121 CROSSROADS BVD
888-HYWOOD, IN 37027
TEL: (615) 726-0310
MAE: dscinfo@dscarch.com
WWW: www.dscarch.com

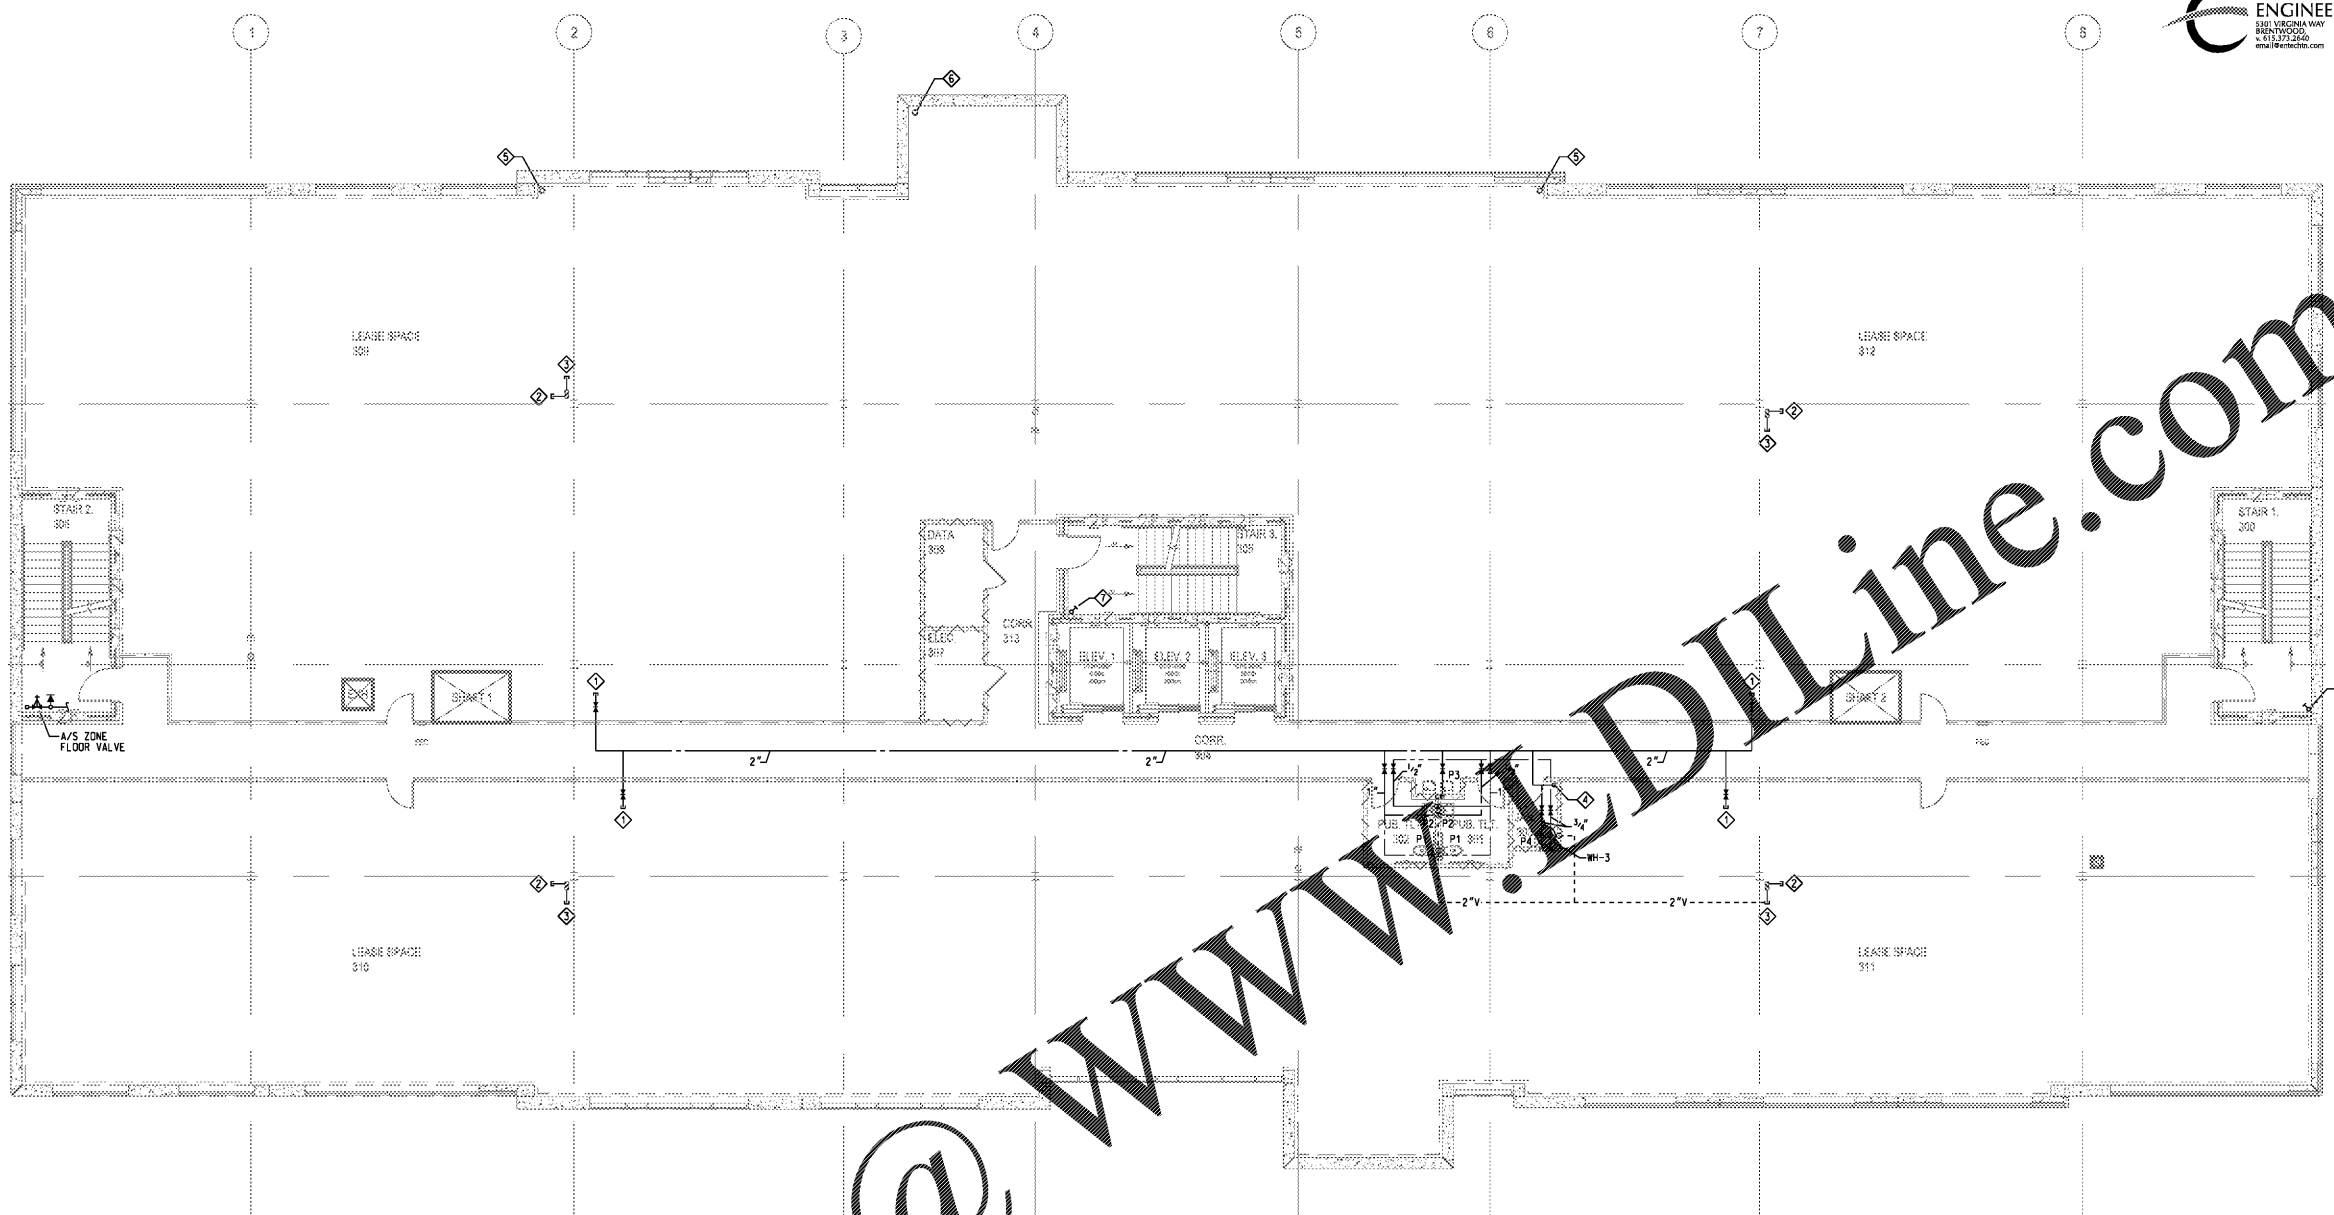

Order Plans @ www.DIline.com

- PLUMBING PLAN NOTES:**
- ◇ VALVE AND CAP 2" DOMESTIC CW FOR FUTURE.
 - ◇ 4" WASTE STACK UP/DOWN.
 - ◇ 4" VENT STACK UP.
 - ◇ 2 1/2" CW FROM BELOW.
 - ◇ 8" RWL UP/DOWN.
 - ◇ 6" RWL UP/DOWN.
 - ◇ STAND PIPE UP/DOWN.

WALL LEGEND

WALL CONSTRUCTION TYP.

.....	UNRATED PARTITION TO ABOVE CLG.
-----	LEASE SPACE PARTITION
.....	UNRATED PARTITION TO DECK
.....	SMOKE PARTITION
.....	SMOKE BARRIER
.....	1 HOUR FIRE BARRIER
.....	1 HOUR FIRE - SMOKE BARRIER
.....	2 HOUR FIRE BARRIER
.....	2 HOUR FIRE - SMOKE BARRIER
.....	2 HOUR SHAFT BARRIER

NOTE: 1.) FOR SOUND WALLS SEE DIMENSIONED PLAN.
2.) ALL WALL TYPES MAY NOT BE USED.

PLUMBING
THIRD FLOOR PLAN



REVISIONS

NO.	DATE	DESCRIPTION

P2.03
ISSUE DATE: 11.12.19
JOB NUMBER: 19029