

GENERAL NOTES

- VOLUME DAMPERS LOCATED ABOVE HARD CEILING SHALL BE EQUIPPED WITH CABLE OPERATORS AT FACE OF DIFFUSER OR REGISTER.
- PROVIDE ACCESS PANEL FOR EQUIPMENT ABOVE HARD CEILING.

(X) KEYNOTES

- PROVIDE AND INSTALL NEW WALL THERMOSTAT WHERE INDICATED. SEE HVAC SEQUENCING OF CONTROLS, SHEET M002.
- COMBINED TEMPERATURE AND HUMIDITY SENSORS MOUNTED ON WALL AT 80" AFF. HUMIDITY FUNCTION IS TO BE INSTALLED BACK TO RTU. THE TEMPERATURE FUNCTION IS TO LINK TO THE THERMOSTAT IN THE OFFICE.
 HOODED METAL WALL VENT WITH SPRING LOADED DAMPER, SCREEN AND BUG SCREEN. COLOR TO BE WHITE. DETERMINE MOUNTING HEIGHT AND LOCATION WITH KEYNOTES.
 PROVIDE AND INSTALL HEAT TEMPERATURE SENSOR AT CEILING.

HFA
 HARRISON FRENCH
 ASSOCIATES, LTD.
 1479.273.7780
 1705 S. Walton Blvd. Suite 3
 Bentonville, Arkansas 72712
 www.hfa-ae.com

STIPULATION FOR REUSE
 THIS DRAWING WAS PREPARED FOR THE PROJECT LACKS THE NECESSARY INFORMATION TO BE REUSED IN ANY OTHER PROJECT WITHOUT THE WRITTEN PERMISSION OF HARRISON FRENCH ASSOCIATES, LTD. ANY REUSE OF THIS DRAWING FOR ANY OTHER PROJECT WITHOUT THE WRITTEN PERMISSION OF HARRISON FRENCH ASSOCIATES, LTD. IS PROHIBITED. THE REPRODUCTION OF THIS PROJECT IS NOT AUTHORIZED AND WILL BE CONSIDERED A VIOLATION OF THE LAW.

Cumberland
 SUNRISE & 4TH
 FORT LAUDERDALE, FL 33304
 JOB NUMBER: 41-17-00410

ISSUE BLOCK


90% CDs	05/10/19
100% Set	06/14/19
90% AIM4.0	08/14/19
100% AIM4.0	09/11/19

CHECKED BY: BRT
 DRAWN BY: BRT

PROFESSIONAL ENGINEER
 STATE OF FLORIDA
 LICENSE NO. 72212
 Greg Schussman, P.E.
 License #72212
 Harrison French & Associates, LTD.
 CDA #92421
 2019.09.11 21:29:06-05'00"
 Printed copies of this document are not considered signed and sealed and the signature must be verified on any electronic copies.

HVAC FLOOR PLAN

SHEET: M100

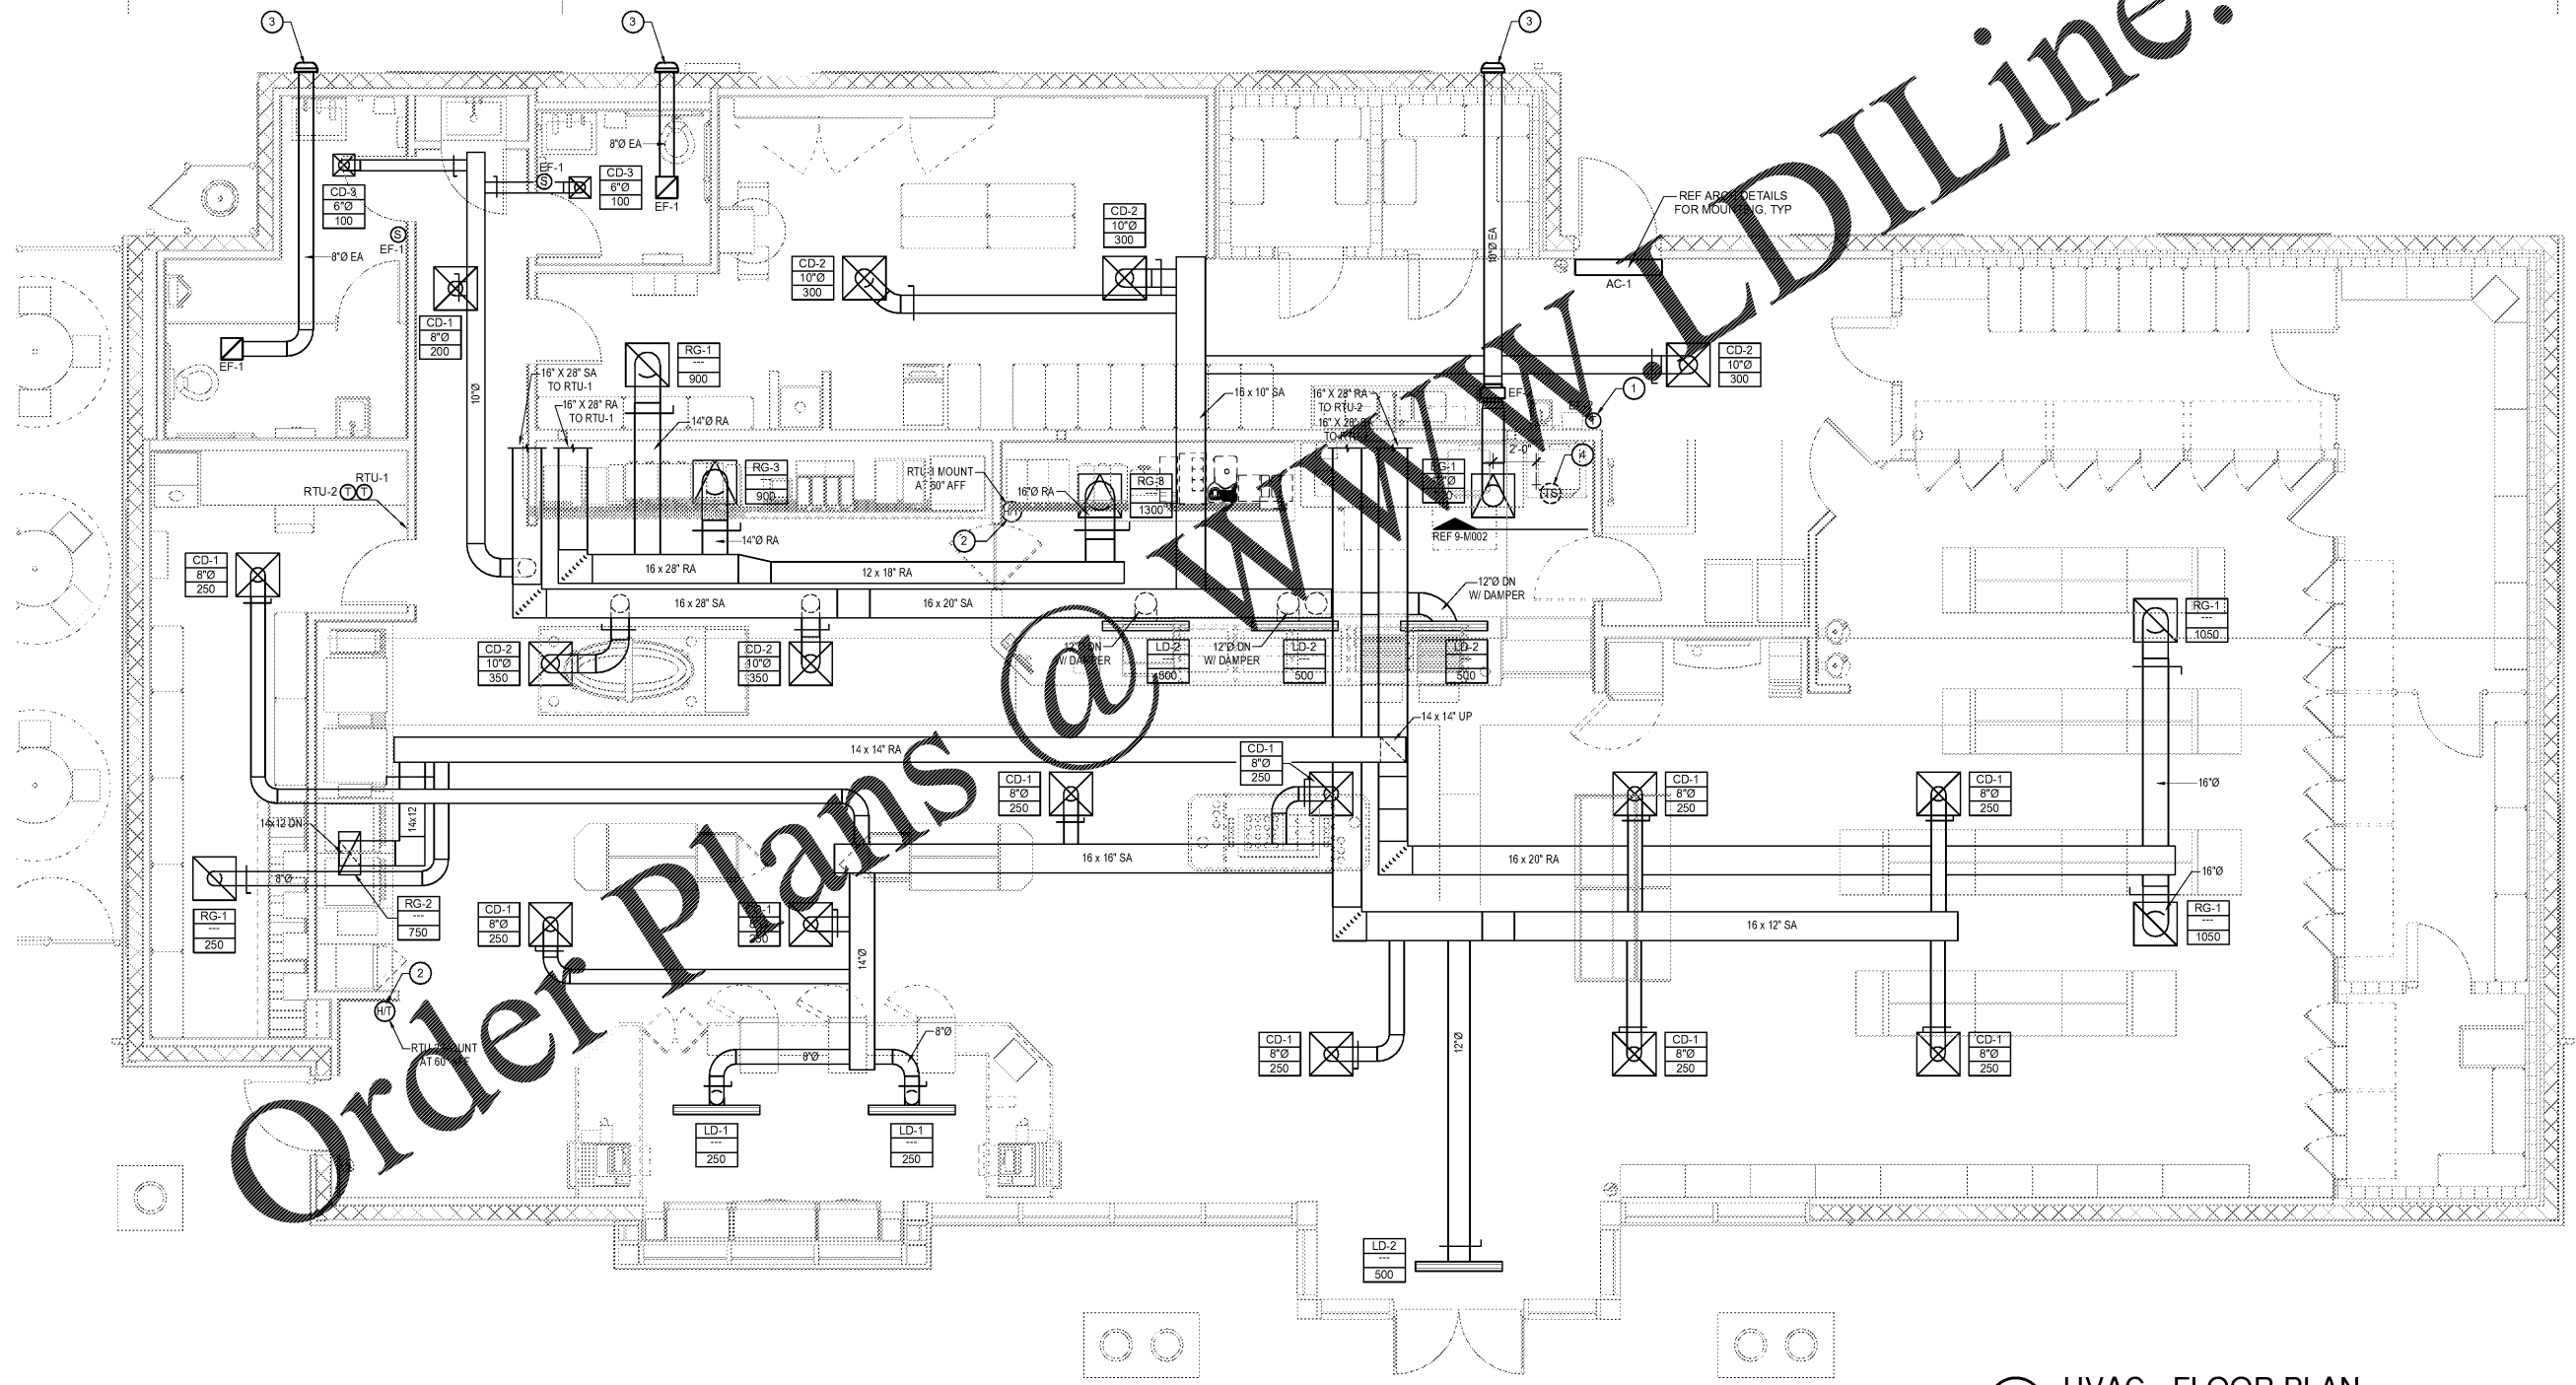

Order Plans @ www.LDLine.com

1 HVAC - FLOOR PLAN
 SCALE: 1/4"=1'-0"