

REFRIGERATION SCHEDULE

ALL PRODUCTS ON THIS SCHEDULE ARE FURNISHED BY OWNER AND INSTALLED BY CONTRACTOR

CIRCUIT No.	AREA SERVED	CIRCUIT INFORMATION		PIPE SIZE		MANUFACTURER	MODEL	REFRIG-ERANT	EVAPORATOR		ELECTRICAL DATA				CON. PIPE SIZE		
		EVAP (°F)	Est. Dev. Length (ft)	Liquid	Suction				CAPACITY BTU/HR	PHASE	Volts	Watts	MCA	MOCP	LIQUID	SUCTION	
C-1	FBD	-30°	0	3/8"	* 5/8"	KIRWAN	12-7462-0007	R-404A		19,000						3/8"	5/8"
C-2	FBD	-30°	0	3/8"	* 5/8"	KIRWAN	12-7462-0007	R-404A		19,000						3/8"	5/8"
C-3	COFFEE BAR ICE MAKER	-30°	0	3/8"	* 5/8"	MANITOWOC ICE	IYF0600-161	R-404A		13,900							
C-4	WALK-IN STORAGE COOLER	25°	0	3/8"	5/8"	LARKIN	LCA690SB	R-448A	1400	9,000	208	1	118	1.1	20	1/2"	7/8"
C-5	6" SANDWICH CASE	20°	0	3/8"	7/8"	STRUCT CONCEPTS	HMO7553R	R-404A		5,475	120	1	200	2	15		
C-6	6" SANDWICH CASE	20°	0	3/8"	7/8"	STRUCT CONCEPTS	HMO7553R	R-404A		5,475	120	1	200	2	15		
C-7	6" SANDWICH CASE	20°	0	3/8"	7/8"	STRUCT CONCEPTS	HMO7553R	R-404A		5,475	120	1	200	2	15		
C-8	CHILL ZONE ICE MAKER	-30°	0	3/8"	* 1/2"	MANITOWOC ICE	IY70500N-161	R-410A		6,900							
C-9	CHILL ZONE ICE MAKER	-30°	0	3/8"	* 1/2"	MANITOWOC ICE	IY70500N-161	R-410A		6,900							
C-10	WALK-IN STORAGE FREEZER	-20°	0	3/8"	7/8"	LARKIN	LCE694SB	R-448A	1300	9,400	208	1	1800	8.7	20	1/2"	7/8"
C-11	WALK-IN COOLER	25°	0	1/2"	7/8"			R-448A									
C-11A				3/8"	5/8"	LARKIN	LCA6110SB		1300	11,000	208	1	118	1.1	20	1/2"	7/8"
C-11B				3/8"	5/8"	LARKIN	LCA6110SB		1300	11,000	208	1	118	1.1	20	1/2"	7/8"
C-11C				3/8"	5/8"	LARKIN	LCA6110SB		1300	11,000	208	1	118	1.1	20	1/2"	7/8"
C-11D				3/8"	7/8"												
C-12	BEER CAVE	25°	0	3/8"	7/8"												
C-12A				3/8"	7/8"	LARKIN	ACM102SE	R-448A	1220	10,200	208	1	110	1.0	20	1/2"	7/8"
C-12B				3/8"	7/8"	LARKIN	ACM102SE	R-448A	1220	10,200	208	1	110	1.0	20	1/2"	7/8"
C-13	WALK-IN COOLER	25°	0	1/2"	7/8"												
C-13A				3/8"	5/8"	LARKIN	LCA6110SB		1300	11,000	208	1	118	1.1	20	1/2"	7/8"
C-13B				3/8"	5/8"	LARKIN	LCA6110SB		1300	11,000	208	1	118	1.1	20	1/2"	7/8"
C-14	WALK-IN FREEZER	-20°	0	3/8"	7/8"	LARKIN	LCE694SB	R-448A	1300	9,400	208	1	1800	8.7	20	1/2"	7/8"

* DISCHARGE LINE FROM COMPRESSOR TO REMOTE CONDENSER ON ROOF. COMPRESSOR LOCATED INSIDE THE BUILDING.

GENERAL NOTES (APPLIES TO ALL UNITS):

- REFRIGERANT PIPING SHALL BE SIZED BY MANUFACTURER'S RECOMMENDATIONS BASED ON FIELD CONDITIONS.
- PROVIDE ECM MOTOR
- DISCONNECT TO BE PROVIDED BY ELECTRICAL SUBCONTRACTOR.

PRESSURE LOSS OF LIQUID REFRIGERANTS IN LIQUID LINE RISERS (EXPRESSED IN PRESSURE DROP, PSIG, AND SUBCOOLING LOSS, °F)

REFRIGERANT	LIQUID LINE RISE IN FEET																	
	10'	15'	20'	25'	30'	40'	50'	75'	100'									
R448A	4.3	1.1	6.5	1.7	8.7	2.3	10.9	2.8	13	3.4	17.4	4.5	21.7	5.6	32.6	8.3	43.5	10.9

BASED ON 110°F LIQUID TEMPERATURE AT BOTTOM OF RISER

EQUIVALENT FEET OF PIPE DUE TO VALVE AND FITTING FRICTION

COPPER TUBE, O.D. TYPE "L"	1/2"	5/8"	7/8"	1-1/8"	1-3/8"	1-5/8"	2-1/8"	2-5/8"	3-1/8"	3-5/8"	4-1/8"	5-1/8"	6-1/8"
GLOBE VALVE (OPEN)	14	16	22	28	36	42	57	69	83	99	118	138	168
ANGLE VALVE (OPEN)	7	9	12	15	18	21	28	34	42	49	57	70	83
90° TURN THROUGH TEE	3	4	5	6	8	9	12	14	17	20	22	28	34
TEE (STRAIGHT THROUGH)	0.75	1	0.15	2	2.5	3	3.5	4	5	6	7	9	11
OR SWEEP BELOW													
90° ELBOW OR REDUCING	1	2	2	3	4	4	5	7	8	10	12	14	16
TEE (STRAIGHT THROUGH)													

INSULATION THICKNESS BASED ON SEVERE DESIGN CONDITIONS*

	LINE TEMPERATURE		
	35°F (2°C)	0°F (-18°C)	-20°F (-29°C)
3/8" ID THROUGH 1-1/8" ID	NOM 1"	NOM 1-1/2"	NOM 1-1/2"
OVER 1-5/8" ID THROUGH 3-5/8" ID	NOM 1"	NOM 1-1/2"	NOM 1-3/4"
OVER 3-5/8" ID THROUGH 6" IPS	NOM 1"	NOM 1-1/2"	NOM 2"

NOTES:
*BASED ON SEVERE DESIGN CONDITIONS OF 90°F AND 80% RH.

INSULATION THICKNESS BASED ON NORMAL DESIGN CONDITIONS*

	LINE TEMPERATURE		
	35°F (2°C)	0°F (-18°C)	-20°F (-29°C)
3/8" ID THROUGH 1-1/8" ID	NOM 1/2"	NOM 3/4"	NOM 1"
OVER 1-1/8" ID THROUGH 2-1/8" ID	NOM 1/2"	NOM 1"	NOM 1"
OVER 2-1/8" ID THROUGH 2-5/8" ID	NOM 1/2"	NOM 1"	NOM 1-1/4"
OVER 2-5/8" ID THROUGH 6" IPS	NOM 1"	NOM 1"	NOM 1-1/4"


NOTES:
*BASED ON NORMAL DESIGN CONDITIONS OF 85°F AND 70% RH.

GENERAL NOTES

- PROVIDE 1" CONDENSATE DRAIN PIPE FROM EACH UNIT COOLER TO DRAIN LINE PROVIDED BY PLUMBING. SEE PLUMBING DRAWINGS FOR LOCATION. REFER TO SPECIFICATION FOR PIPE COPPER TYPE.
- CZ ICE MAKER, (2) FBD FROZEN BEVERAGE, SANDWICH COOLER & ICE DISPENSER RSL & RLL PIPING RUNS ARE SHOWN FOR COORDINATION PURPOSES ONLY. EQUIPMENT IS BY OTHERS. RSL & RLL LOCATIONS AND SIZING SHALL BE ACCORDING TO MANUFACTURER'S RECOMMENDATIONS.
- EXACT LOCATION AND LENGTH OF RSL & RLL PIPING RUNS TO EQUIPMENT SHALL BE DETERMINED IN FIELD. FINAL SIZES TO BE DETERMINED BY FINAL ROUTING.
- REFRIGERANT LIQUID AND SUCTION PIPE SIZES SHALL BE VERIFIED BY EQUIPMENT MANUFACTURER (TYPICAL).
- ALL TUBING REFRIGERANT LINES SHALL BE TYPE L HARD DRAWN PIPE. SOFT DRAWN COPPER ASTM B280, REFRIGERANT GADE, BRAIDED LINE SETS SHALL ONLY BE USED AS SHOWN ON PLANS.
- ALL REFRIGERANT PIPE SETS SHALL BE INSULATED WITH BIRCELOR P-ARM-FLEX TUBE INSULATION TO THE THICKNESS SHOWN ON THE INSULATION THICKNESS SCHEDULES ON SHEET R140.
- REFRIGERATION CIRCUITS ARE SHOWN AS ONE (1) LINE ON PLANS BUT CONSIST OF BOTH LIQUID AND SUCTION LINES.
- REFRIGERATION DRAWINGS ARE PROVIDED AS AN AID TO BIDDING AND TO INDICATE DESIRED ROUTING OF REFRIGERATION LINES. CONTRACTOR SHALL ASSUME FULL RESPONSIBILITY FOR CORRECT INSTALLATION OF PIPING AND ACCESSORIES TO PROVIDE A COMPLETE AND FULLY OPERATING SYSTEM.
- PROVIDE INTERMEDIATE SUCTION LINE TRAP IN WALL OR VOID SPACE AT THE MIDPOINT OF A SUCTION LINE DROP WHICH EXCEEDS 16 FT. REFER TO INTERMEDIATE SUCTION LINE TRAP DETAIL ON SHEET P501.
- AT ALL POINTS WHERE SUCTION LINES RISE 48" OR MORE, PROVIDE A SHORT RADIUS SUCTION LINE TRAP AT THE BASE OF THE RISER. REFER TO INTERMEDIATE SUCTION LINE TRAP DETAIL ON SHEET P501.

KEYNOTES

- RSL & RLL TO DROP IN WALL AND SHALL CONTINUE IN 4" CONDUIT WITHOUT BENDS IN SLAB TO CONNECT TO SANDWICH COOLERS. 4" CONDUIT PROVIDED BY G.C.
- PROVIDE AND INSTALL 6'-0" LENGTH OF FLEXIBLE, BRAIDED RSL & RLL AT FBD DISPENSERS TO ALLOW UNITS TO BE PULLED FORWARD FOR ACCESS.
- CONCEAL RSL & RLL VERTICAL DROPS IN WALL.
- PROVIDE AND INSTALL 3'-0" LENGTH OF FLEXIBLE, BRAIDED RSL & RLL AT CHILLZONE ICE MAKER TO ALLOW UNITS TO BE PULLED FORWARD FOR ACCESS.

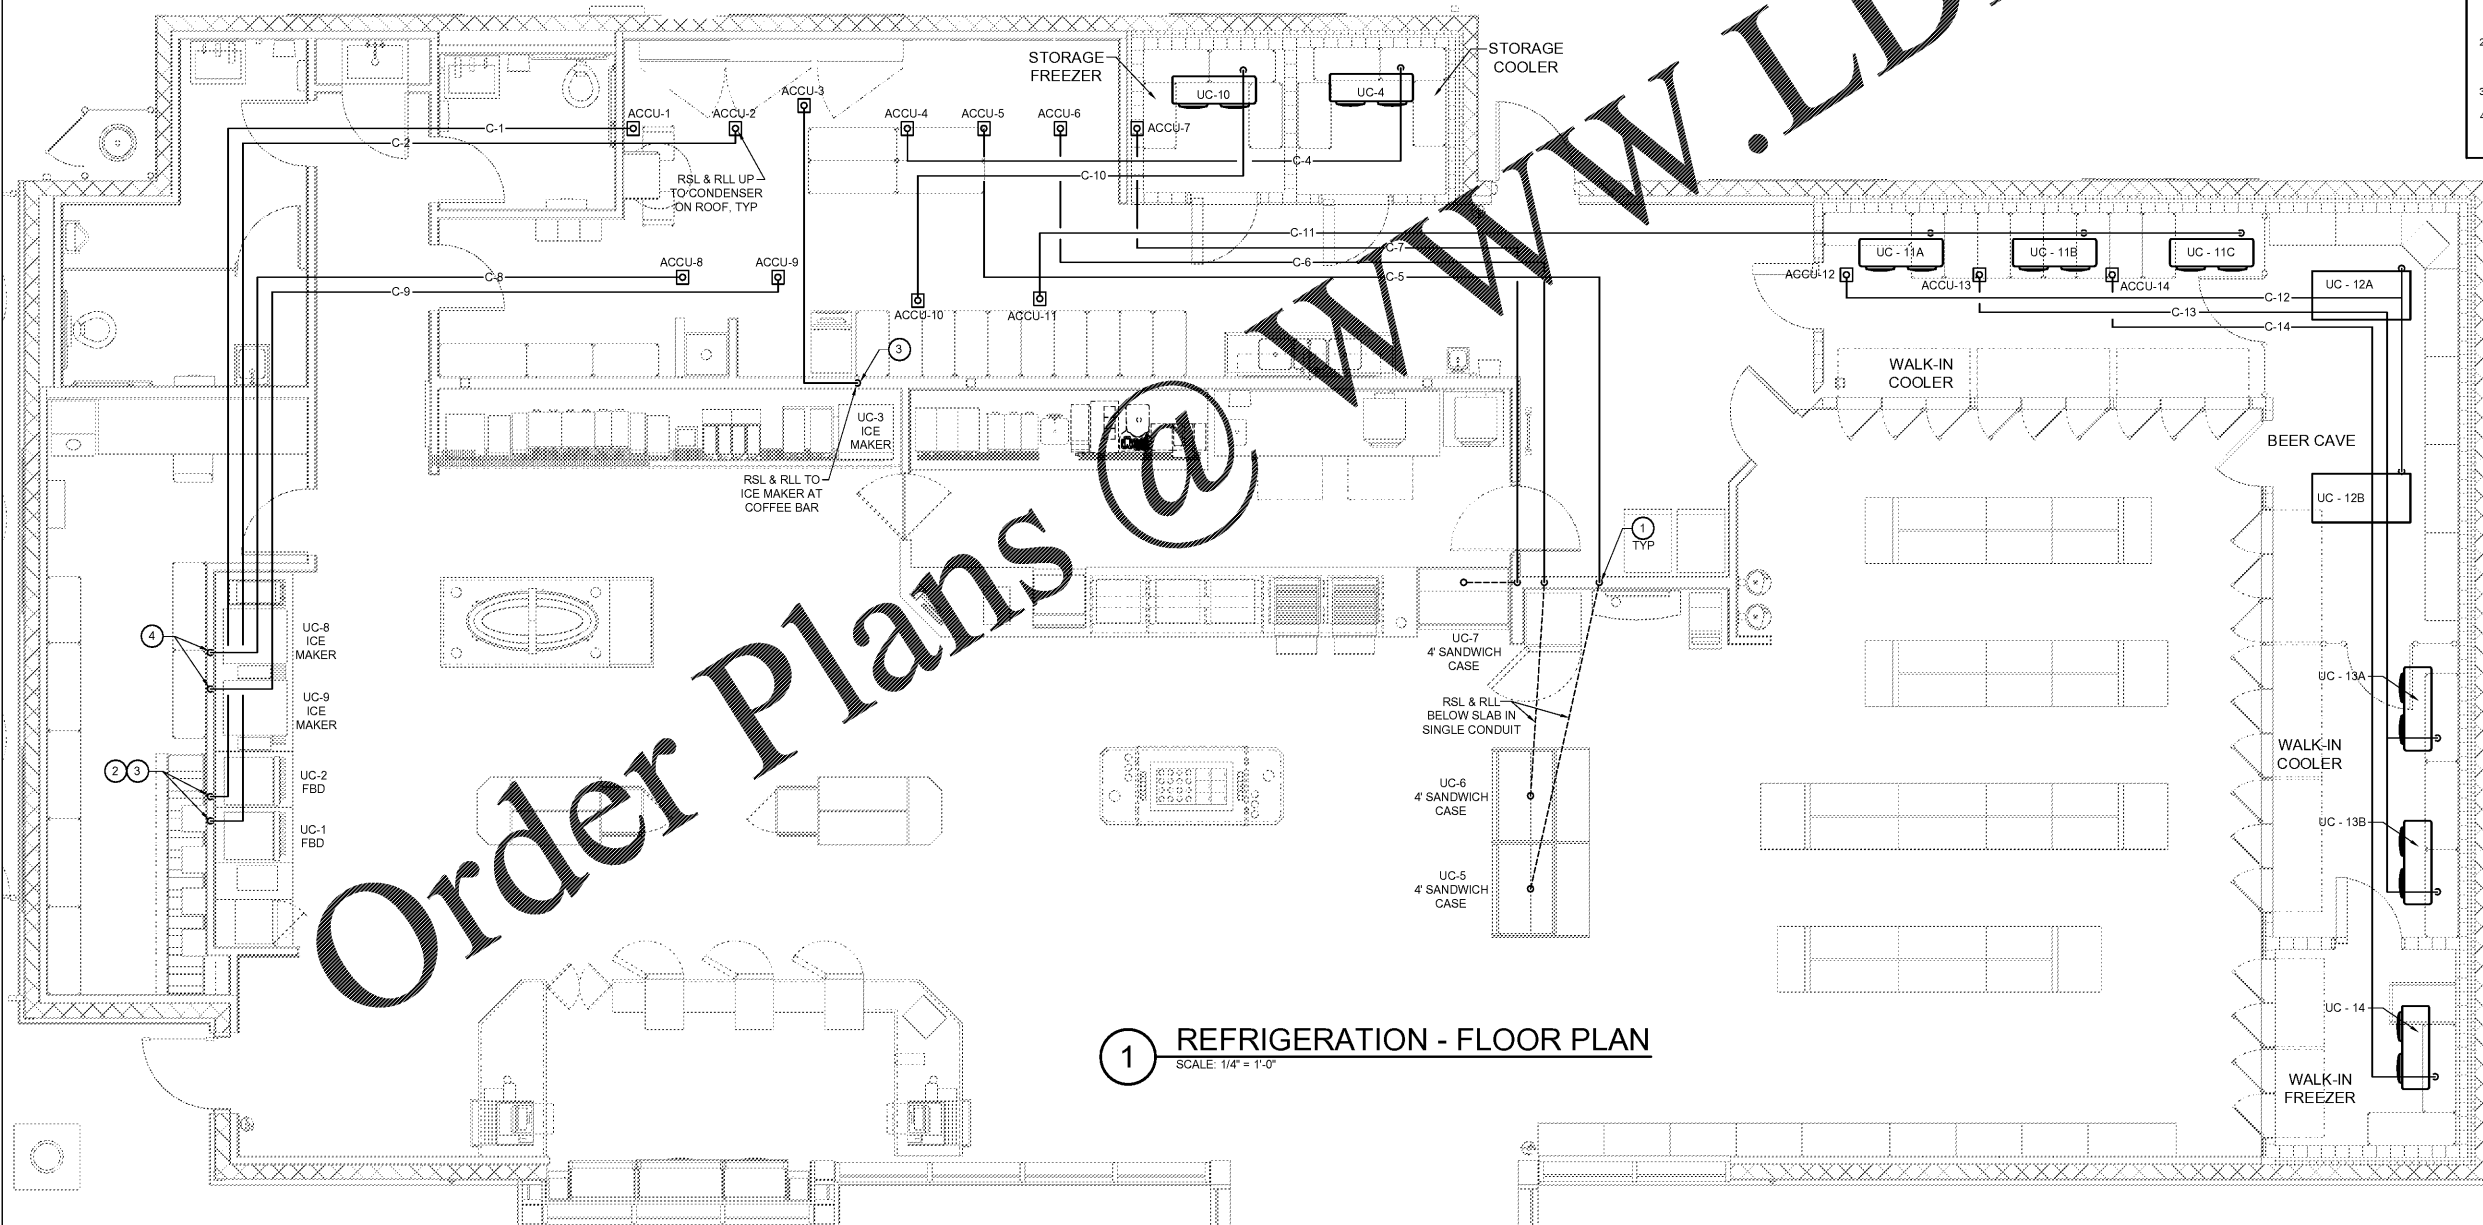

1 REFRIGERATION - FLOOR PLAN
SCALE: 1/4" = 1'-0"

HFA
HARRISON FRENCH ASSOCIATES, LTD.
1479.273.7780
1705 S. Walton Blvd, Suite 3
Bentonville, Arkansas 72712
www.hfa-ae.com

STIPULATION FOR REUSE
THIS DRAWING WAS PREPARED FOR THE PROJECT IDENTIFIED AT THE TOP OF THIS SHEET. IT IS NOT TO BE REUSED FOR ANY OTHER PROJECT WITHOUT THE WRITTEN CONSENT OF HARRISON FRENCH ASSOCIATES, LTD. USE OF THIS DRAWING FOR RESIDENTIAL OR COMMERCIAL PROJECTS WITHOUT THE WRITTEN CONSENT OF HARRISON FRENCH ASSOCIATES, LTD. IS PROHIBITED. PROJECT IS NOT AUTHORIZED ANY REUSE OF THIS DRAWING.

Cumberland
SUNRISE & 4TH
FORT LAUDERDALE, FL 33304
JOB NUMBER: 41-17-00410

ISSUE BLOCK

90% CDs	05/10/19
100% Set	06/14/19
90% AIM4.0	08/14/19
100% AIM4.0	09/11/19

CHECKED BY: BRT
DRAWN BY: BRT

2019 09 11 21:22:11-05'00"
Greg Schussman, P.E.
License #72212
Harrison French & Associates, LTD.
CDA #02421
Filled copies of this document are not considered signed and sealed and the signature must be verified on any electronic copies.

REFRIGERATION FLOOR PLAN AND SCHEDULES