

STIPULATION FOR REUSE  
 THIS DRAWING WAS PREPARED FOR THE PROJECT IDENTIFIED HEREIN. IT IS NOT TO BE REUSED FOR ANY OTHER PROJECT WITHOUT THE WRITTEN CONSENT OF HARRISON FRENCH ASSOCIATES, LTD. THE USER OF THIS DRAWING FOR ANY OTHER PROJECT IS RESPONSIBLE FOR OBTAINING THE NECESSARY PERMISSIONS FROM HARRISON FRENCH ASSOCIATES, LTD. HARRISON FRENCH ASSOCIATES, LTD. DOES NOT WARRANT THE ACCURACY OR COMPLETENESS OF THIS PROJECT. PROJECT IS NOT AUTHORIZED TO BE REPRODUCED OR TRANSMITTED IN ANY FORM OR BY ANY MEANS, ELECTRONIC OR MECHANICAL, INCLUDING PHOTOCOPYING, RECORDING, OR BY ANY INFORMATION STORAGE AND RETRIEVAL SYSTEM.

**Cumberland**  
 SUNRISE & 4TH  
 FORT LAUDERDALE, FL 33304  
 JOB NUMBER: 41-17-00410

ISSUE BLOCK	
90% CDs	05/10/19
100% Set	06/14/19
90% AIM4.0	08/14/19
100% AIM4.0	09/11/19


CHECKED BY: BRT  
 DRAWN BY: BRT




2019.08.11 21:28:02-0500  
 Greg Schluter, P.E.  
 License #72212  
 Harrison French & Associates, LTD.  
 CDA #02421  
 Filled copies of this document are not considered signed and sealed and the signature must be verified on any electronic copies.

PLUMBING  
 SANITARY  
 PLAN

SHEET: **P100**

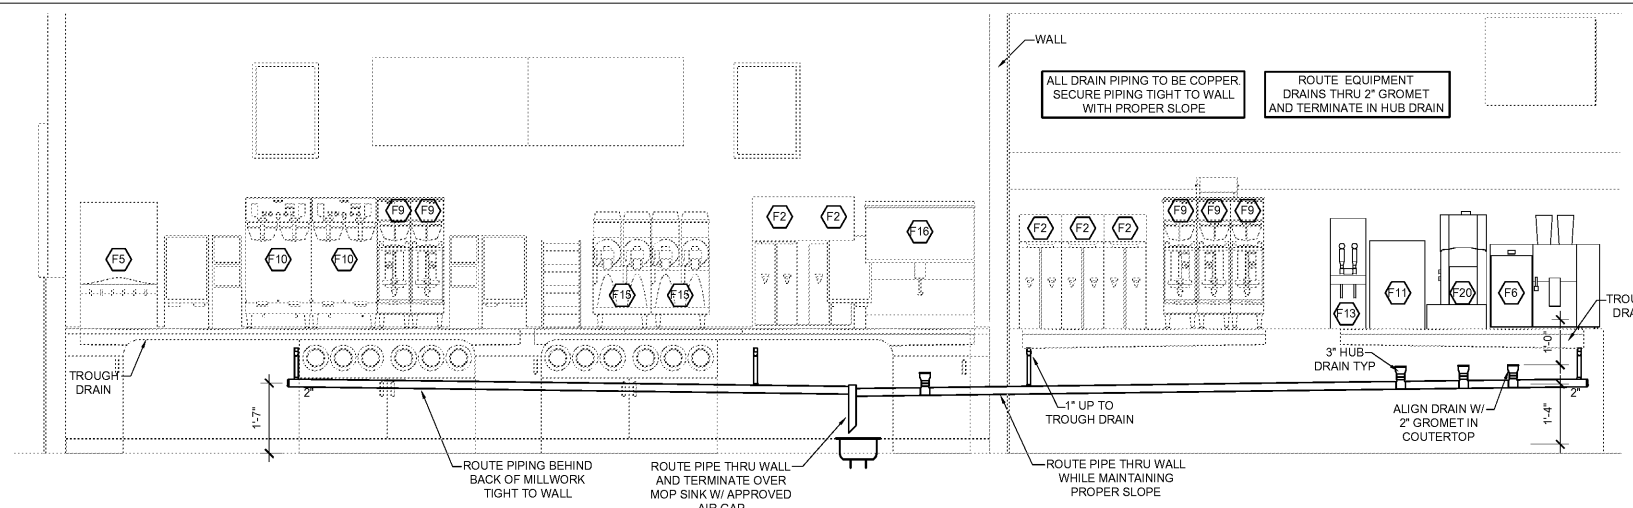

**2** EQUIPMENT DRAIN ELEVATION  
 SCALE: N.T.S.

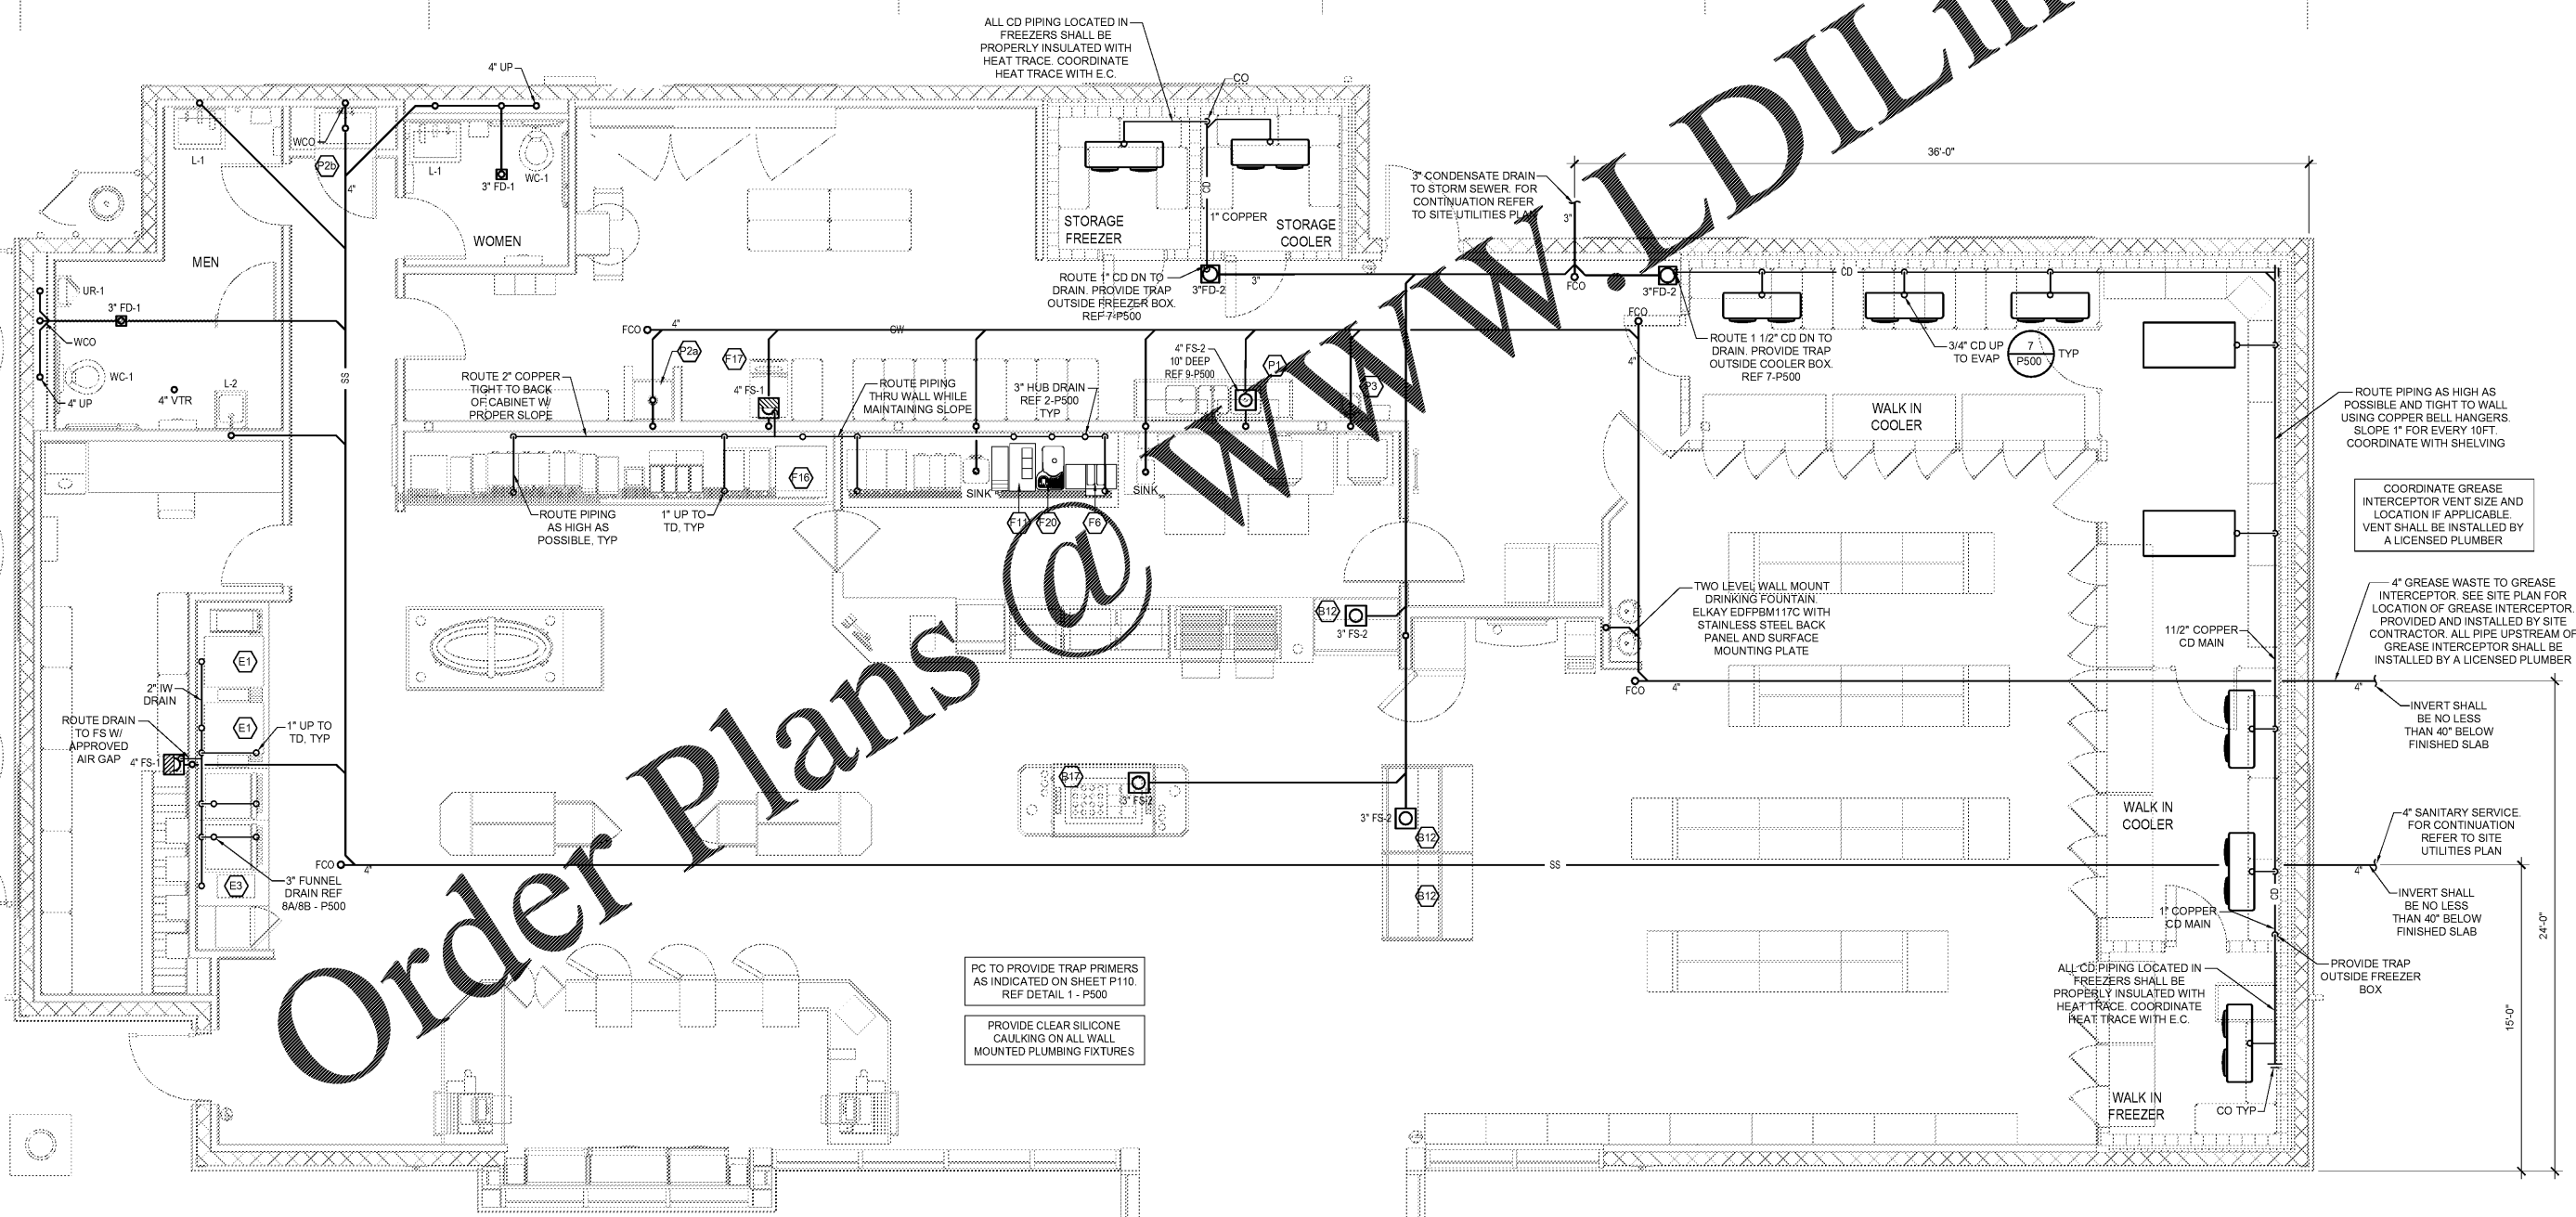

**1** PLUMBING - SANITARY PLAN  
 SCALE: 1/4" = 1'-0"

**Order Plans @ WWW.DILine.com**

PC TO PROVIDE TRAP PRIMERS AS INDICATED ON SHEET P110. REF DETAIL 1 - P500  
 PROVIDE CLEAR SILICONE CAULKING ON ALL WALL MOUNTED PLUMBING FIXTURES

ROUTE PIPING AS HIGH AS POSSIBLE AND TIGHT TO WALL USING COPPER BELL HANGERS. SLOPE 1" FOR EVERY 10FT. COORDINATE WITH SHELVING

COORDINATE GREASE INTERCEPTOR VENT SIZE AND LOCATION IF APPLICABLE. VENT SHALL BE INSTALLED BY A LICENSED PLUMBER

4" GREASE WASTE TO GREASE INTERCEPTOR. SEE SITE PLAN FOR LOCATION OF GREASE INTERCEPTOR PROVIDED AND INSTALLED BY SITE CONTRACTOR. ALL PIPE UPSTREAM OF GREASE INTERCEPTOR SHALL BE INSTALLED BY A LICENSED PLUMBER

INVERT SHALL BE NO LESS THAN 40" BELOW FINISHED SLAB

4" SANITARY SERVICE FOR CONTINUATION REFER TO SITE UTILITIES PLAN

INVERT SHALL BE NO LESS THAN 40" BELOW FINISHED SLAB

PROVIDE TRAP OUTSIDE FREEZER BOX

ALL CD PIPING LOCATED IN FREEZERS SHALL BE PROPERLY INSULATED WITH HEAT TRACE. COORDINATE HEAT TRACE WITH E.C.

3" CONDENSATE DRAIN TO STORM SEWER. FOR CONTINUATION REFER TO SITE UTILITIES PLAN

ALL CD PIPING LOCATED IN FREEZERS SHALL BE PROPERLY INSULATED WITH HEAT TRACE. COORDINATE HEAT TRACE WITH E.C.