

GENERAL NOTES

- E.C. TO PROVIDE LIQUID TIGHT FLEXIBLE CONDUIT BETWEEN DISCONNECT SWITCH AND ROOF TOP UNITS, 3 FEET MAXIMUM.
- E.C. TO COORDINATE WITH THE MECHANICAL CONTRACTOR THE FINAL LOCATIONS FOR ALL ROOF TOP UNITS PRIOR TO ANY ROUGH-IN WORK IS PERFORMED.

KEYNOTES

- |    |  |
|----|--|
| 33 | EQUIPMENT FURNISHED WITH NON-FUSED DISCONNECT. E.C. SHALL MAKE ELECTRICAL CONNECTIONS.   |
| 34 | EQUIPMENT FURNISHED WITH POWERED WP/WV GFI RECEPTACLE.   |
| 37 | INTERIOR SIGNAGE: NOT TO BE TIED INTO LIGHTING CONTACTORS. TO BE POWERED ON/OFF BY BREAKER.  |
| 38 | EXTERIOR SIGNAGE: CIRCUIT TO BE TIED INTO LIGHTING CONTACTORS IN CPI PANEL - ZONE 2 (SITE/EXT LIGHTS) PROGRAMING TO BE COMPLETED BY CPI.                       |
| 39 | RECEPTACLE FOR GSM CELLULAR AMPLIFIER. FINAL LOCATION TO BE COORDINATED WITH CFI VENDOR AND CPM, BASED ON RESULTS OF CELL SIGNAL SITE SURVEY BY THE INSTALLER. |
|    | CHILL ZONE ICE MAKER CONDENSER UNIT POWERED VIA ICE MAKER FEED WITH #12 CU CONDUCTORS. REF 10.   |

**HFA**  
 PROFESSIONAL INSTITUTE  
 HARRISON FRENCH  
 & ASSOCIATES, LTD  
 +479.273.7780  
 1705 S. Walton Blvd, Suite 3  
 Bentonville, Arkansas 72712  
 www.hfa-ae.com

STIPULATION FOR REUSE  
 THIS DOCUMENT IS THE PROPERTY OF HARRISON FRENCH & ASSOCIATES, LTD. IT IS TO BE USED ONLY FOR THE PROJECT AND SITE OR AT A LATER TIME. IT IS NOT TO BE REPRODUCED, COPIED, OR TRANSMITTED IN ANY FORM OR BY ANY MEANS, WITHOUT THE WRITTEN PERMISSION OF HARRISON FRENCH & ASSOCIATES, LTD. UNAUTHORIZED REUSE OR MODIFICATION OF THIS DOCUMENT IS PROHIBITED.

**Cumberland**  
 AN  
 SUNRISE AND 4TH STREET  
 FORT LAUDERDALE, FL  
 JOB NUMBER: 41-17-00410

ISSUE BLOCK		
1	90%CD's	05/10/19
2	100% SET	06/14/19
3	90% AIM 4.0	08/14/19
4	100% AIM 4.0	09/11/19


CHECKED BY: JLB  
 DRAWN BY: KEM  
 DOCUMENT DATE: 08/14/19  
 PROTO:



Jaime A. Castañeda, P.E.  
 License #72199  
 Harrison French & Associates, Ltd.  
 1705 S. Walton Blvd, Suite 3  
 Bentonville, AR 72712  
 Date: 2019.08.11 13:28:05.0297

ELECTRICAL  
 ROOF PLAN

SHEET:  
**E140**

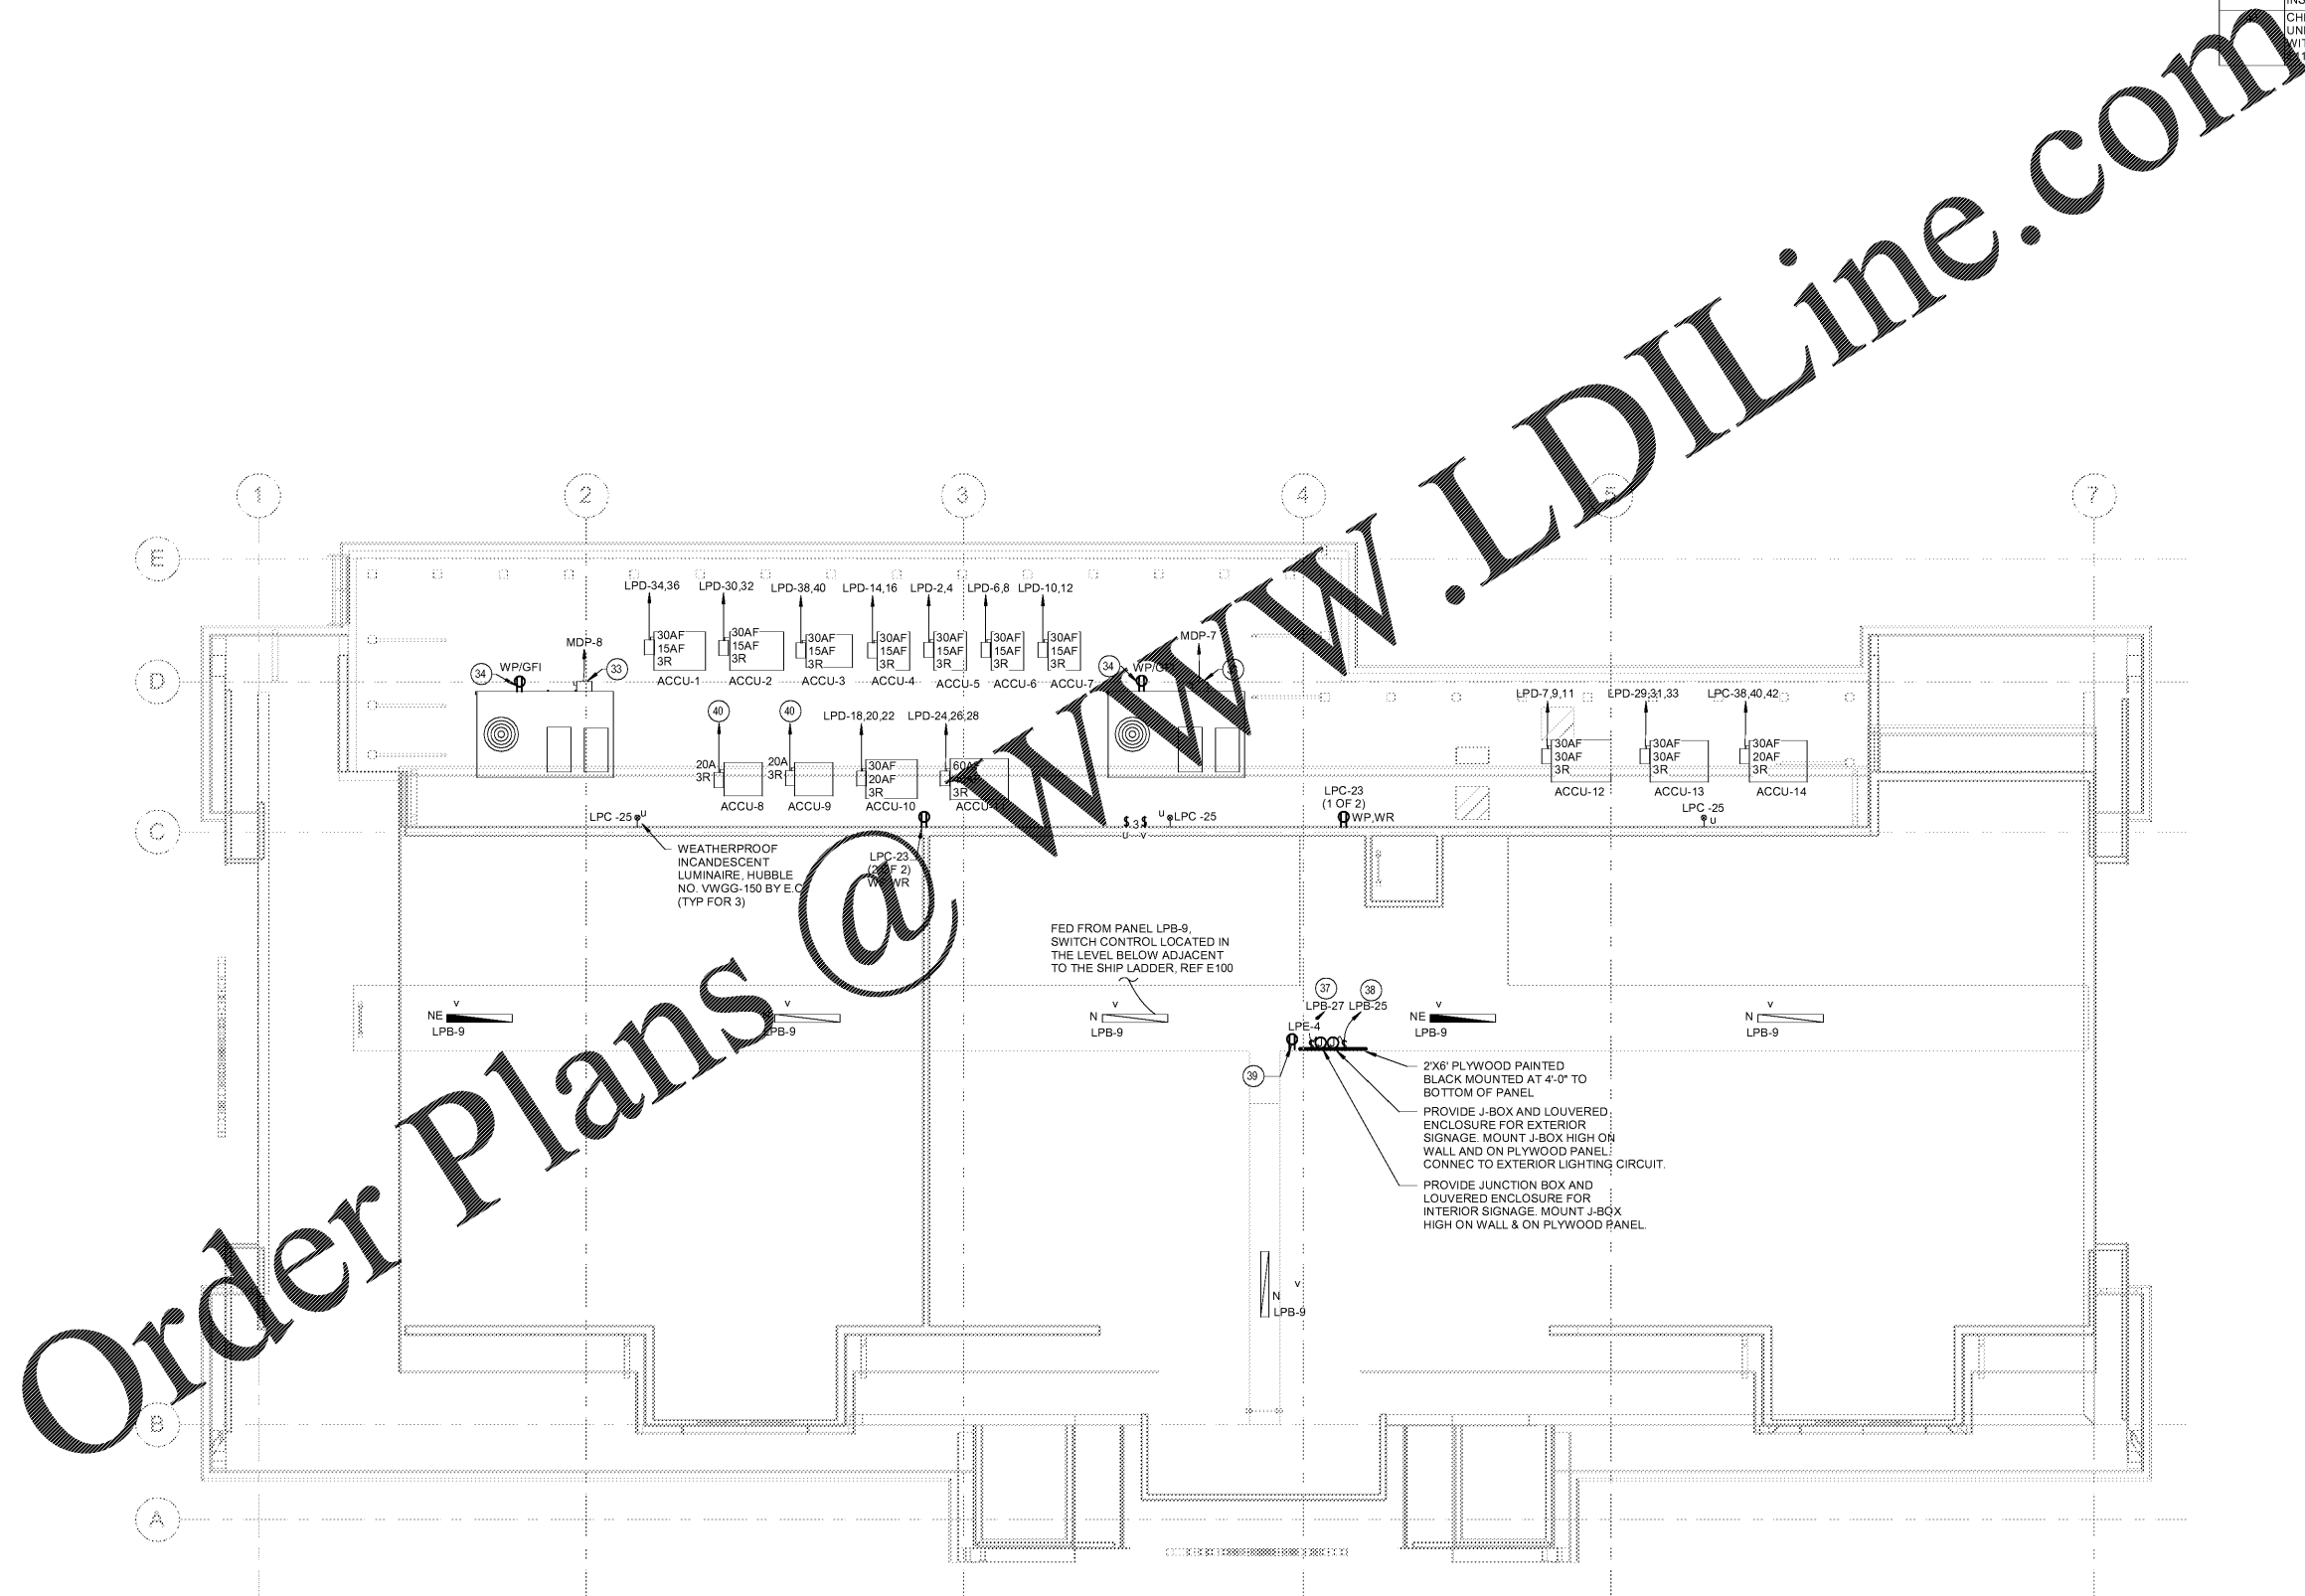

**1** ELECTRICAL - ROOF POWER PLAN  
 3/16" = 1'-0"

9/1/2019 12:11:09 PM  
 C:\Users\jfranz\Documents\2019 Rev\Projects\17-00410\_AEA\PLN\_17-00410\_ELECTRICAL\ROOF.PLAN.dwg  
 PLOT: E140 - ELECTRICAL - ROOF POWER PLAN.dwg