

Order Plans @ WWW.LDILine.com


GENERAL NOTES:

- 1. LOCATE DUCT DETECTOR REMOTE STATIONS FOR DUCT MOUNTED DETECTOR IN ROOM DIRECTLY BELOW UNIT.

KEY NOTES:

- ① FROM DATA-SIDE OF FLOOR BOX EXTEND 1-1/4" BELOW EXISTING SLAB, UP WALL TO 4-1/16" BOX WITH 2-GAUGE PLASTER RING, THEN UP TO ACCESSIBLE CEILING. PROVIDE BUSHING AND PULL STRINGS IN EMPTY CONDUITS
- ② CABLING INSTALLED VIA TELE-POWER POLE AND FLEXIBLE CONNECTION PROVIDED UNDER THIS CONTRACT.

PROVIDE 1-1/4" TO ABOVE ACCESSIBLE CEILING

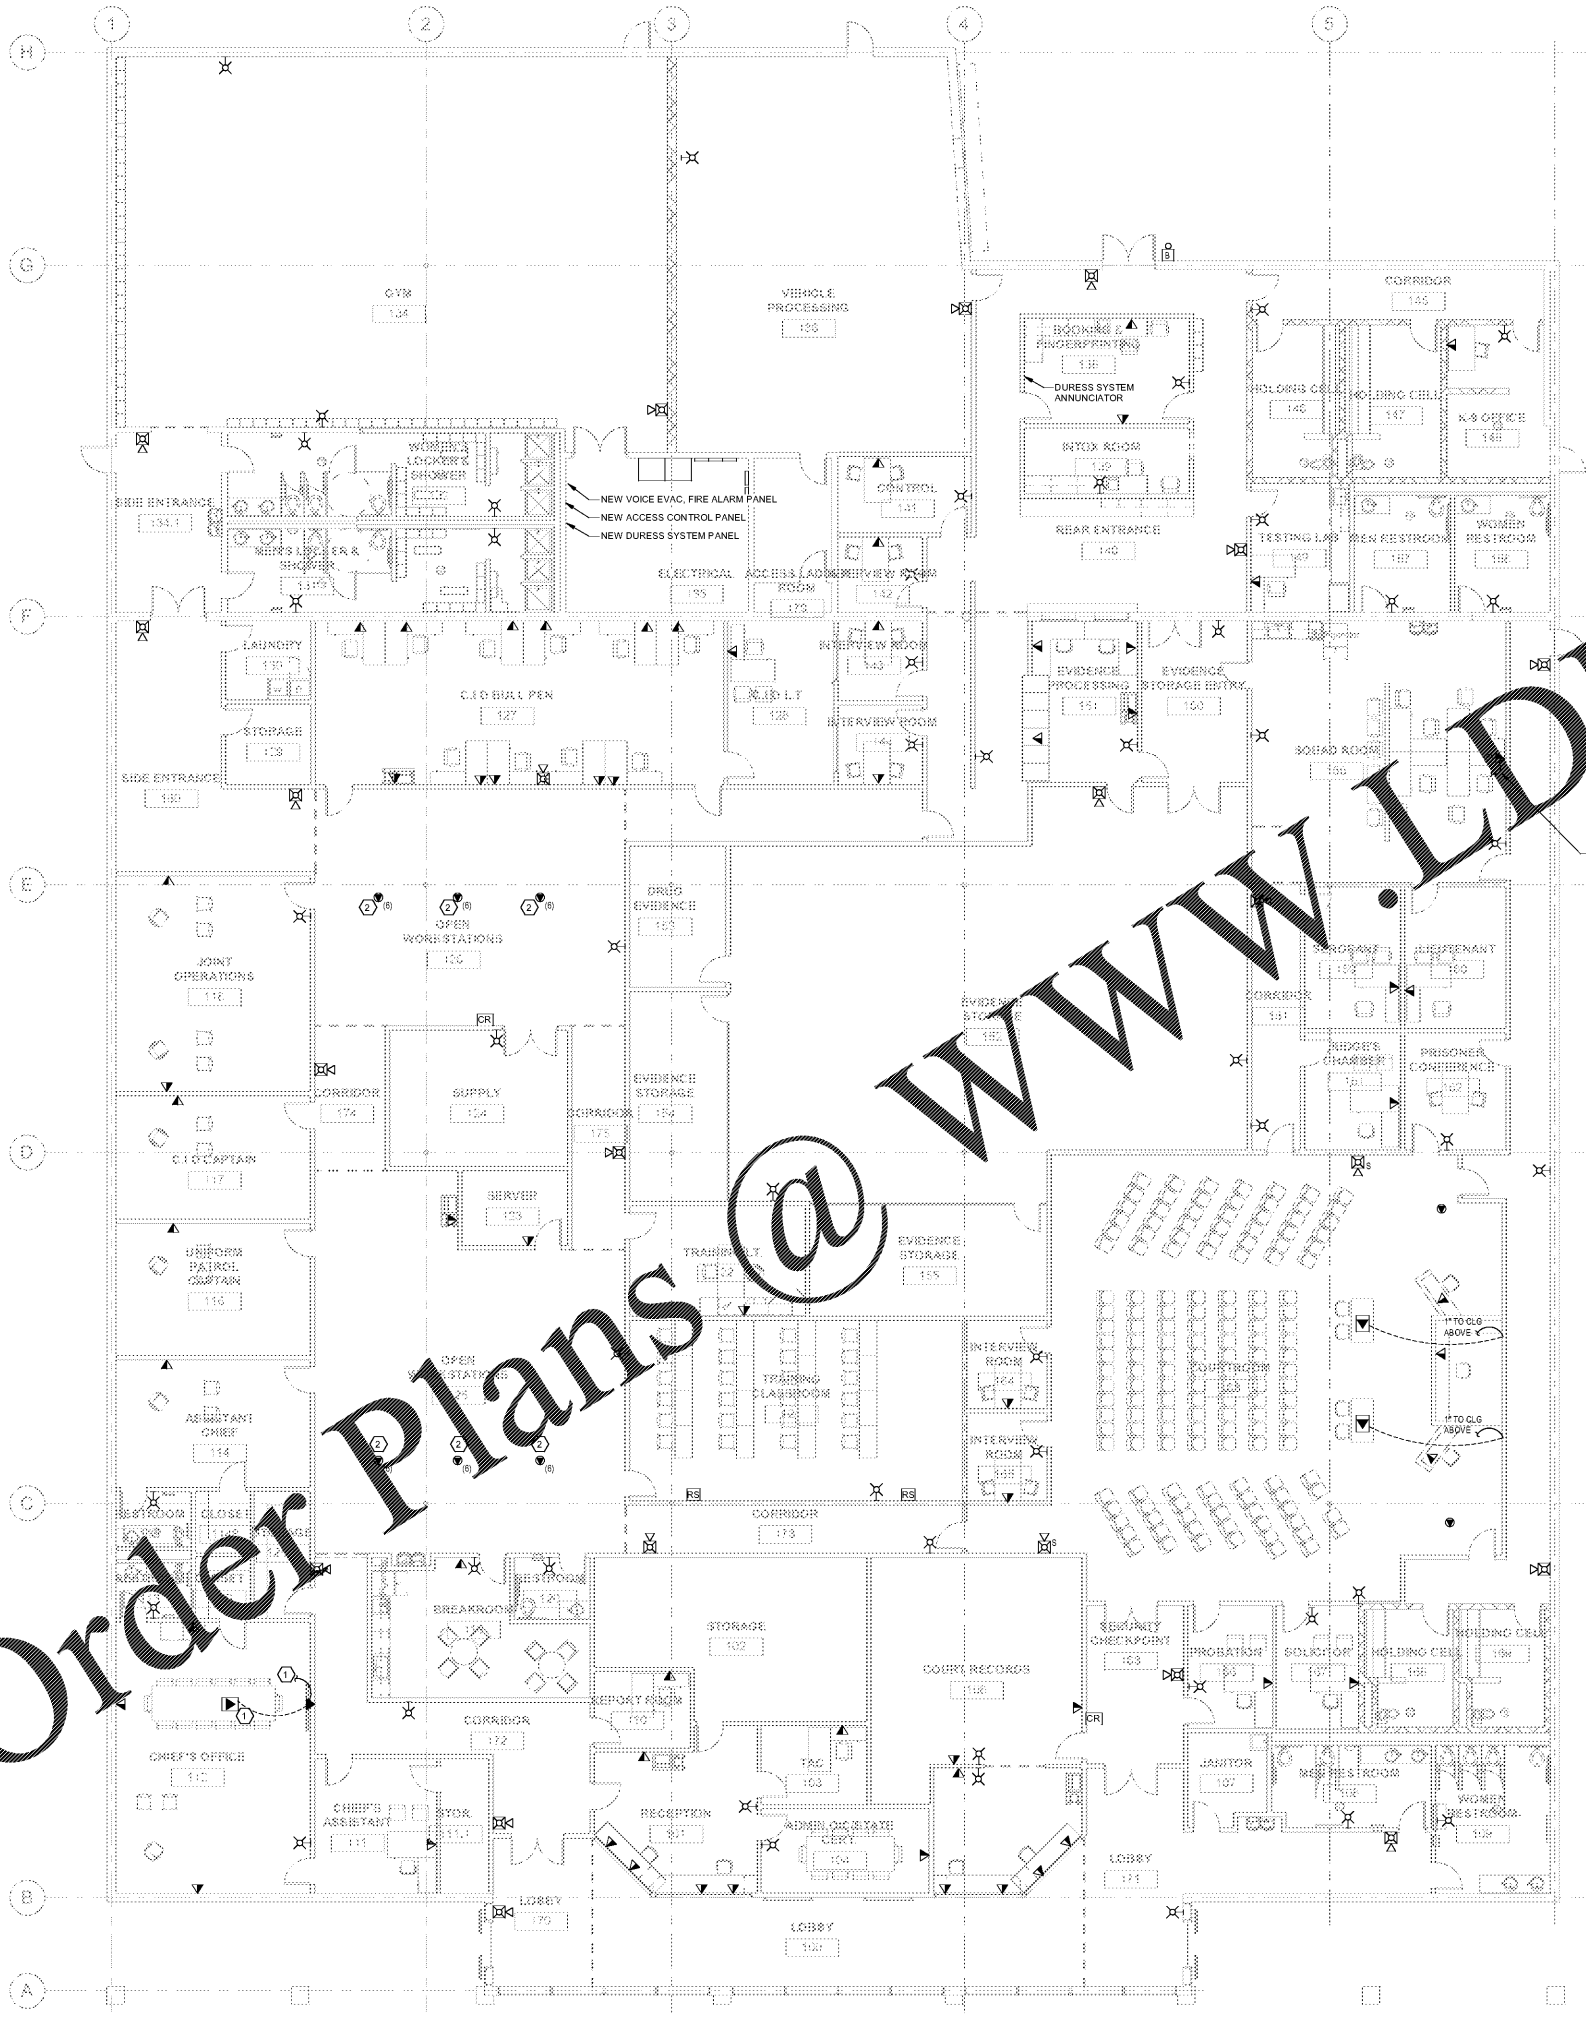

1 ELEC FLOOR PLAN - SYSTEMS
E301 1/8" = 1'-0"

SPENCER BRISTOL ENGINEERING, INC.
A Gray Company
3577 Peachtree Lane, Suite 250
Peachtree Corners, Georgia 30092
Tel: 770.414.8028 Fax: 770.414.6024
SBE Project No. 19096

No.	DESCRIPTION	DATE

**CITY OF MONROE
PUBLIC SAFETY & MUNICIPAL
COURT COMPLEX RENOVATION**
140 BLAINE ST., MONROE, GA 30655

THIS DRAWING IS AN INSTRUMENT OF SERVICE AND SHALL REMAIN THE PROPERTY OF THE ARCHITECT. NO PART OF THIS DOCUMENT SHALL BE REPRODUCED OR TRANSMITTED IN ANY FORM, ELECTRONICALLY OR MECHANICALLY, FOR ANY PURPOSE, WITHOUT THE EXPRESS WRITTEN PERMISSION OF THE ARCHITECT.

ELECTRICAL SYSTEMS

PROJECT # 19160MONRpo
DATE: Issue Date
DRAWN BY: WBS
CHECKED BY: TL

E301

SCALE 1/8" = 1'-0"