



Order Plans @ WWW.LDILine.com

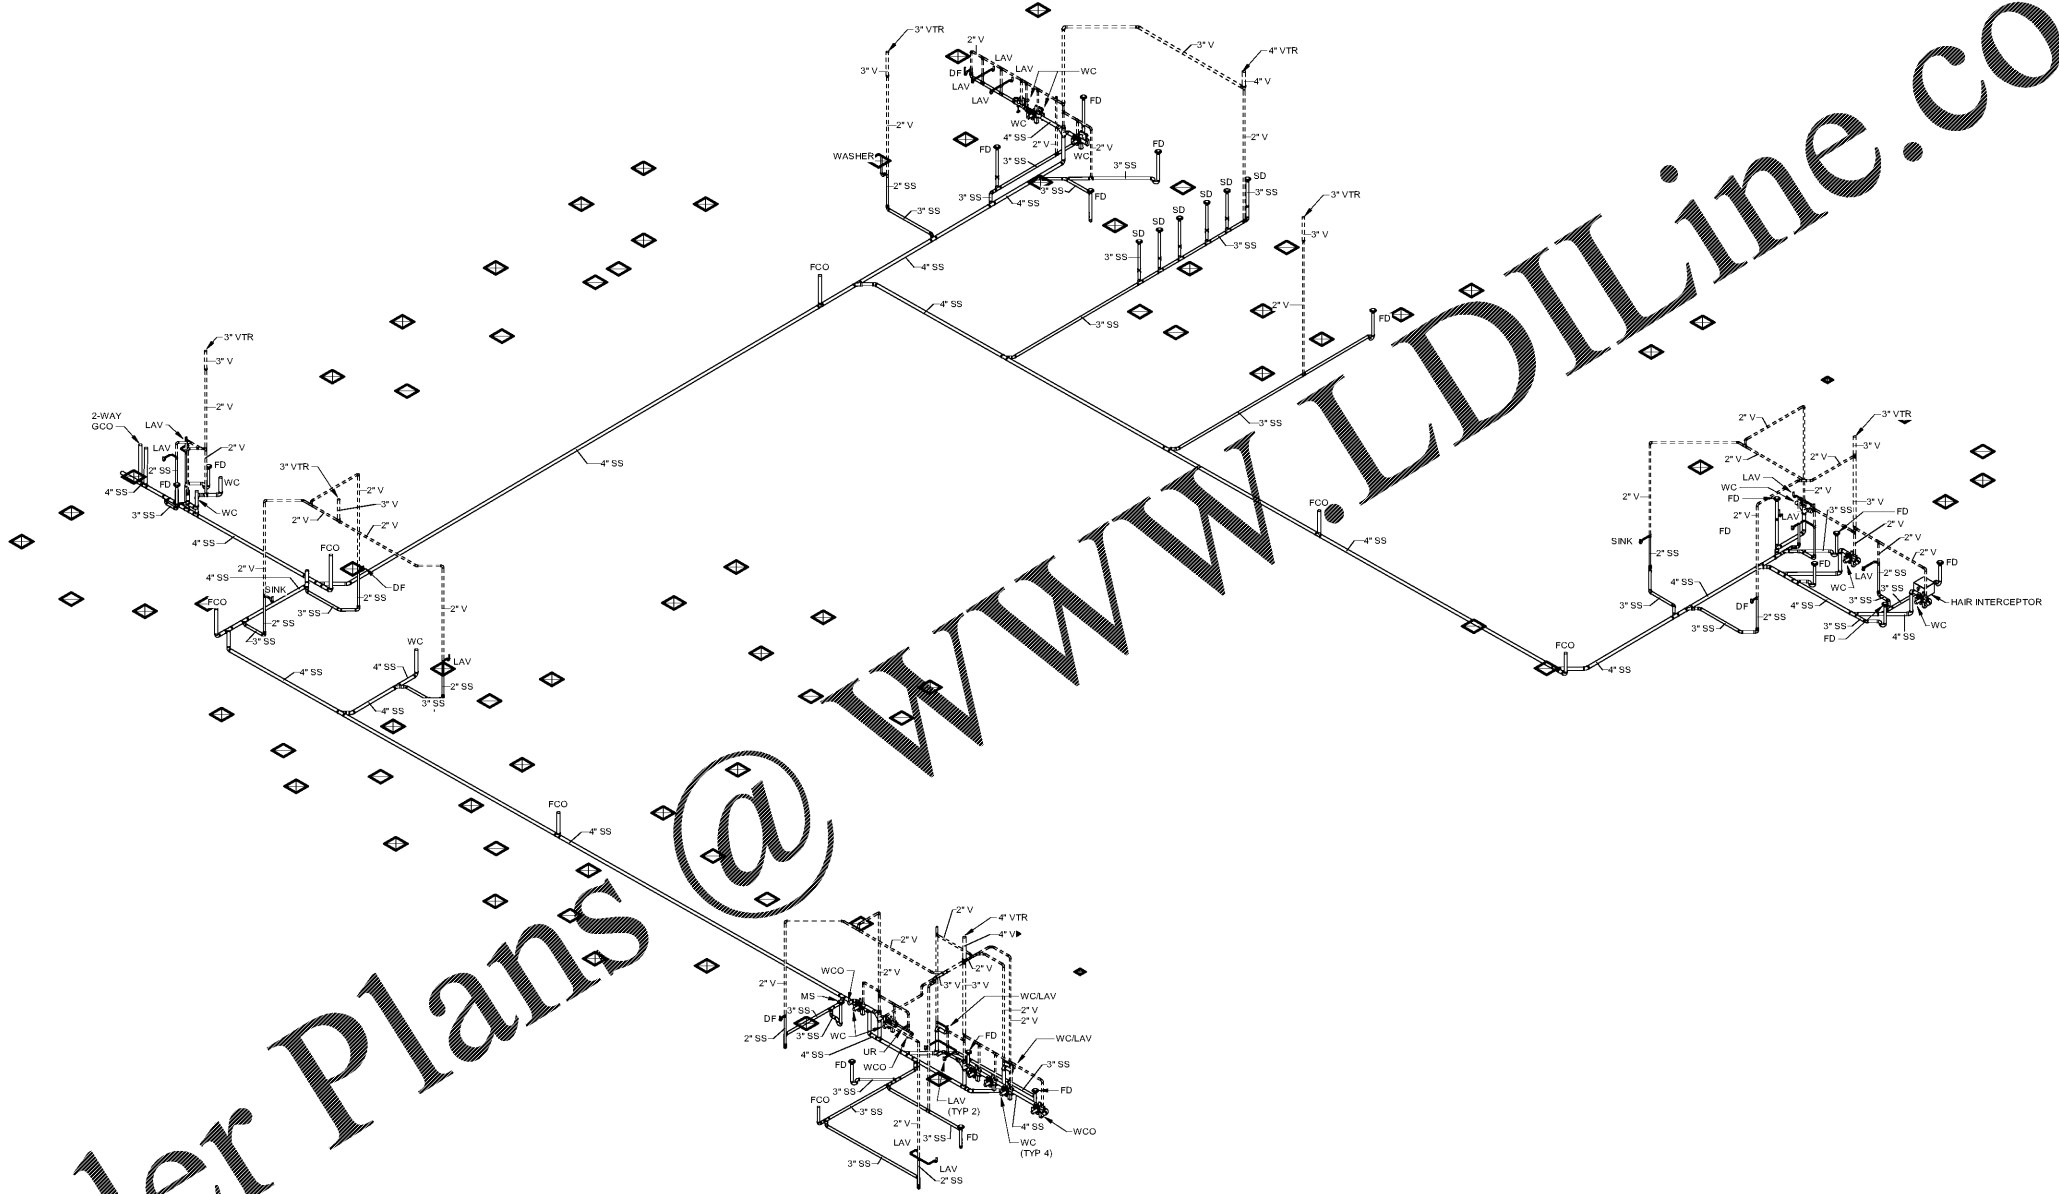

1 SANITARY RISER DIAGRAM
P701

No.	DESCRIPTION	DATE

CITY OF MONROE
PUBLIC SAFETY & MUNICIPAL
COURT COMPLEX RENOVATION
140 BLAINE ST. MONROE, GA 30655

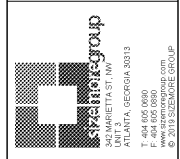

THIS DRAWING IS AN INSTRUMENT OF SERVICE AND SHALL REMAIN THE PROPERTY OF THE ARCHITECT. NO PART OF THIS DOCUMENT SHALL BE REPRODUCED OR TRANSMITTED IN ANY FORM, ELECTRONICALLY OR MECHANICALLY, FOR ANY PURPOSE, WITHOUT THE EXPRESS WRITTEN PERMISSION OF THE ARCHITECT.

SANITARY RISER DIAGRAM

PROJECT # 19160MONRpo
DATE: Issue Date
DRAWN BY: JAA
CHECKED BY: DC

P701

SCALE PERMIT SET

SPENCER BRISTOL ENGINEERING, INC.
A Gray Company
3577 Parkway Lane, Suite 250
Peachtree Corners, Georgia 30092
TEL: 770.414.1028 FAX: 770.414.6024
SBE Project No. 19036