


Order Plans @ www.LDILine.com

GENERAL NOTES

- BUILDING MFR FURNISHES AND INSTALLS ALL DUCTWORK, AIR DEVICES, AND AIR HANDLER PER SUPPLIED DRAWINGS.
- BUILDING MFR TO FURNISH CONDENSING UNIT, SHIPPED LOOSELY. REFRIGERANT LINES INSTALLED BY BUILDING MFR AND ROUTED FROM AIR HANDLER TO STUB-OUT IN WALL AT LOCATION OF CONDENSING UNIT. GENERAL CONTRACTOR TO MAKE FINAL CONNECTIONS, INSTALL LIQUID LINE FILTER/DRIER, SIGHT GLASS, EXPANSION VALVE, AND CHARGE WITH REFRIGERANT PER MANUFACTURER'S RECOMMENDATIONS.
- OBTAIN PERMIT AND SECURE LOCAL INSPECTIONS AND APPROVALS ON ALL HVAC WORK, DONE AT THE JOB SITE.
- DUCTWORK AND REGISTERS PROVIDED BY BUILDING MFR. GENERAL CONTRACTOR RESPONSIBLE FOR TESTING AND BALANCING THE HVAC SYSTEM. BUILDING MFR SHALL WARRANTY THE AIR HANDLER AND CONDENSING UNIT.
- INSTALL NEW FILTERS ON ALL UNITS NO MORE THAN ONE DAY PRIOR TO STARTING TEST AND BALANCE PHASE.
- BUILDING MFR TO FURNISH CONDENSATE P-TRAP AND CONNECT TO AIR HANDLER. VERIFY SLOPE IS OF ADEQUATE LENGTH TO PREVENT FLOODING FROM REFRIGERANT TRAP SEALS. ALL LINE WITH REFRIGERANT MUST BE DRAIN THROUGH VERIFY FLOW OF CONDENSATE FROM AIR HANDLER TO SIGHT.
- EACH CONTRACTOR IS RESPONSIBLE FOR HAVING THOROUGH KNOWLEDGE OF ALL DRAWINGS AND SPECIFICATIONS AS THEY RELATE TO THIS WORK. NO ADDITIONAL COMPENSATION SHALL BE ALLOWED DUE TO LACK OF THIS KNOWLEDGE.
- ENTIRE HVAC SYSTEM MUST BE FULLY OPERABLE AND APPROVED BY OWNER'S REPRESENTATIVE PRIOR TO OPENING.
- INSTALL ITEMS SHIPPED LOOSE WITH SERVICE BUILDING.

MECHANICAL SYMBOLS

⊙	THERMOSTAT
⊕	SUPPLY REGISTER
⊖	RETURN GRILLE

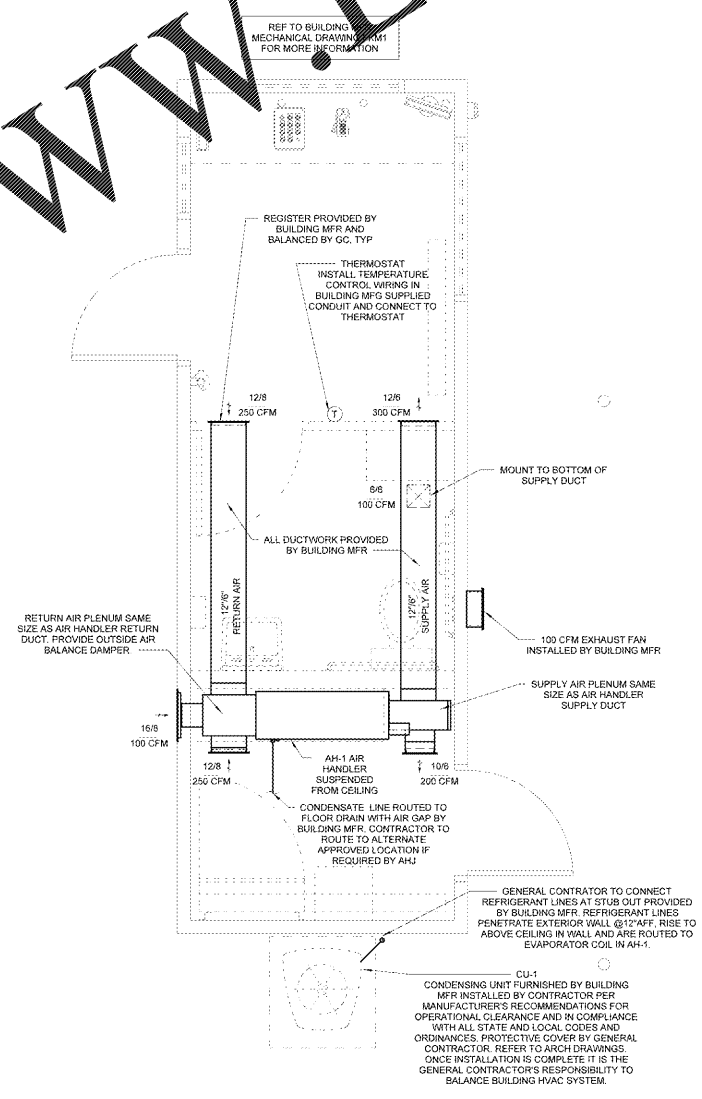

1 HVAC FLOOR PLAN
1/2" = 1'-0"

STIPULATION FOR REUSE
THIS DOCUMENT IS THE PROPERTY OF ANDERSON, SC. IT IS TO BE USED ONLY FOR THE PROJECT AND SITE SPECIFICALLY IDENTIFIED HEREIN. IT IS NOT TO BE REPRODUCED, COPIED, OR TRANSMITTED IN ANY FORM OR BY ANY MEANS, ELECTRONIC OR MECHANICAL, INCLUDING PHOTOCOPYING, RECORDING, OR BY ANY INFORMATION STORAGE AND RETRIEVAL SYSTEM, WITHOUT THE WRITTEN PERMISSION OF ANDERSON, SC.

CONTRACTOR'S
David P. Kimball
MECHANICAL ENGINEER
LICENSE NO. 43144-0001
STATE OF SOUTH CAROLINA
1000 W. BROADWAY, SUITE 200
COLUMBIA, SC 29201
PH: 803.733.1111
WWW.DPKIMBALL.COM

ANDERSON, SC
Sams CLUB
CLUB#: 6463
4348-102
24077 PHOTO
JOB NUMBER: 24077

ISSUE BLOCK

NO.	DESCRIPTION

CHECKED BY: JMS
DRAWN BY: DAD
FILE NAME: FSM1
PROTO CYCLE: 102516
DOCUMENT DATE: 08/08/18

NOT FOR CONSTRUCTION

SERVICE BUILDING MECHANICAL PLAN AND DETAILS

SHEET: FSM1