



**KEYNOTES**


- 16.828 ELECTRICAL SEAL-OFFS NOT SHOWN. PROVIDE SEAL-OFFS FOR ALL CONDUITS. ALL SEAL-OFFS AND JUNCTION BOXES TO BE 1" MINIMUM ABOVE PENETRATIONS. ELECTRICAL CONDUITS SHALL NOT BE ROUTED OVER THE MANWAY COVER. FLEXIBLE CONNECTORS FOR THE ELECTRICAL CONNECTIONS FORM EXPLOSION PROOF JUNCTION BOX TO THE SUBMERGED PUMP WILL NOT BE ACCEPTED. ALL CONNECTIONS MUST BE WITH RIGID CONDUIT.
- 16.844 1" GRC TO SITE MONITORING WIRING CABINET IN SERVICE BUILDING.

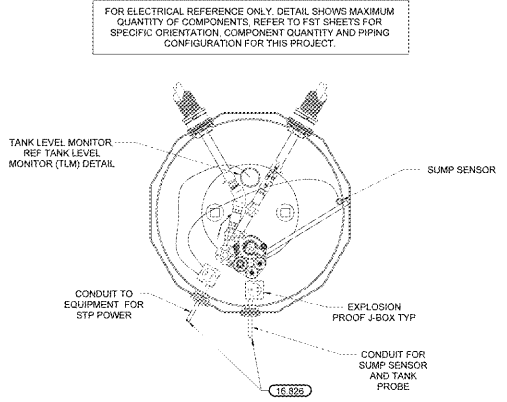


**4 STP SUMP SECTION (TYPICAL)**  
NTS

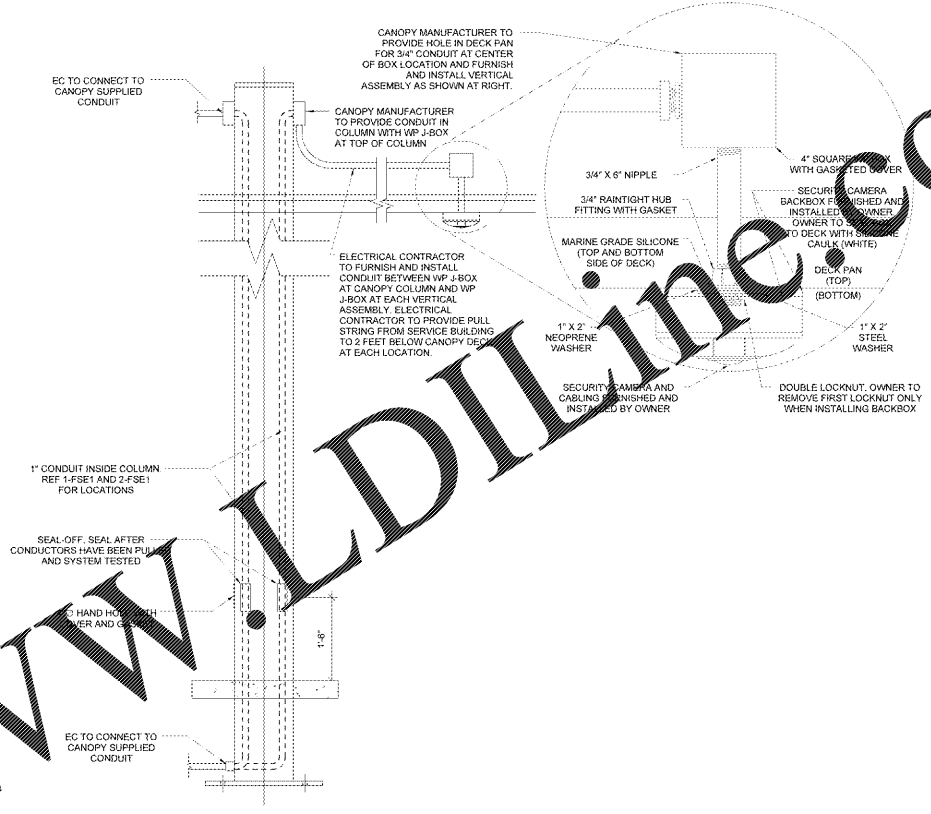

**3 CANOPY COLUMN DETAIL (TYPICAL)**  
NTS

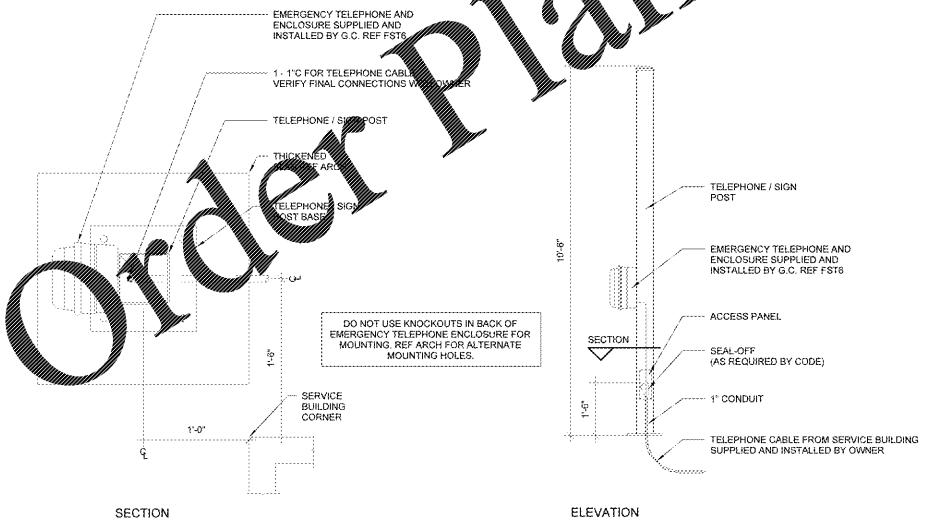

**2 TELEPHONE AND SIGN POST PLAN**  
NTS

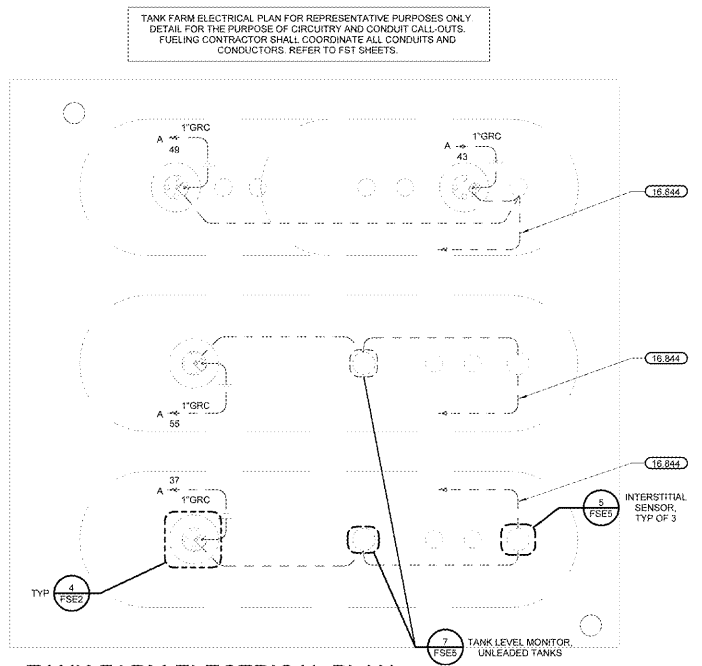

**1 TANK FARM ELECTRICAL PLAN**  
3/32" = 1'-0"

Order Plans @ [www.wldline.com](http://www.wldline.com)

ETIPULATION FOR REUSE:  
THIS DOCUMENT IS THE PROPERTY OF ANDREW J. NICHOLS CONSULTANTS. IT IS TO BE USED ONLY FOR THE PROJECT AND SITE SPECIFICALLY IDENTIFIED HEREIN. IT IS NOT TO BE REPRODUCED, COPIED, OR TRANSMITTED IN ANY FORM OR BY ANY MEANS, ELECTRONIC OR MECHANICAL, INCLUDING PHOTOCOPYING, RECORDING, OR BY ANY INFORMATION STORAGE AND RETRIEVAL SYSTEM, WITHOUT THE WRITTEN PERMISSION OF ANDREW J. NICHOLS CONSULTANTS.

CONSULTANTS  
**Matthew J. Nichols**  
PROJECT MANAGER  
10001 SHILOH DRIVE  
SUITE 100  
GREENSBORO, NC 27409  
PHONE: 336.833.8888  
FAX: 336.833.8889  
WWW.AJNCONSULTANTS.COM

**Anderson, SC**  
**Sam's Club**  
JOB NUMBER: 24077 | PROTO: SWS-102  
**CLUB#: 6463**

ISSUE BLOCK

CHECKED BY: SAG  
DRAWN BY: JLN  
FILE NAME: FSE2  
PROTO CYCLE: 102516  
DOCUMENT DATE: 08/09/19

NOT FOR CONSTRUCTION

TANK ELECTRICAL PLANS AND ELECTRICAL DETAILS

SHEET: FSE2