


1 LOWER MEZZANINE - EAST
3/16" = 1'-0"

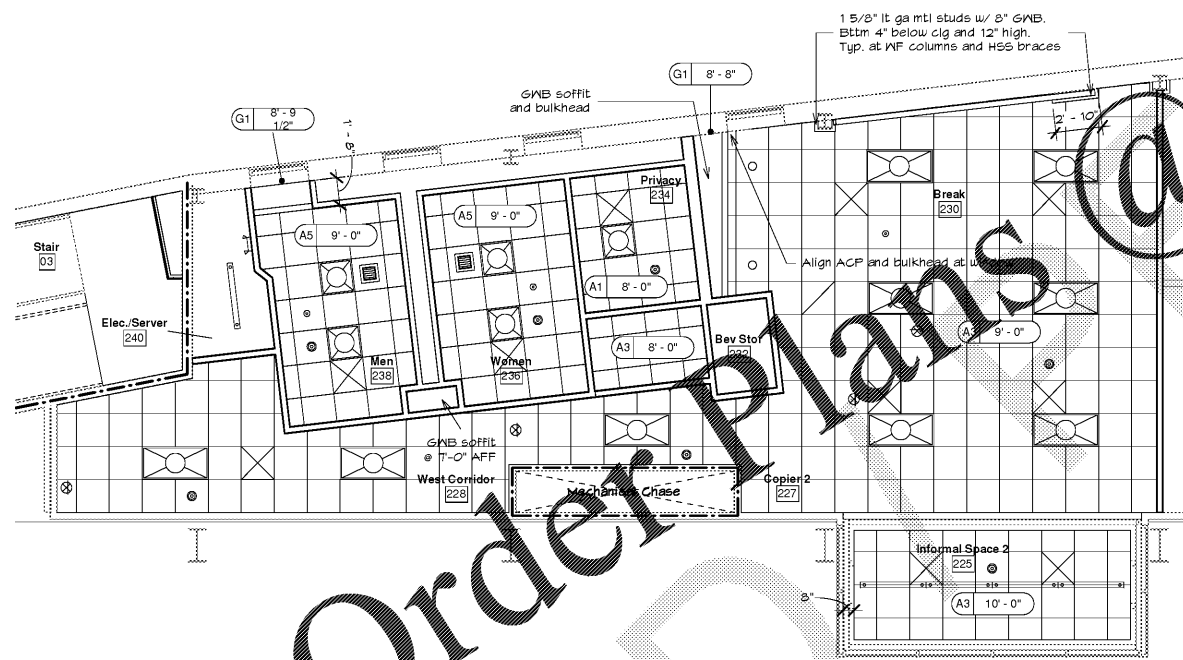

2 LOWER MEZZANINE RCP - WEST
3/16" = 1'-0"

CEILING NOTES:

- SUSPENDED CEILINGS, LIGHT FIXTURES, DUCTS, PIPING, AND OTHER ELEMENTS HUNG FROM ROOF STRUCTURE SHALL NOT BE SUPPORTED BY METAL ROOF DECK.
- ALL CEILING ATTACHED DEVICES INCLUDING, BUT NOT LIMITED TO, LIGHT FIXTURES, SPEAKERS, EXIT SIGNS, SMOKE DETECTORS, FIRE ALARM SENSORS & SPRINKLER HEADS SHALL BE CENTERED IN CEILING TILE. UON. ALL DEVICES SHOWN ARE FOR LOCATION & COORDINATION INFORMATION ONLY. SEE MECHANICAL, ELECTRICAL, & PLUMBING DRAWINGS FOR QUANTITY AND DETAILS.
- USE WIDE FLANGE MOLDING TRIM TO FILL GAP IF CEILING GRID IS SHORT TO WALL BY LESS THAN 1".

CEILING SYMBOLS	
(H)	CEILING MOUNTED HEAT DETECTOR
(F)	CEILING MOUNTED FIRE ALARM SPEAKER/STROBE UNIT
(S)	CEILING MOUNTED SMOKE DETECTOR
(X)	2' SQUARE CEILING MOUNTED SUPPLY DIFFUSER
(R)	2' SQUARE CEILING MOUNTED RETURN GRILL
(S)	1' SQUARE CEILING MOUNTED SUPPLY DIFFUSER
(R)	1' SQUARE CEILING MOUNTED RETURN GRILL
(—)	DIFFUSER SIDE-MOUNTED ON MECHANICAL DUCT
(—)	CEILING MOUNTED SLOT DIFFUSER
(C)	CEILING MOUNTED COMMUNICATION OUTLET
(D)	CEILING MOUNTED DUPLEX RECEPTACLE
(E)	CEILING MOUNTED EXIT SIGN
(L)	4' SUSPENDED LUMINAIRE
(L)	CEILING MOUNTED LUMINAIRE
(L)	2'x4' CEILING MOUNTED LUMINAIRE
(L)	WALL-MOUNTED LUMINAIRE
(C)	CEILING MOUNTED OCCUPANCY SENSOR
(C)	CEILING MOUNTED DAYLIGHTING SENSOR
(S)	CEILING MOUNTED SPEAKER
(C)	CEILING MOUNTED CCTV SECURITY CAMERA
(H)	CEILING HEIGHT
(A1)	CEILING TYPE

CEILING TYPES	
A1	2' x 2' REGULAR CEILING TILE
A2	2' x 6' CEILING TILE
A3	2' x 2' HIGH NRC/LR CEILING TILE
A4	2' x 2' WASHABLE CEILING TILE
A5	2' x 2' MOISTURE RESISTANT CEILING TILE
A6	2' x 2' COLORED CEILING TILE
G1	GYPSUM CEILING
G2	MOISTURE RESISTANT GYPSUM CEILING
X	NO CEILING, EXPOSED TO STRUCTURE

BUY AMERICAN PROGRAM REQUIREMENTS
ALL PRODUCTS PROVIDED ON THIS PROJECT MUST BE MANUFACTURED IN COMPLIANCE WITH THE BUY AMERICAN PROGRAM FOR FEDERALLY FUNDED TRANSPORTATION PROJECTS PER CODE OF FEDERAL REGULATIONS 49 CFR 661. THESE REQUIREMENTS ARE DISTINCT AND DIFFERENT FROM THOSE OF THE BUY AMERICAN ACT OF 1933.

INNOVATIVE DESIGN
850 W. MORGAN STREET
RALEIGH, NORTH CAROLINA 27603
919-832-6303
919-832-3339 FAX

Bid / Permit Documents

SEAL: 11/8/2019

Union Station Mezzanine Office Fit Up
City of Raleigh Transit Division
510 W Martin St, Raleigh, NC 27601

10		
9		
8		
7		
6		
5		
4		
3	Bid / Permit Set	11/8/19
2	CD	10/31/19
1	SD	9/25/19
NO.	SUBMISSION	DATE
CHECKED BY:		MN
DRAWN BY:		LG
PROJECT NUMBER:		1908
SHEET NAME:		
REFLECTED CEILING PLANS		
SHEET NUMBER:		
A111		

Order Plans @ WWW.IDDLINE.COM