

**INNOVATIVE DESIGN**

850 W. MORGAN STREET  
 RALEIGH, NORTH CAROLINA 27603  
 919-832-6303  
 919-832-3339 FAX



150 Fayetteville St., Suite 530, Raleigh, NC 27601  
 1927 South Tryon St., Suite 300, Charlotte, NC 28203  
 Phone: 919-252-2700 - www.optima-engineering.com  
 North Carolina License Number: C-0914

PERMIT/BID SET




SEAL:

Union Station Mezzanine Office Fit Up

City of Raleigh Transit Division

510 W Martin St, Raleigh, NC 27601

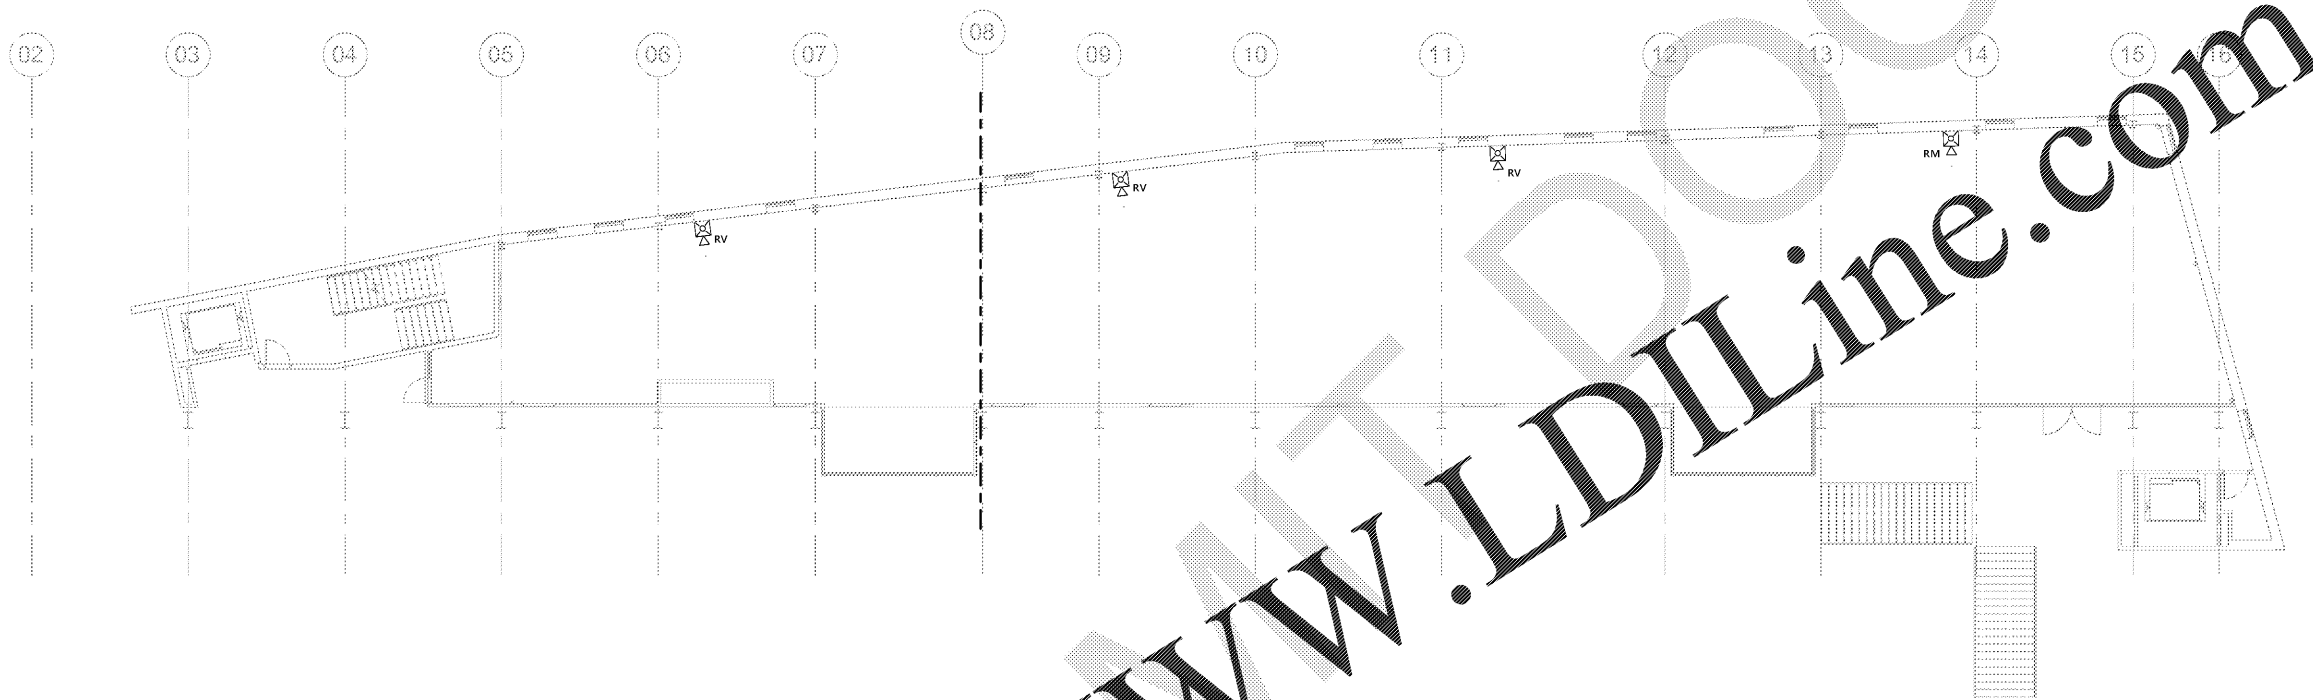

1 OVERALL DEMOLITION FIRE ALARM PLAN  
 3/32" = 1'-0"

ABBREVIATIONS	
ER	EXISTING ITEM RELOCATED TO THIS LOCATION.
RL	EXISTING ITEM TO BE RELOCATED.
RM	EXISTING ITEM TO REMAIN.
RP	EXISTING ITEM TO BE REPLACED.
RV	EXISTING ITEM TO BE REMOVED.

NO.	SUBMISSION	DATE
1	PERMIT/BID SET	11/08/19

CHECKED BY: **MKG**

DRAWN BY: **RDH**

PROJECT NUMBER: **1908**

SHEET NAME:  
 OVERALL DEMOLITION  
 FIRE ALARM FLOOR PLAN

SHEET NUMBER:  
**FA090**



Optima # 19-0327

Order Plans @ [www.plans.com](mailto:www.plans@www.plans.com)

BIDDING DOCUMENTS

www.LDILine.com