

INNOVATIVE
DESIGN

850 W. MORGAN STREET
RALEIGH, NORTH CAROLINA 27603
919-832-6303
919-832-3339 FAX



150 Fayetteville St., Suite 520, Raleigh, NC 27601
1327 South Tryon St., Suite 300, Charlotte, NC 28203
Phone: 919-516-2700 - www.optimaengineering.com
North Carolina License Number: C-0914

PERMIT/BID SET




SEAL:

Union Station Mezzanine Office Fit Up

City of Raleigh Transit Division

510 W Martin St., Raleigh, NC 27601

Order Plans @ www.plans@www.ldilinc.com

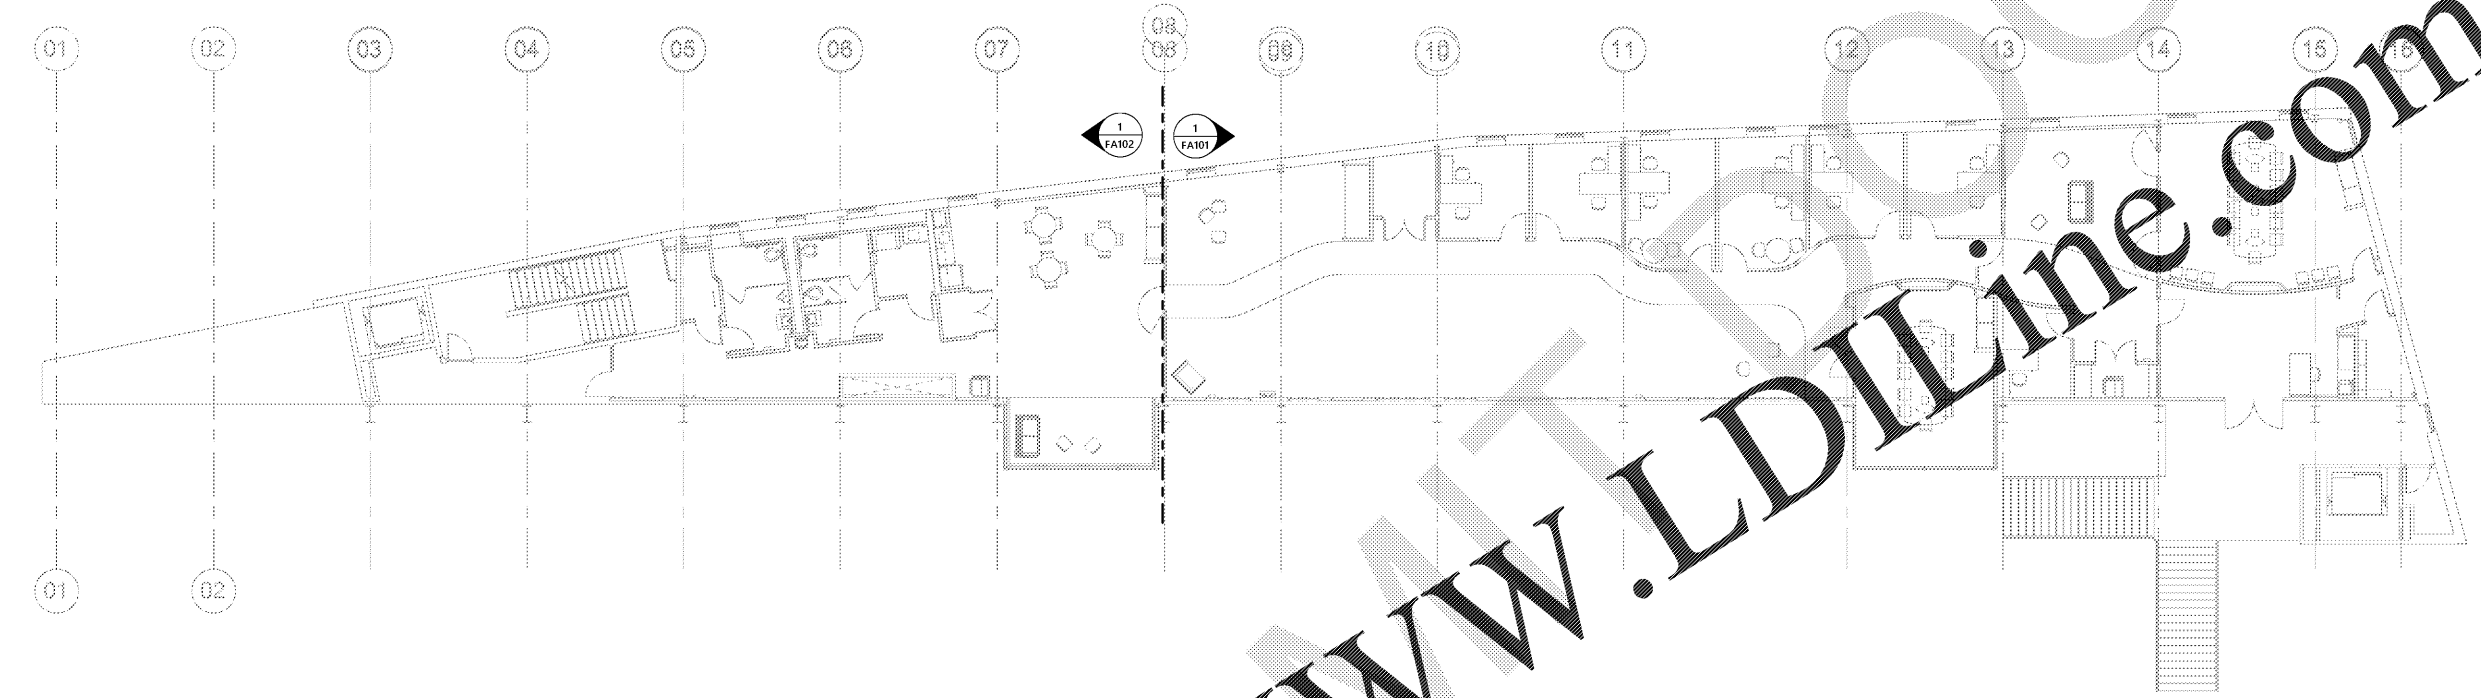

1 OVERALL FIRE ALARM PLAN
3/32" = 1'-0"

NO.	SUBMISSION	DATE
1	PERMIT/BID SET	11/08/19

CHECKED BY: MKG

DRAWN BY: RDH

PROJECT NUMBER: 1908

SHEET NAME:
OVERALL FIRE ALARM
FLOOR PLAN

SHEET NUMBER:
FA100



Optima # 19-0327