


INNOVATIVE DESIGN

850 W. MORGAN STREET
RALEIGH, NORTH CAROLINA 27603
919-832-6303
919-832-3339 FAX



150 Fayetteville St., Suite 530, Raleigh, NC 27601
1027 South Lyon St., Suite 300, Charlotte, NC 28203
Phone: 919-252-2200 www.optima-engineering.com
North Carolina License Number: C-0914

PERMIT/BID SET

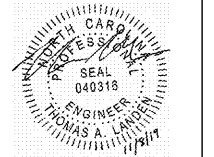


SEAL:

Union Station Mezzanine Office Fit Up

City of Raleigh Transit Division

510 W Martin St, Raleigh, NC 27601

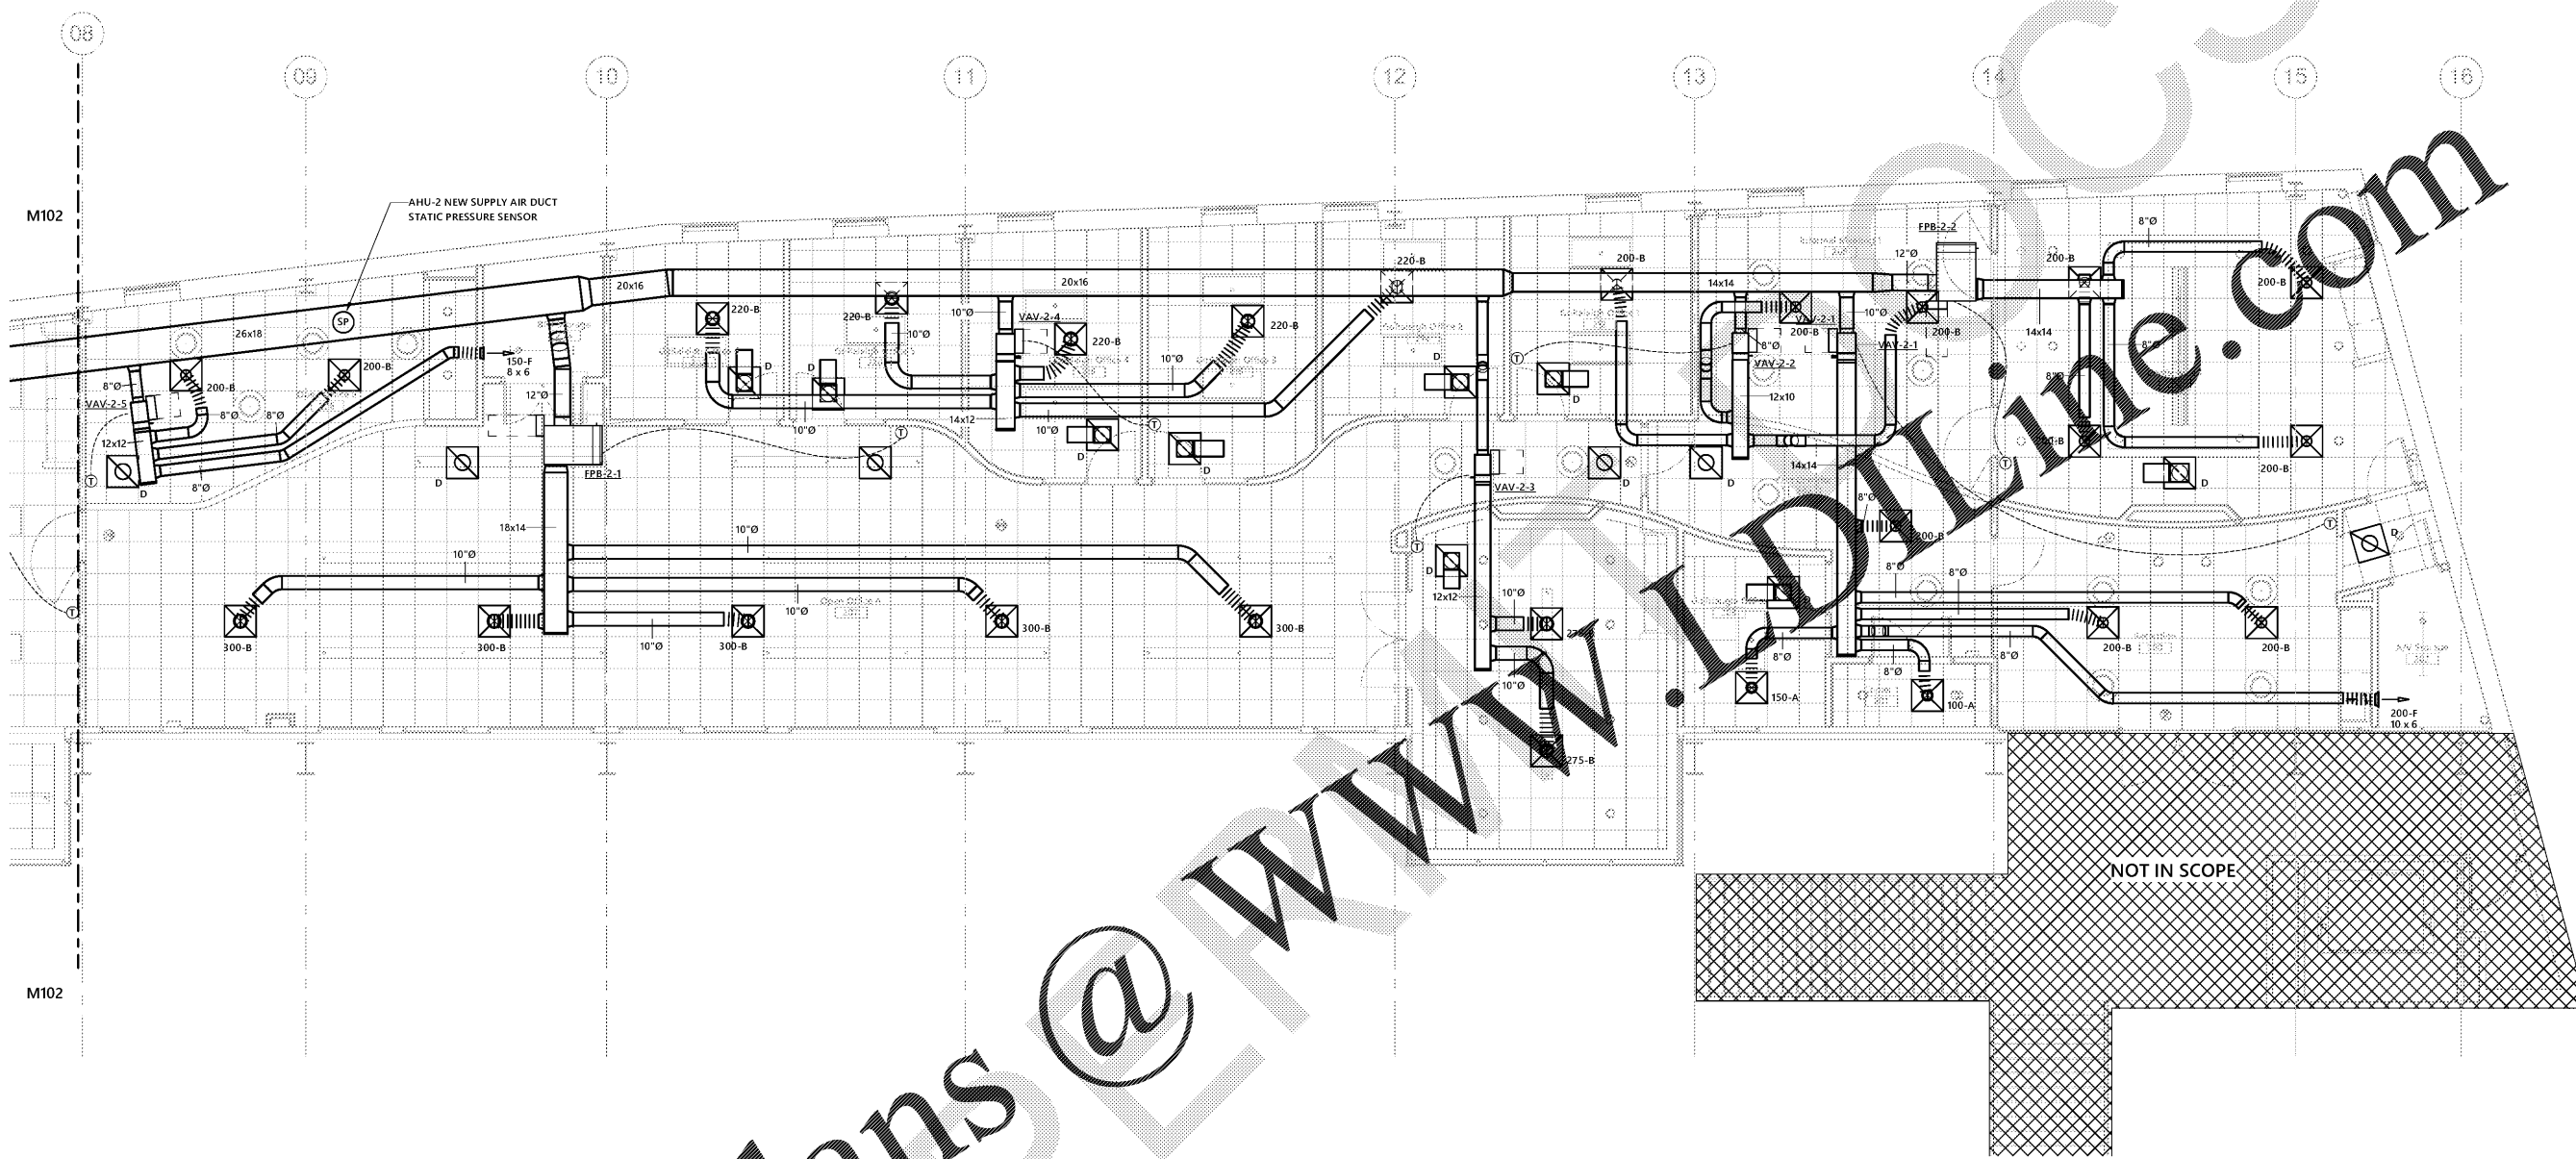

1 FLOOR PLAN - SECOND FLOOR - MECHANICAL DUCT PLAN - EAST
3/16" = 1'-0"

Order Plans @ www.plans@lw.com

BUY AMERICA PROGRAM REQUIREMENTS
ALL PRODUCTS PROVIDED ON THIS PROJECT MUST BE MANUFACTURED IN COMPLIANCE WITH THE BUY AMERICA PROGRAM FOR FEDERALLY FUNDED TRANSPORTATION PROJECTS PER CODE OF FEDERAL REGULATIONS 49 DFR 661. THESE REQUIREMENTS ARE DISTINCT AND DIFFERENT FROM THOSE OF THE BUY AMERICAN ACT OF 1933.



Optima # 19-0327
Scale: 4:01.5

SHEET NUMBER:
M101

1	PERMIT/BID SET	11/08/19
NO.	SUBMISSION	DATE
CHECKED BY:		TAL
DRAWN BY:		ECC
PROJECT NUMBER:		1908
SHEET NAME: ENLARGED MECHANICAL DUCT PLAN - EAST		

COPYRIGHT Innovative Design 2019