



**INNOVATIVE DESIGN**

850 W. MORGAN STREET  
RALEIGH, NORTH CAROLINA 27603  
919-832-6303  
919-832-3339 FAX



150 Fayetteville St., Suite 530, Raleigh, NC 27601  
1927 South Tryon St., Suite 300, Charlotte, NC 28203  
Phone: 919-516-2700 - www.optimaengineering.com  
North Carolina License Number: C-0914

PERMIT/BID SET



SEAL:

Union Station Mezzanine Office Fit Up

City of Raleigh Transit Division

510 W Martin St, Raleigh, NC 27601

1	PERMIT/BID SET	11/08/19
NO.	SUBMISSION	DATE
CHECKED BY: MKG		
DRAWN BY: RDH		
PROJECT NUMBER: 1908		
SHEET NAME: OVERALL DEMOLITION ELECTRICAL PLAN		
SHEET NUMBER: E090		


GENERAL DEMOLITION NOTES	
A	SEE ARCHITECTURAL DRAWINGS AND SPECIFICATIONS FOR PHASES OF DEMOLITION AND CONSTRUCTION. COORDINATE WITH GENERAL CONSTRUCTION.
B	DISCONNECT AND REMOVE ALL ELECTRICAL DEVICES AND LIGHTING FIXTURES IN DEMOLITION AREAS UNLESS NOTED OTHERWISE.
C	DISCONNECT AND REMOVE ALL ELECTRICAL DEVICES IN WALLS TO BE DEMOLISHED. WALLS TO BE DEMOLISHED ARE SHOWN DASHED. DISCONNECT AND REMOVE ASSOCIATED CONDUIT AND WIRE BACK TO LAST REMAINING DEVICE. FURNISH AND INSTALL CONDUIT AND WIRE AS NECESSARY FOR CONTINUITY OF CIRCUIT(S) TO ANY EXISTING DEVICES TO REMAIN. COORDINATE AND VERIFY REQUIREMENTS WITH NEW WORK IN AREA.
D	FURNISH AND INSTALL CONDUIT AND WIRE AS NECESSARY FOR CONTINUITY OF ANY FEEDERS OR BRANCH CIRCUITS ORIGINATING OUTSIDE THE DEMOLITION AREA THAT SERVES ANY ELECTRICAL EQUIPMENT OR DEVICES TO REMAIN AFTER DEMOLITION. MODIFY OR REPLACE AS REQUIRED.
E	DISCONNECT AND REMOVE LIGHT SWITCHES IN DEMOLITION AREAS AS NECESSARY TO ACCOMMODATE NEW DOOR CONFIGURATIONS.
F	DISCONNECT AND REMOVE ANY EXISTING ELECTRICAL DEVICES AND BACK BOXES AS NECESSARY WHERE NEW WALL CONSTRUCTION WILL INTERSECT AN EXISTING WALL. FURNISH AND INSTALL CONDUIT AND WIRE AS REQUIRED FOR CONTINUITY OF CIRCUIT(S).
F	FURNISH AND INSTALL BLANK COVER PLATES OVER ALL EXISTING UNUSED OPENINGS.
G	FURNISH AND INSTALL CONDUIT AND/OR COMMUNICATIONS/DATA WIRING AS NECESSARY FOR CONTINUITY OF ANY WIRING ORIGINATING OUTSIDE THE DEMOLITION AREA THAT SERVES ANY COMMUNICATIONS/DATA EQUIPMENT OR DEVICES TO REMAIN AFTER DEMOLITION. MODIFY OR REPLACE AS REQUIRED.

ABBREVIATIONS	
ER	EXISTING ITEM RELOCATED TO THIS LOCATION.
RL	EXISTING ITEM TO BE RELOCATED.
RM	EXISTING ITEM TO REMAIN.
RP	EXISTING ITEM TO BE REPLACED.
RV	EXISTING ITEM TO BE REMOVED.



Optima # 19-0327

**1** OVERALL DEMOLITION ELECTRICAL PLAN  
3/32" = 1'-0"

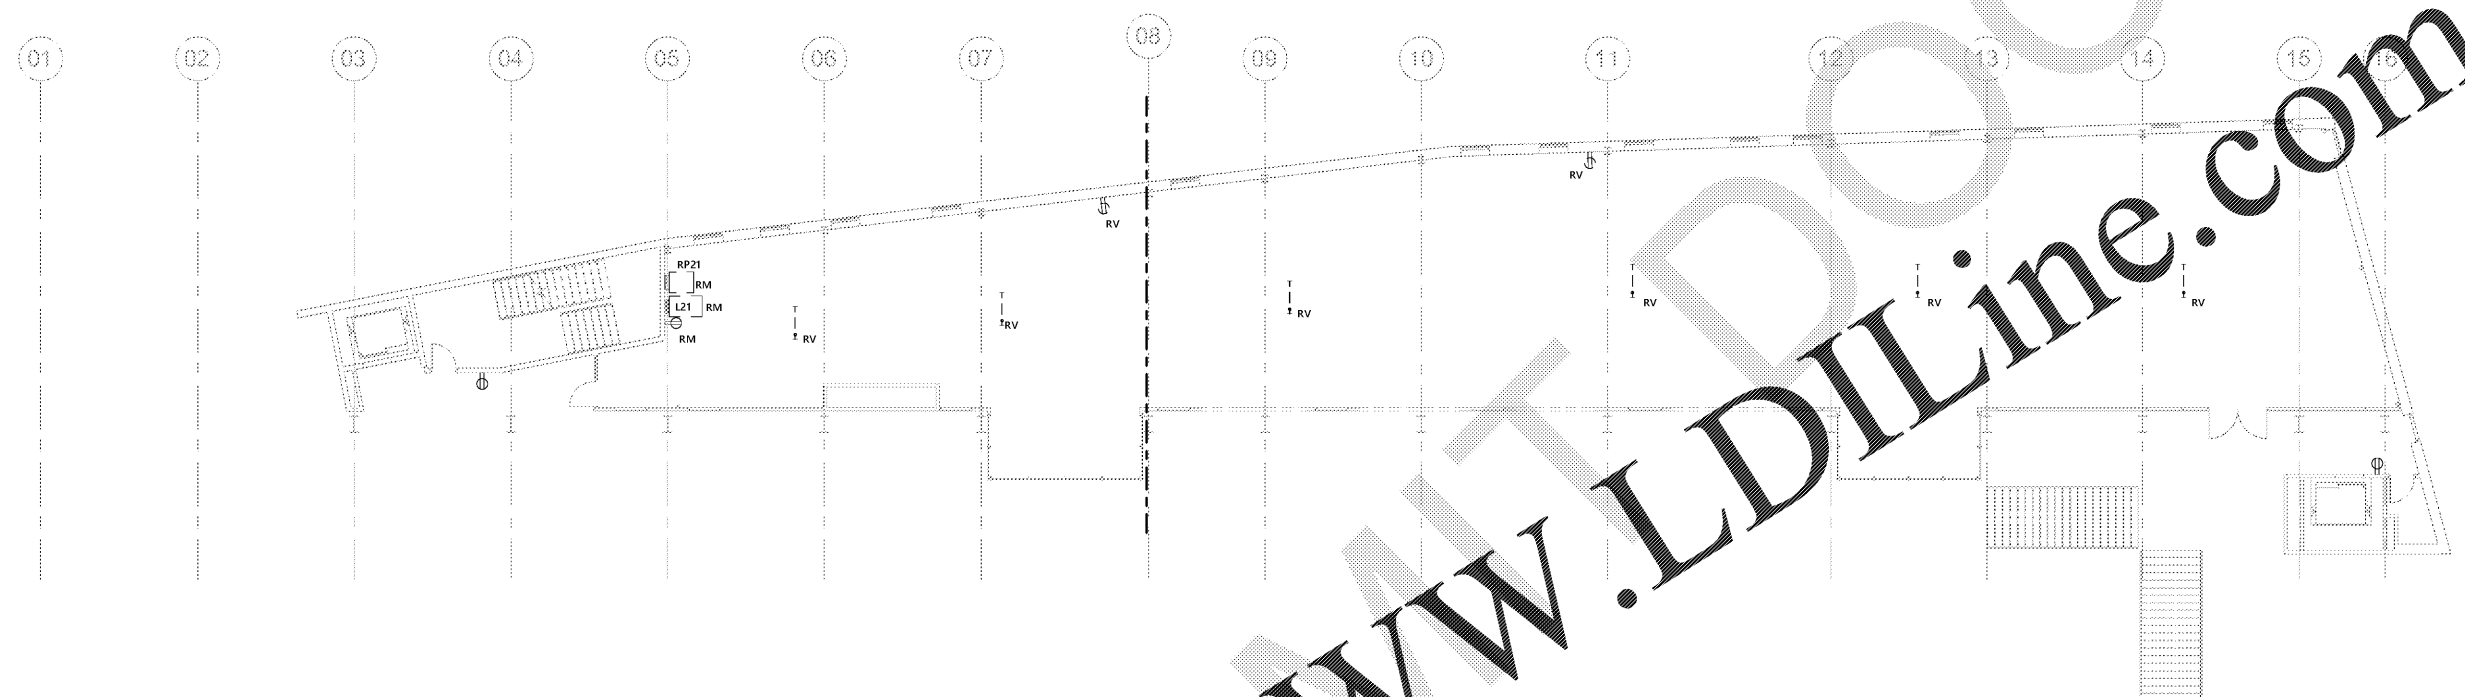

Order Plans @ [www.LDILine.com](mailto:www.LDILine.com)