


PROJECT INFORMATION

**UNCG ATHLETICS
 COLEMAN BUILDING
 WEIGHT ROOM**
 SCO ID No. 19-20597-01A | Code: 41825 Item: 304
 1408 Walker Ave., Greensboro, NC 27402

SEALS

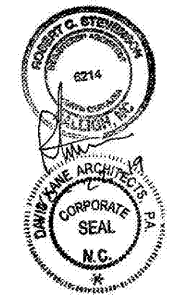

DKA JOB NUMBER

1915

REVISIONS

NO.	DATE	DESCRIPTION

These drawings are the property of Davis Kone Architects, P.A. They may not be re-used for any purpose without written permission. Copyright © 2019 by Davis Kone Architects, P.A. All rights reserved.

PA: RS
 PM: SB
 Drawn By: MS
 Plot Date: 10/23/2019 3:58:22 PM


DATE ISSUED

BID DOCUMENTS
 10/22/19

SHEET TITLE

LIFE SAFETY PLAN
 FIRST FLOOR

T-2.1

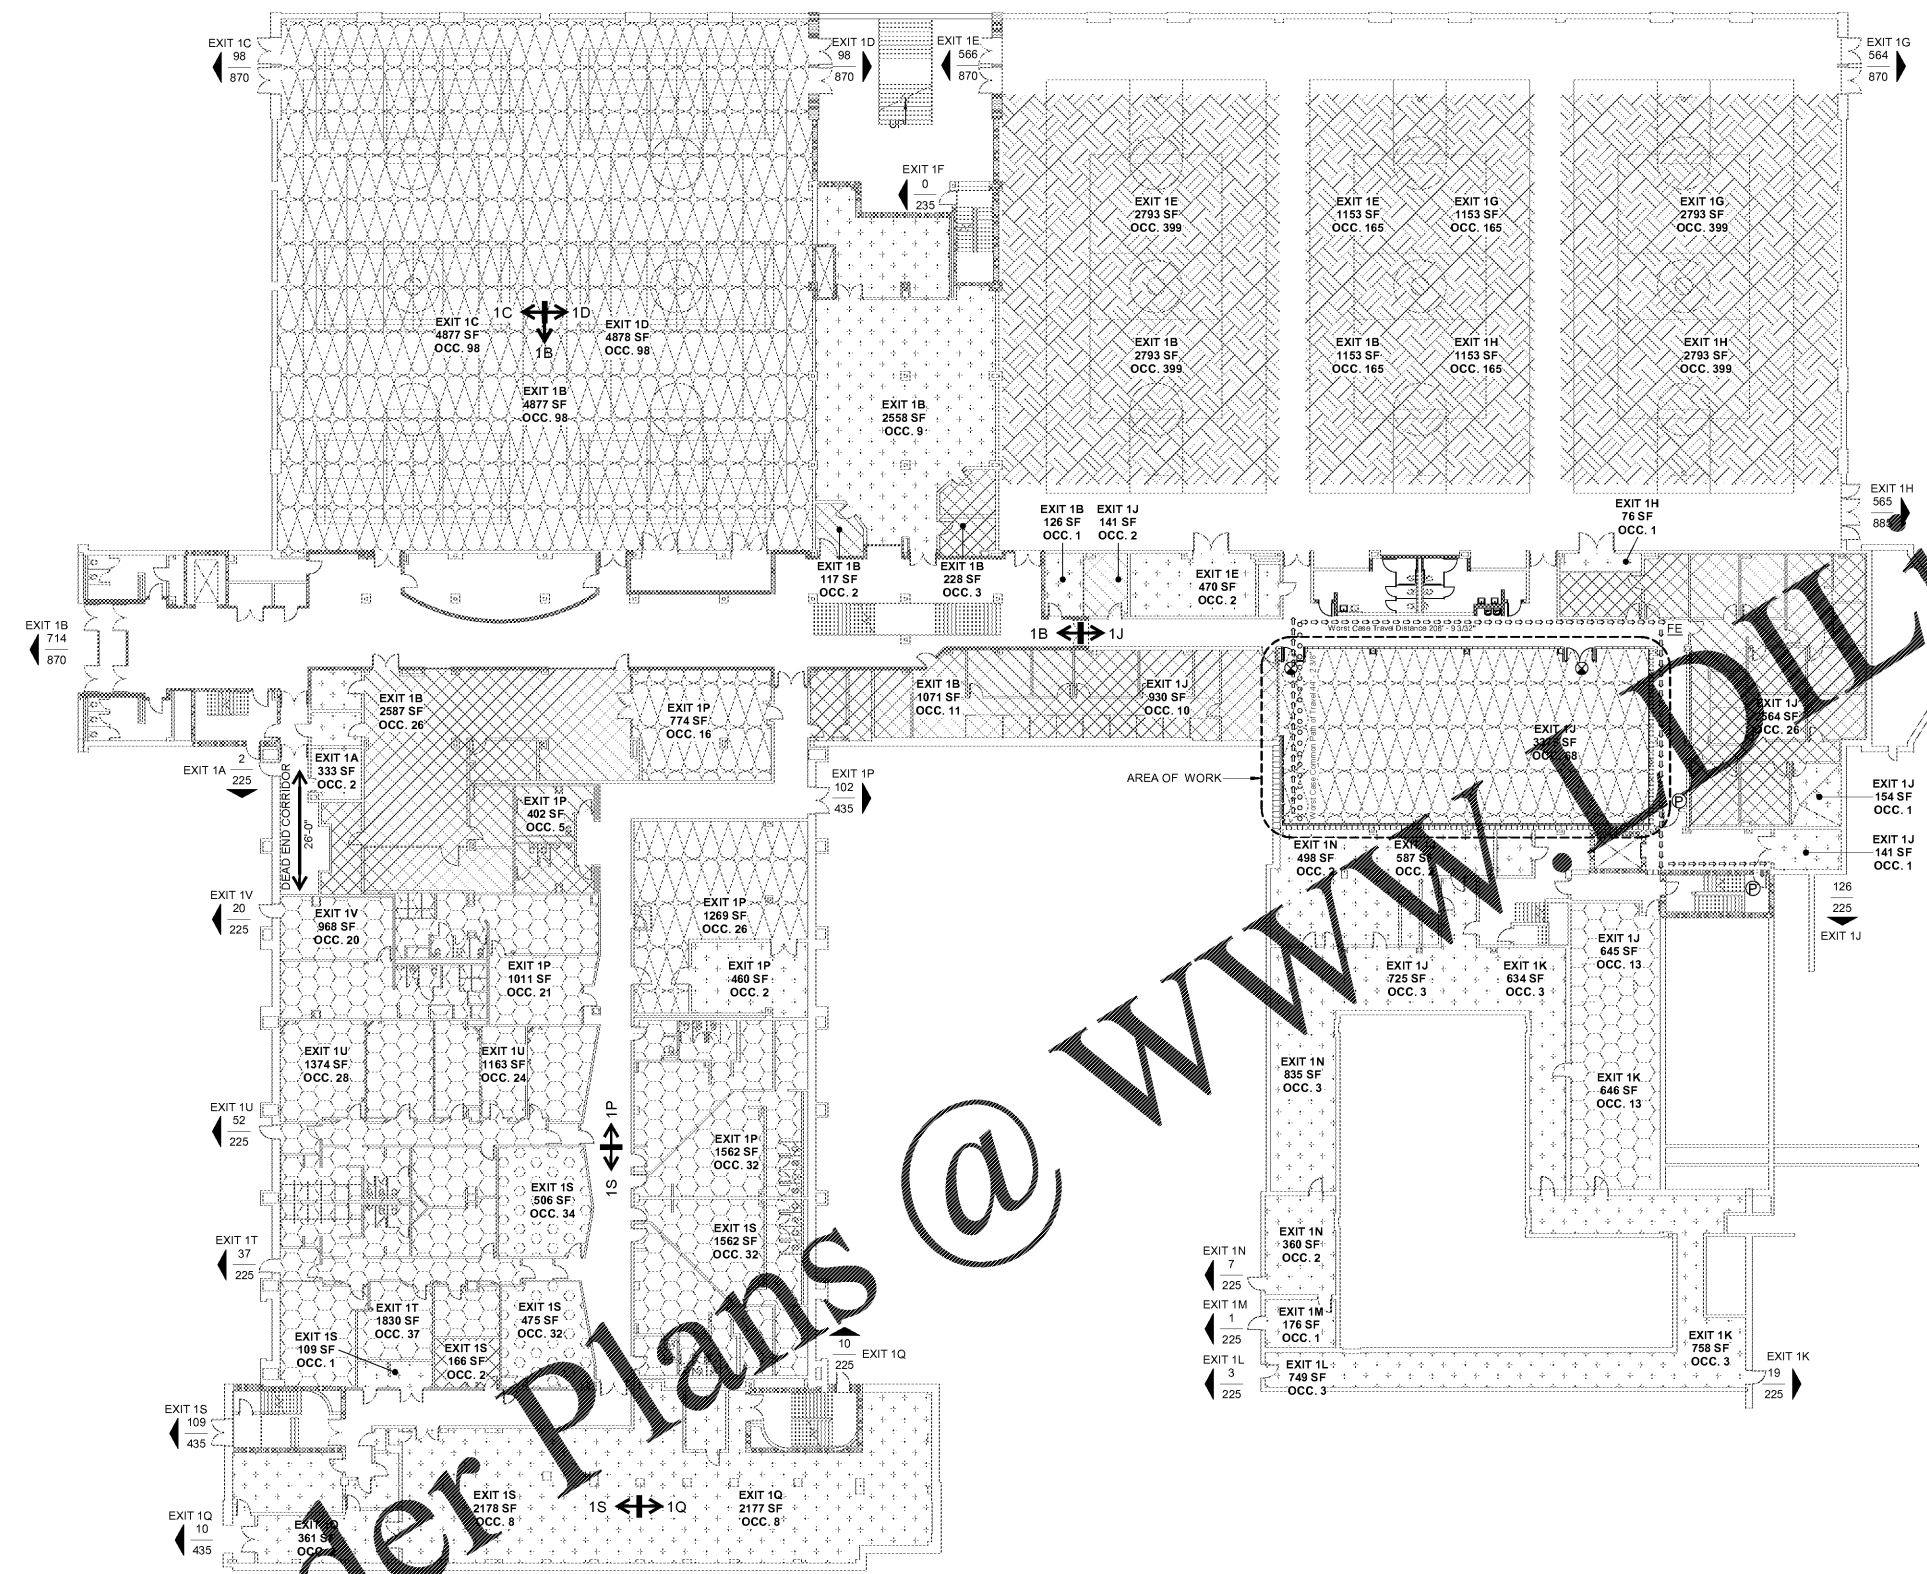


B1 1ST FLOOR LIFE SAFETY PLAN
 1" = 20'-0"


LIFE SAFETY GENERAL NOTES:

- REFER TO SHEET T-1.2 FOR CODE SUMMARY.
- REFER TO DOOR SCHEDULE FOR REQUIRED DOOR RATINGS.
- REFER TO SITE PLAN FOR BUILDING ADJACENCIES AND PROPERTY LINES.
- REFER TO FLOOR PLANS FOR FIRE EXTINGUISHER LOCATIONS.

LIFE SAFETY SYMBOL LEGEND

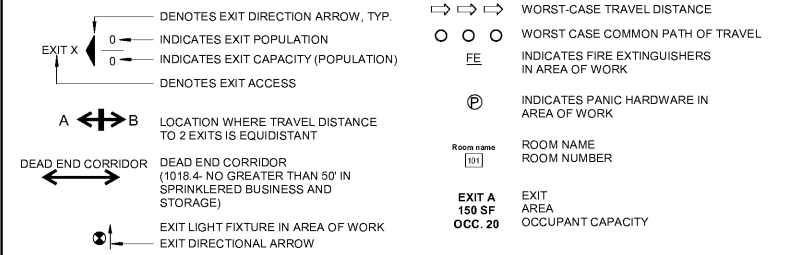

LIFE SAFETY OCCUPANCY KEY

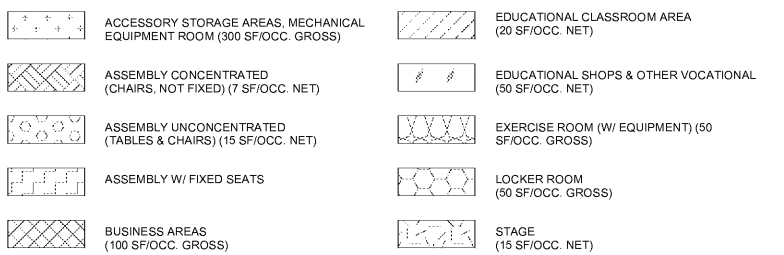

RATED ASSEMBLIES LEGEND:

