


PROJECT INFORMATION

**UNCG ATHLETICS
COLEMAN BUILDING
WEIGHT ROOM**
SCO ID No. 19-20597-01A | Code: 41825 Item: 304
1408 Walker Ave., Greensboro, NC 27402

SEALS

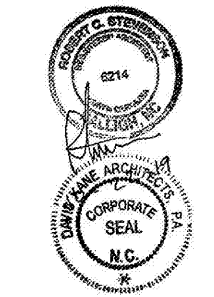

DKA JOB NUMBER

1915

REVISIONS

NO.	DESCRIPTION

These drawings are the property of Davis Kone Architects, P.A. They may not be re-used for any purpose without written permission. Copyright © 2019 by Davis Kone Architects, P.A. All rights reserved.

PA: RS
PM: SB
Drawn By: JW
Plot Date: 10/23/2019 4:39:07 PM

DATE ISSUED

BID DOCUMENTS
10/22/19

SHEET TITLE


FIRST FLOOR
ALTERNATE RCP

A-8.3

REFLECTED CEILING PLAN GENERAL NOTES:

1. CEILING GRIDS TO BE CENTERED IN ROOM AS SHOWN, UNLESS DIMENSIONED OTHERWISE.
2. DOUBLE CEILING TRACK AT THE EDGE OF ANY LAY-IN AREAS IS NOT ACCEPTABLE. PROVIDE A 2x4 TILE CUT TO FIT THE LARGER OPENING WHERE A STRIP OF TILE LESS THAN 2 1/2" IN EITHER DIRECTION WOULD HAVE TO BE USED, TYP.
3. MECHANICAL, ELECTRICAL, FIRE PROTECTION, AND AV COMPONENTS ARE SHOWN FOR COORDINATION PURPOSES ONLY. SEE PLUMBING, ELECTRICAL, MECHANICAL, AND FIRE PROTECTION DRAWINGS FOR ADDITIONAL REQUIREMENTS.
4. CONTRACTOR IS RESPONSIBLE FOR COORDINATING INSTALLATION OF MECHANICAL, FIRE PROTECTION, ELECTRICAL, AND PLUMBING WORK ABOVE CEILING, IN ORDER TO PROVIDE FINISHED CEILINGS AT HEIGHTS REQUIRED ON CEILING PLAN.
5. PRIME AND PAINT ALL NON-GALVANIZED STEEL LINTELS THAT ARE TO REMAIN EXPOSED.
6. SEE INTERIOR FINISHES SCHEDULE AND INTERIOR FINISHES SECTION I-SHEETS FOR ADDITIONAL CEILING INFORMATION AND REQUIREMENTS.
7. PROVIDE CONTROL JOINTS IN GYPSUM BOARD CEILING CONSTRUCTION AS INDICATED. WHERE NOT SHOWN, PROVIDE MAXIMUM SPACING BETWEEN JOINTS OF 10'-0". VERIFY FINAL CONTROL JOINT LOCATIONS WITH ARCHITECT PRIOR TO STARTING WORK WHETHER OR NOT INDICATED ON THE DRAWING.
8. ALL GWB CONTROL JOINTS ARE TO REMAIN HORIZONTALLY AS SHOWN ON REFLECTED CEILING PLANS AND VERTICALLY AT THE FACE OF THE BULKHEAD WALL.
9. CENTER PENETRATIONS OF ACOUSTICAL CEILING SYSTEMS WITHIN INDIVIDUAL CEILING PANELS, SUCH AS SPRINKLER HEADS, DIFFUSERS, LIGHT FIXTURES, ETC. UON.
10. PAINT ALL EXPOSED GWB CEILING AND BULKHEADS PT-2.
11. SUBMIT COORDINATION DRAWINGS AND LAYOUT FOR APPROVAL IN ALL AREAS WITH EXPOSED STRUCTURE PRIOR TO INSTALLATION.

ALTERNATE SPRINKLER DESIGN BY PERFORMANCE SPECIFICATION. SPRINKLER HEADS SHOWN FOR AREAS WITH AESTHETIC OR ADDITIONAL REQUIREMENTS COORDINATION. CONTRACTOR RESPONSIBLE FOR FULL RCP COORDINATION.

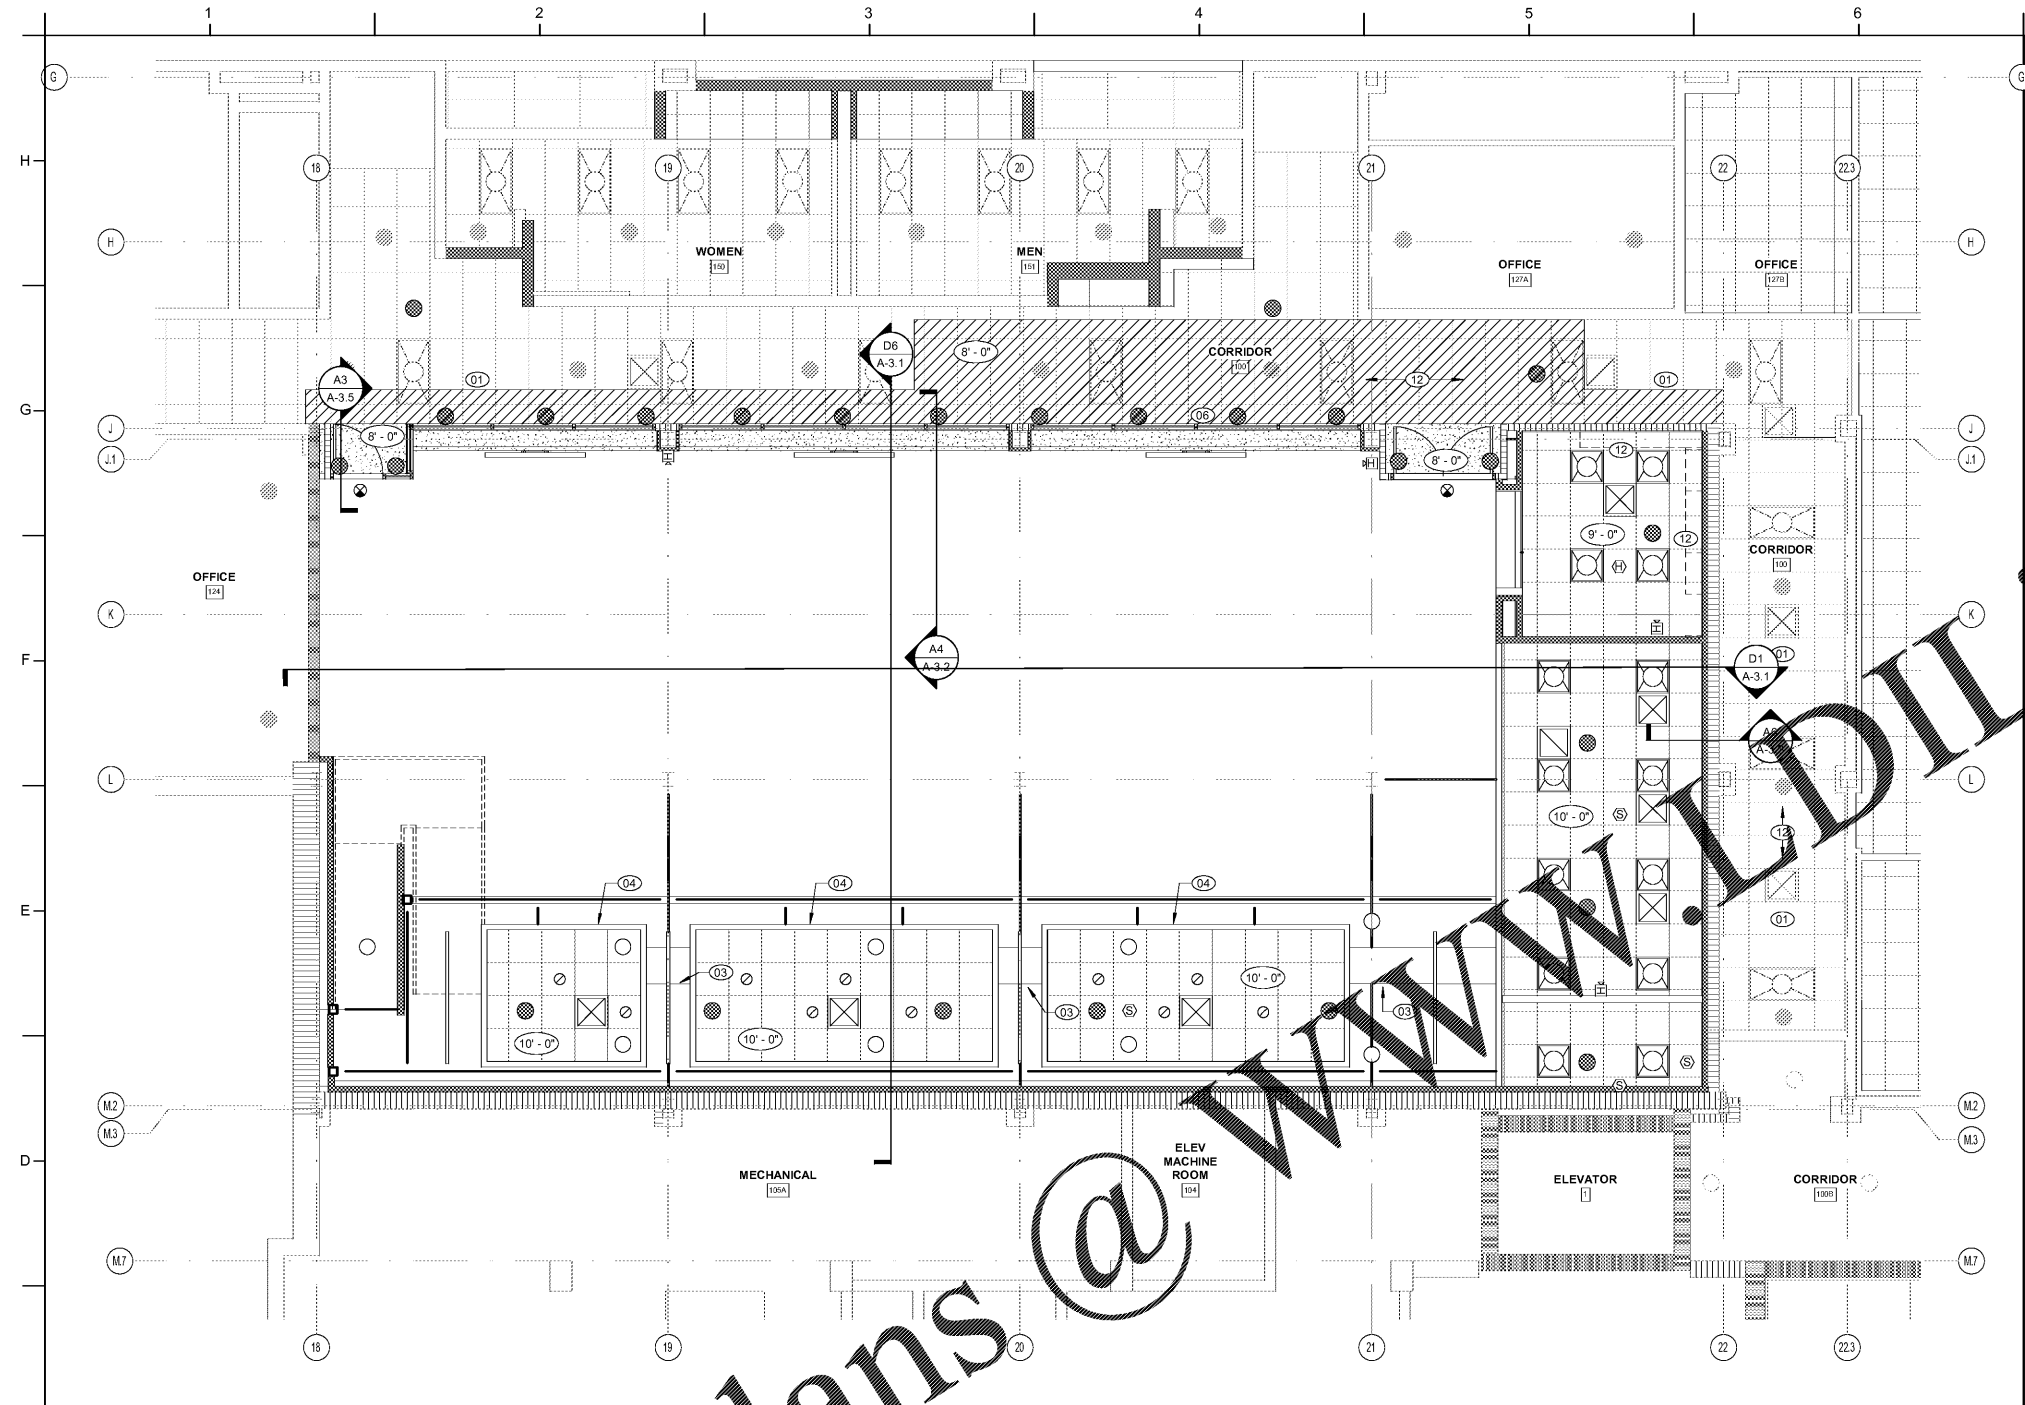

C1 1ST FLOOR ALTERNATE REFLECTED CEILING PLAN

REFLECTED CEILING PLAN KEY NOTES:

- NOTE: NOT ALL KEY NOTES BELOW ARE APPLICABLE TO THIS SHEET. KEY NOTES SUPPLEMENT INFORMATION FOUND ELSEWHERE IN THE DRAWINGS. SEE SHEET A-0.0 FOR FLOOR PLAN GENERAL NOTES, PARTITION GENERAL NOTES, LEGENDS, AND ADDITIONAL REQUIREMENTS. SEE A-8.1 THROUGH A-8.4 AND I-8.1 THROUGH I-8.2 FOR ALTERNATE PLANS.
- 01 EXISTING ACT CEILING TO REMAIN.
 - 02 LINEAR LIGHT FIXTURE. SEE ELECTRICAL DRAWINGS FOR ADDITIONAL REQUIREMENTS.
 - 03 MECHANICAL DUCT. SEE MECHANICAL DRAWINGS FOR ADDITIONAL REQUIREMENTS.
 - 04 NEW SUSPENDED GYB BOARD CEILING. SEE MECHANICAL DRAWINGS FOR ADDITIONAL REQUIREMENTS.
 - 05 CEILING FABRIC, PROVIDED AS SHOWN. SEE DETAIL E1/A-3.5 FOR ADDITIONAL REQUIREMENTS FOR FABRIC CEILING FAN INSTALLATION.
 - 06 PATCH CEILING GRID AND REINSTALL SALVAGED ACT. REPLACED ACT. CEILING TILES WITH MATCHING ACT.
 - 07 PROVIDE INTUMESCENT FIREPROOFING PER UL DETAIL N640 AT 2ND LEVEL BEAMS, TYPICAL.
 - 08 PATCH CMU WALL PER DETAILS ON A-3.4 AT NEW DUCT PENETRATION LOCATION. SEE MECHANICAL DRAWINGS FOR ADDITIONAL REQUIREMENTS.
 - 09 PATCH CMU WALL PER DETAILS ON A-3.4
 - 10 PATCH TOP OF CMU WALL PER DETAIL A7/A-3.2
 - 11 GWB BULKHEAD AROUND EXISTING BEAM PER DETAIL G7/A-3.5
 - 12 UNDER CABINET LIGHTING. SEE XX FOR ADDITIONAL REQUIREMENTS

REFLECTED CEILING PLAN SYMBOL LEGEND

CEILING TAG SPOT ELEVATION GYB BOARD CEILING ACOUSTIC CEILING TILE 2'x2' UNDER CABINET LIGHTING 	RECESSED / SUSPENDED LIGHT FIXTURE LINEAR PENDANT 2x2' CAN LIGHT MECHANICAL AIR SUPPLY DIFFUSER MECHANICAL EXHAUST REGISTER MECHANICAL RETURN REGISTER EXIT LIGHT FIXTURE EXIT DIRECTIONAL ARROW CEILING MOUNTED ELECTRICAL OUTLET CONTROL JOINT 	CEILING MOUNTED SMOKE DETECTOR CEILING MOUNTED HEAT DETECTOR WALL MOUNTED FIRE ALARM AUDIO/VISUAL DEVICE NEW CONCEALED PENDANT SPRINKLER HEAD NEW UPRIGHT SPRINKLER HEAD EXISTING CONCEALED PENDANT SPRINKLER EXISTING UPRIGHT SPRINKLER HEAD WALL MOUNTED FIRE ALARM VISUAL DEVICE
--------------------------------------------------------------------------------------------------------------------------------------------------------------------	----------------------------------------------------------------------------------------------------------------------------------------------------------------------------------------------------------------------------------------------------------------------------------------------------------------------------------------------------------------	--------------------------------------------------------------------------------------------------------------------------------------------------------------------------------------------------------------------------------------------------------------------------------------------------------------------------------------------------------------------------------------------------

RATED ASSEMBLIES LEGEND:

- NOTES: RATINGS ARE NOT SHOWN THROUGH DOORS FOR CLARITY. SEE A-0.0 FOR PARTITION TYPES. SEE LIFE SAFETY PLANS ON T-2.1 - T-2.3 FOR FULL EXTENT OF RATINGS, INCLUDING HORIZONTAL RATINGS. RATINGS ARE CONTINUOUS AROUND OPENINGS AND OPENINGS ARE TO BE PROTECTED IN ACCORDANCE WITH THE NC STATE BUILDING CODE. PROTECT ALL PENETRATIONS.
- SEE T-SHEETS FOR UL ASSEMBLIES AND ADDITIONAL INFORMATION.
- EXISTING 1-HR RATED FIRE BARRIER
 - EXISTING 2-HR RATED FIRE BARRIER
 - EXISTING SMOKE RESISTANT WALL
 - NEW SMOKE RESISTANT WALL

KEY PLAN

FIRST FLOOR = NTS

