


Order Plans @

WWW.LDILine.com

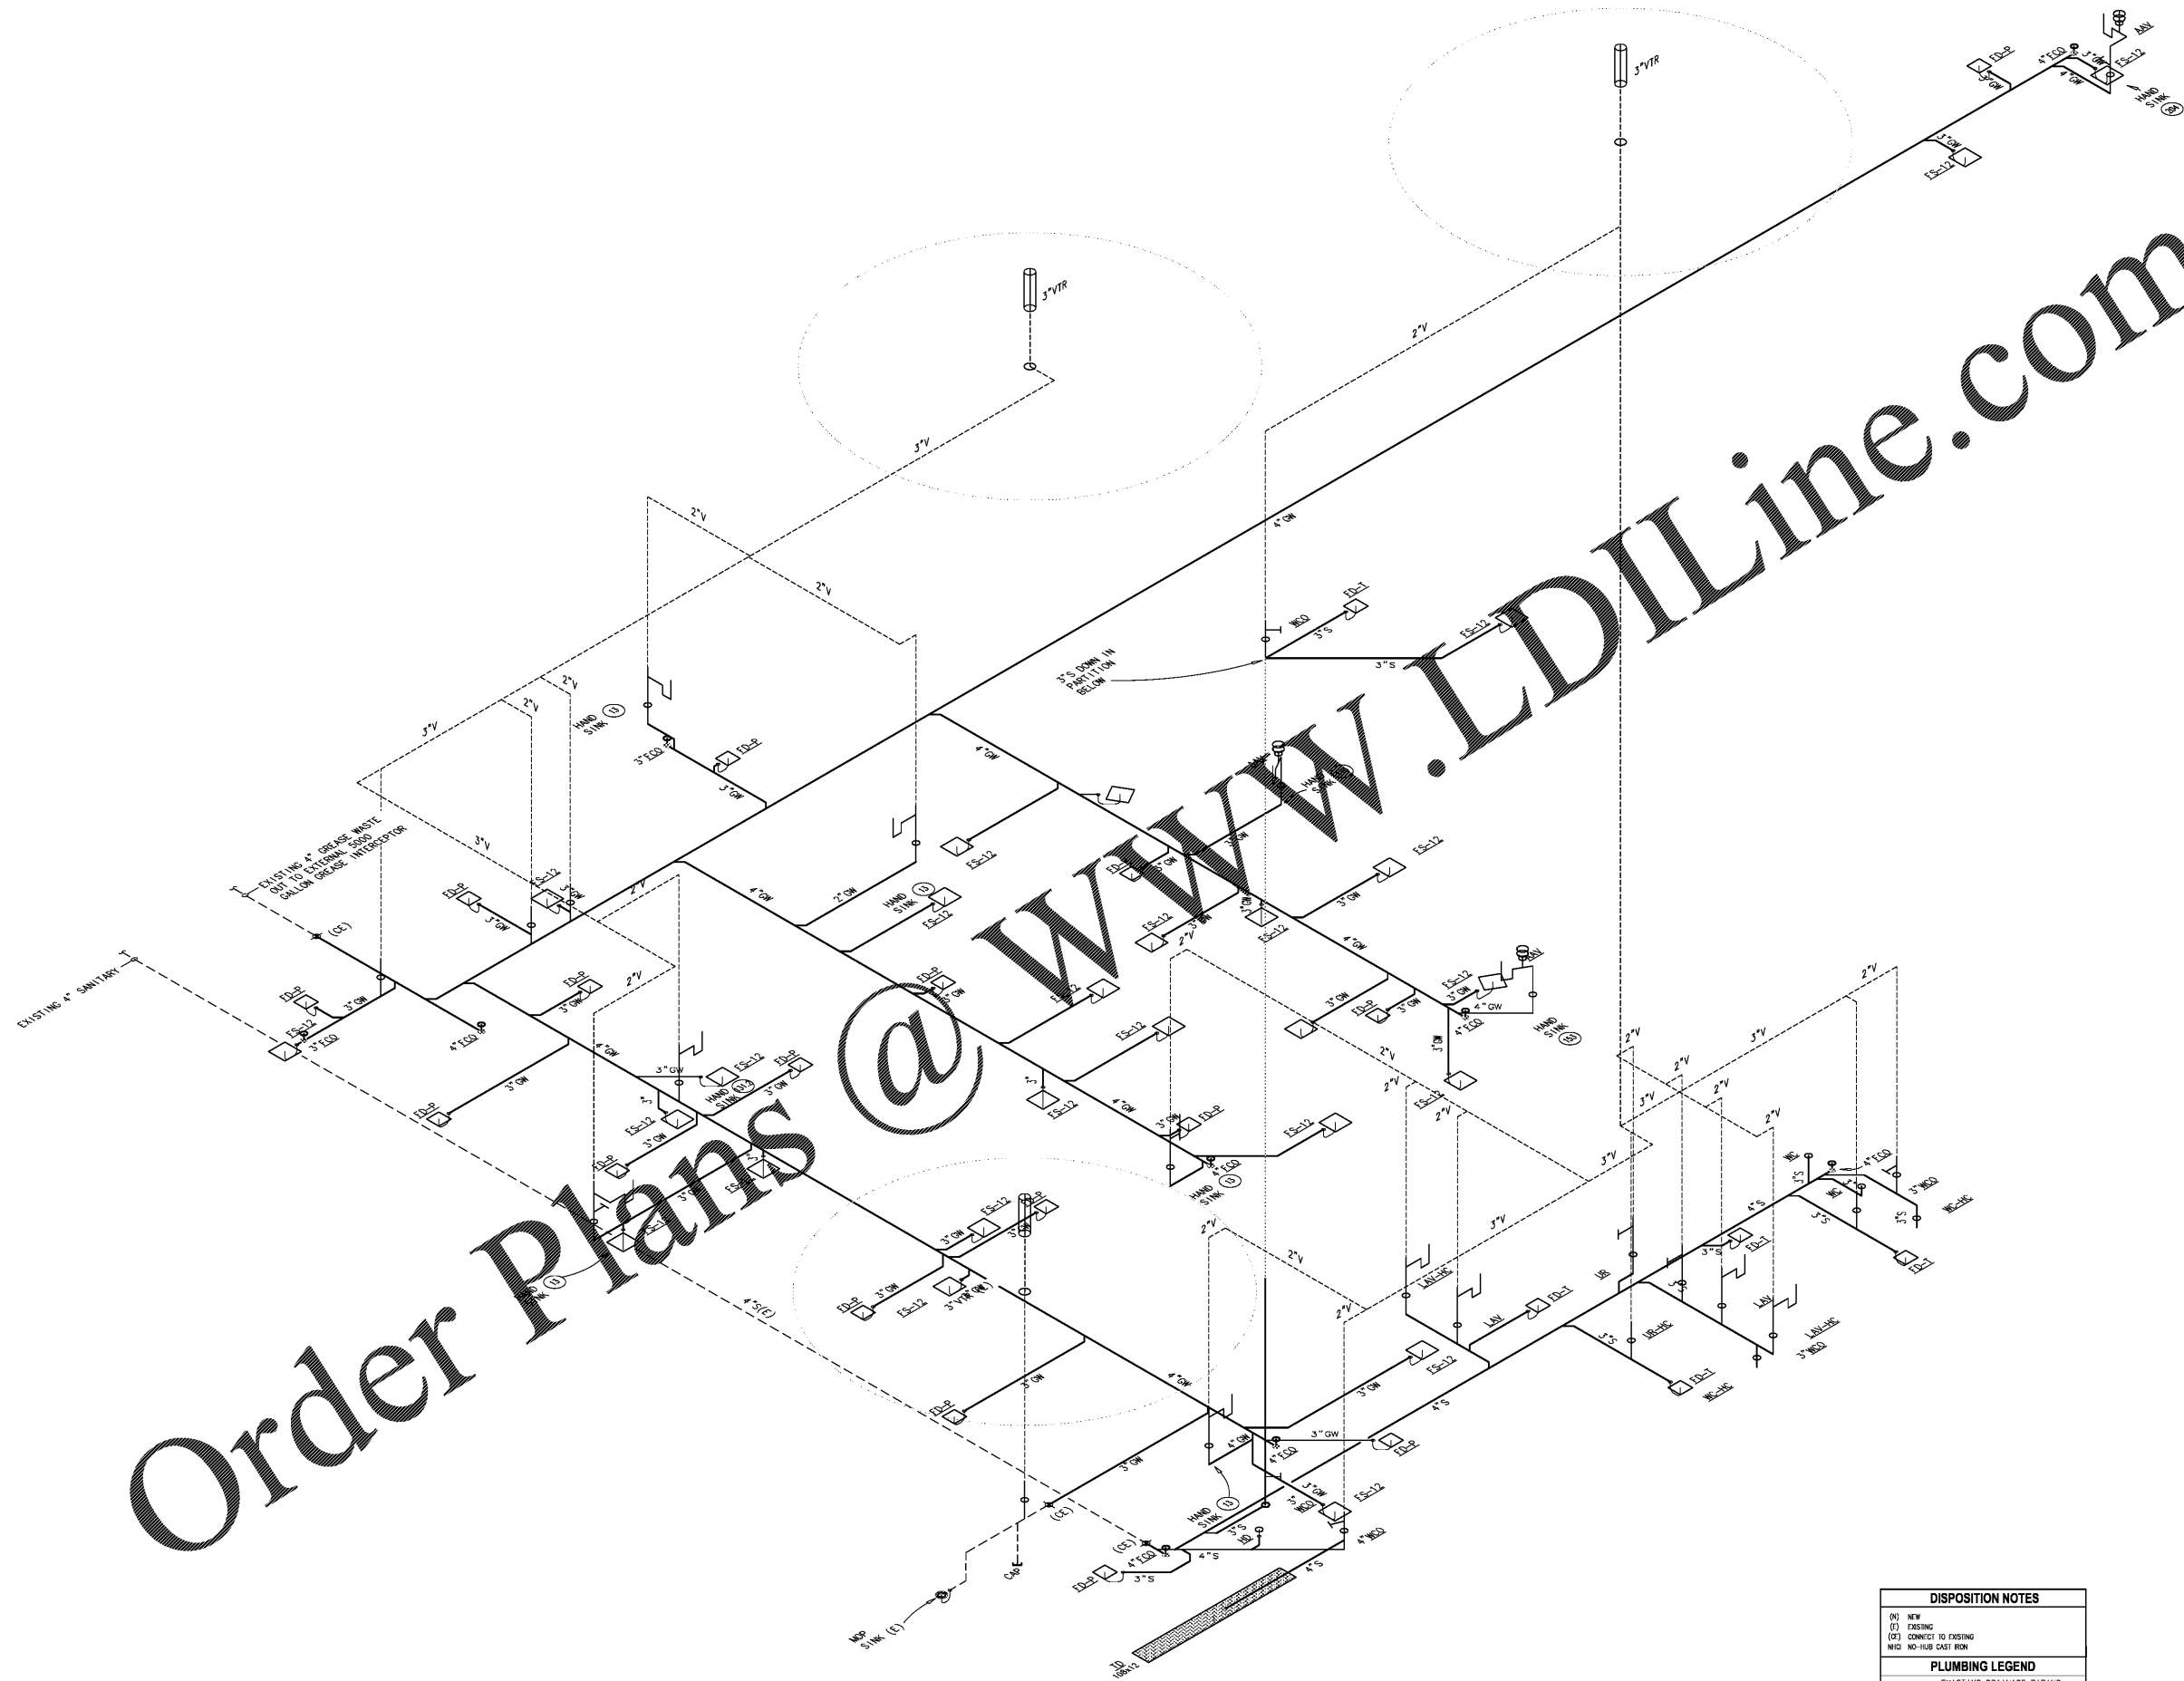

WASTE AND VENT ISOMETRIC
SCALE: N.T.S.

DISPOSITION NOTES	
(N)	NEW
(E)	EXISTING
(C)	CONNECT TO EXISTING
(N/C)	NO-HUB CAST IRON

PLUMBING LEGEND	
---	EXISTING DRAINAGE PIPING
---	NEW DRAINAGE PIPING
---	VENT
---	CONNECT NEW TO EXISTING
IW	INDIRECT WASTE (FULL SIZE)
(F)	FOOD SERVICE PLUMBING TAG

PROJECT COORDINATOR
CIVITARESE MORGAN
 821 N. RIVERFRONT BLVD. SUITE 700
 DALLAS, TEXAS 75207
 TEL: 214-613-0880 FAX: 469-730-3341

ARCHITECT
T.M. Morgan Architect
 821 N. RIVERFRONT BLVD.
 SUITE 700
 DALLAS, TEXAS 75207

REG. PROFESSIONAL
 GEORGIA
 GREGOR GRAMLICH, PE
 13181 STARBUCK ROAD, SUITE 17
 LARGO, FLORIDA 33773
 (727) 538-9464

THIS DOCUMENT HAS BEEN DIGITALLY SIGNED AND SEALED BY GREGOR GRAMLICH, PE ON 12-13-2019 USING A DIGITAL SIGNATURE. PRINTED COPIES OF THIS DOCUMENT ARE NOT CONSIDERED VALID UNLESS THEY ARE VERIFIED ON ANY ELECTRONIC COPIES. 12-13-2019

ARCHITECTURAL PROJECT NO: 088-19

GREGOR GRAMLICH, PE
 GEORGIA LICENSE #P820948
 13181 STARBUCK ROAD, SUITE 17
 LARGO, FLORIDA 33773
 (727) 538-9464

WHISKEY
 CAKE KITCHEN

PERIMETER MALL
 4400 ASHFORD DUNWOODY RD
 ATLANTA, GA 30348

NO.	REVISIONS	DATE

LANDLORD REVIEW ISSUE DATE: 12-05-2019
 RD ISSUE DATE: 12-13-2019
 PERMIT ISSUE DATE: 12-13-2019
 CONSTRUCTION ISSUE DATE: XXX-XX-XXXX

DRAWING TITLE:
WASTE AND VENT ISOMETRIC

DRAWING NUMBER:
P1.02

ISSUED FOR PERMIT - 12-13-2019