




DATE: AUGUST 18, 2017
DRAWN BY: JIM SETO
CHECKED BY: RICHARD JAMISON
DATE: 07-28-2017
Hilphoenix
14350 CHARLES PLACE
CHINA, CA 94710
PHONE: (925) 270-2111

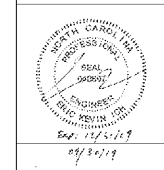


ARCHITECT OF RECORD:
BRANT T. MORRISON
NORTH CAROLINA REGISTRATION NO. #1117
REGISTERED ARCHITECT OF RECORD
ELECTRICAL ENGINEER OF RECORD:
ERIC KEVAN
NORTH CAROLINA REGISTRATION NO. #2848
REGISTERED ELECTRICAL ENGINEER OF RECORD
MECHANICAL ENGINEER OF RECORD:
ERIC KEVAN
NORTH CAROLINA REGISTRATION NO. #2848
REGISTERED MECHANICAL ENGINEER OF RECORD
PLUMBING ENGINEER OF RECORD:
ERIC KEVAN
NORTH CAROLINA REGISTRATION NO. #2848
REGISTERED PLUMBING ENGINEER OF RECORD

100% FOR CONSTRUCTION
10/06

BRANT T. MORRISON, AIA
PROJECT MANAGER
Miguel Vazquez/Heather Nilford
REGISTERED DD
PUBLIX 1484 Remodel
MCKEE FARMS
3110 Fincher Farm Rd.
Matthews, NC 28105
(APP)

122.11235.00

REFRIGERATION DEMOLITION PLAN
SCALE: 1/8" = 1'-0"
R1.0

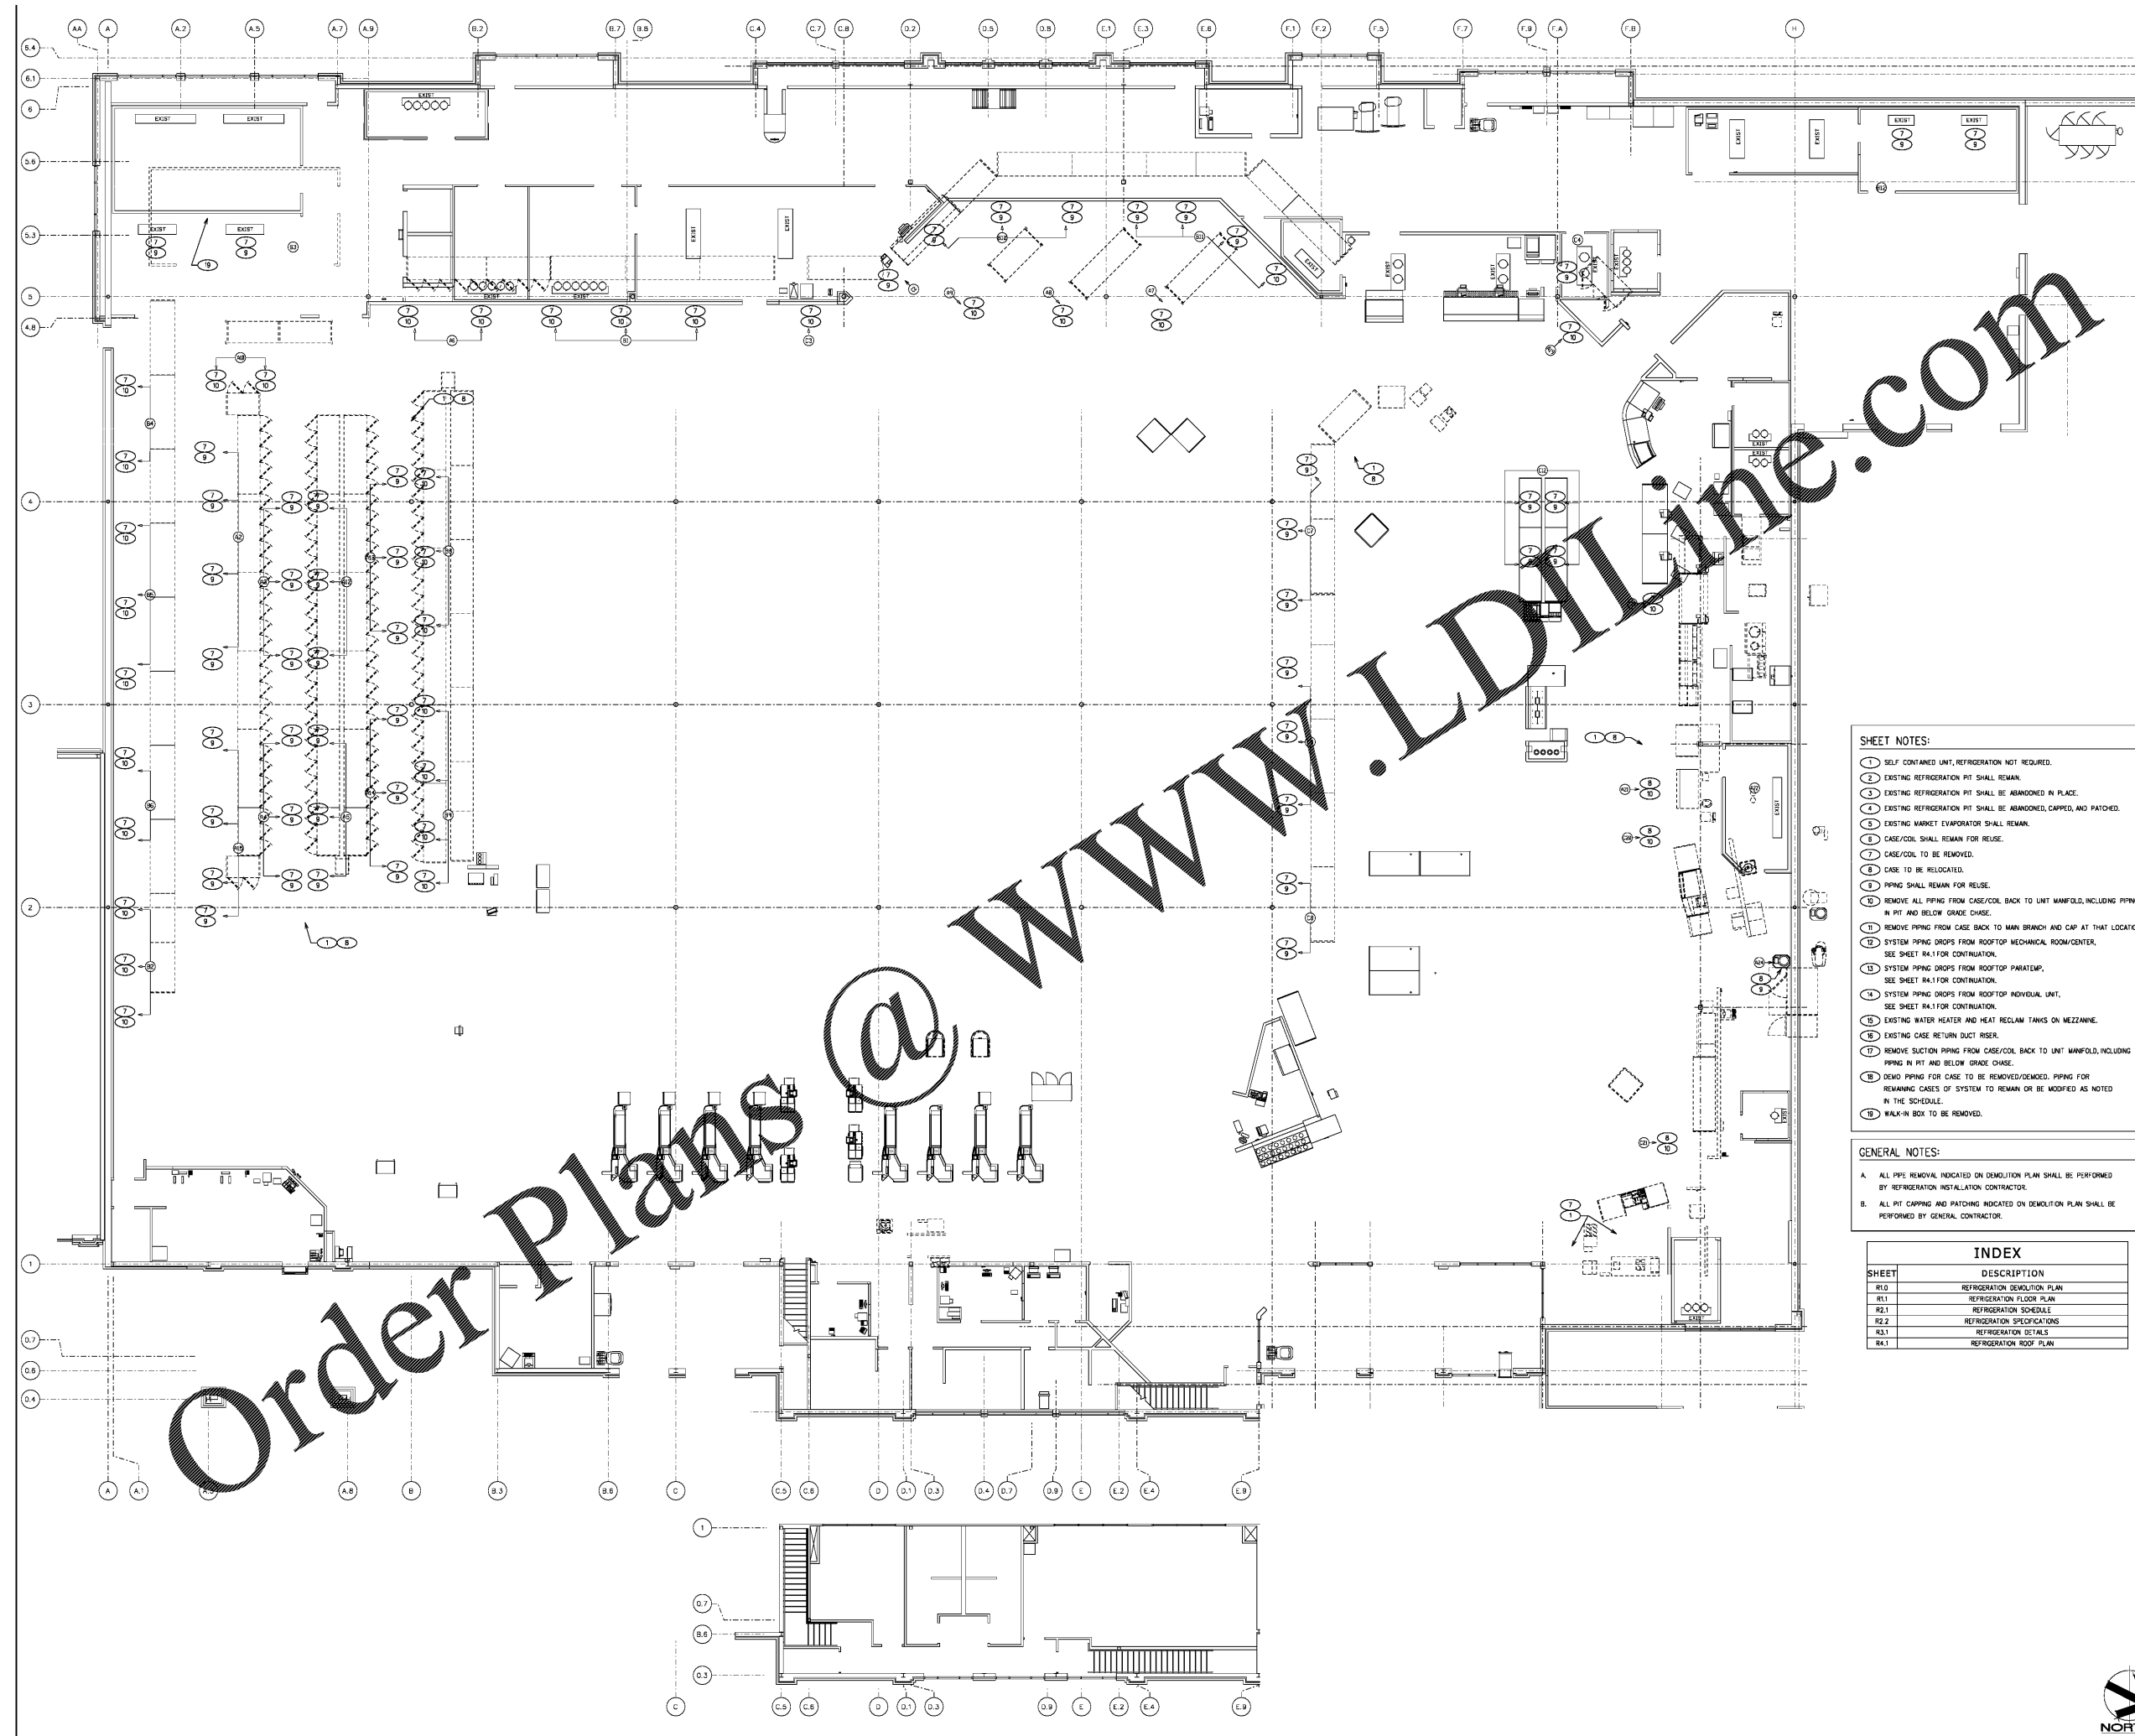

- SHEET NOTES:**
- 1 SELF CONTAINED UNIT, REFRIGERATION NOT REQUIRED.
 - 2 EXISTING REFRIGERATION PIT SHALL REMAIN.
 - 3 EXISTING REFRIGERATION PIT SHALL BE ABANDONED IN PLACE.
 - 4 EXISTING REFRIGERATION PIT SHALL BE ABANDONED, CAPPED, AND PATCHED.
 - 5 EXISTING MARKET EVAPORATOR SHALL REMAIN.
 - 6 CASE/COL SHALL REMAIN FOR REUSE.
 - 7 CASE/COL TO BE REMOVED.
 - 8 CASE TO BE RELOCATED.
 - 9 PIPING SHALL REMAIN FOR REUSE.
 - 10 REMOVE ALL PIPING FROM CASE/COL BACK TO UNIT MANIFOLD, INCLUDING PIPING IN PIT AND BELOW GRADE CHASE.
 - 11 REMOVE PIPING FROM CASE BACK TO MAIN BRANCH AND CAP AT THAT LOCATION. SEE SHEET RA-1 FOR CONTINUATION.
 - 12 SYSTEM PIPING DROPS FROM ROOFTOP MECHANICAL ROOM/CENTER. SEE SHEET RA-1 FOR CONTINUATION.
 - 13 SYSTEM PIPING DROPS FROM ROOFTOP PARATEMP. SEE SHEET RA-1 FOR CONTINUATION.
 - 14 SYSTEM PIPING DROPS FROM ROOFTOP INDIVIDUAL UNIT. SEE SHEET RA-1 FOR CONTINUATION.
 - 15 EXISTING WATER HEATER AND HEAT RECLAIM TANKS ON MEZZANINE.
 - 16 EXISTING CASE RETURN DUCT RISER.
 - 17 REMOVE SUCTION PIPING FROM CASE/COL BACK TO UNIT MANIFOLD, INCLUDING PIPING IN PIT AND BELOW GRADE CHASE.
 - 18 DEMO PIPING FOR CASE TO BE REMOVED/DEMED. PIPING FOR REMAINING CASES OF SYSTEM TO REMAIN OR BE MODIFIED AS NOTED IN THE SCHEDULE.
 - 19 WALK-IN BOX TO BE REMOVED.

- GENERAL NOTES:**
- A. ALL PIPE REMOVAL INDICATED ON DEMOLITION PLAN SHALL BE PERFORMED BY REFRIGERATION INSTALLATION CONTRACTOR.
 - B. ALL PIT CAPPING AND PATCHING INDICATED ON DEMOLITION PLAN SHALL BE PERFORMED BY GENERAL CONTRACTOR.

INDEX

SHEET	DESCRIPTION
R1.0	REFRIGERATION DEMOLITION PLAN
R1.1	REFRIGERATION FLOOR PLAN
R2.1	REFRIGERATION SCHEDULE
R2.2	REFRIGERATION SPECIFICATIONS
R3.1	REFRIGERATION DETAILS
R4.1	REFRIGERATION ROOF PLAN

Order Plans @