

FULTON COUNTY SCHOOL SYSTEM  
EVOLINE C. WEST ELEMENTARY SCHOOL  
- RENOVATIONS

7040 RIVERTOWN RD  
FAIRBURN, GA 30213

PROJECT NO: 18048.00

CD 55% CD	08/07/2018
CD 55% CD - re-submit	11/20/2018
CD 80% CD	10/04/2018
CD PERMIT SET	11/19/2018
CD BID SET	12/20/2018





SHEET TITLE  
MECHANICAL DEMOLITION FLOOR PLANS

SHEET NUMBER

MD102C

Order Plans @ [WWW.LDILine.com](http://WWW.LDILine.com)

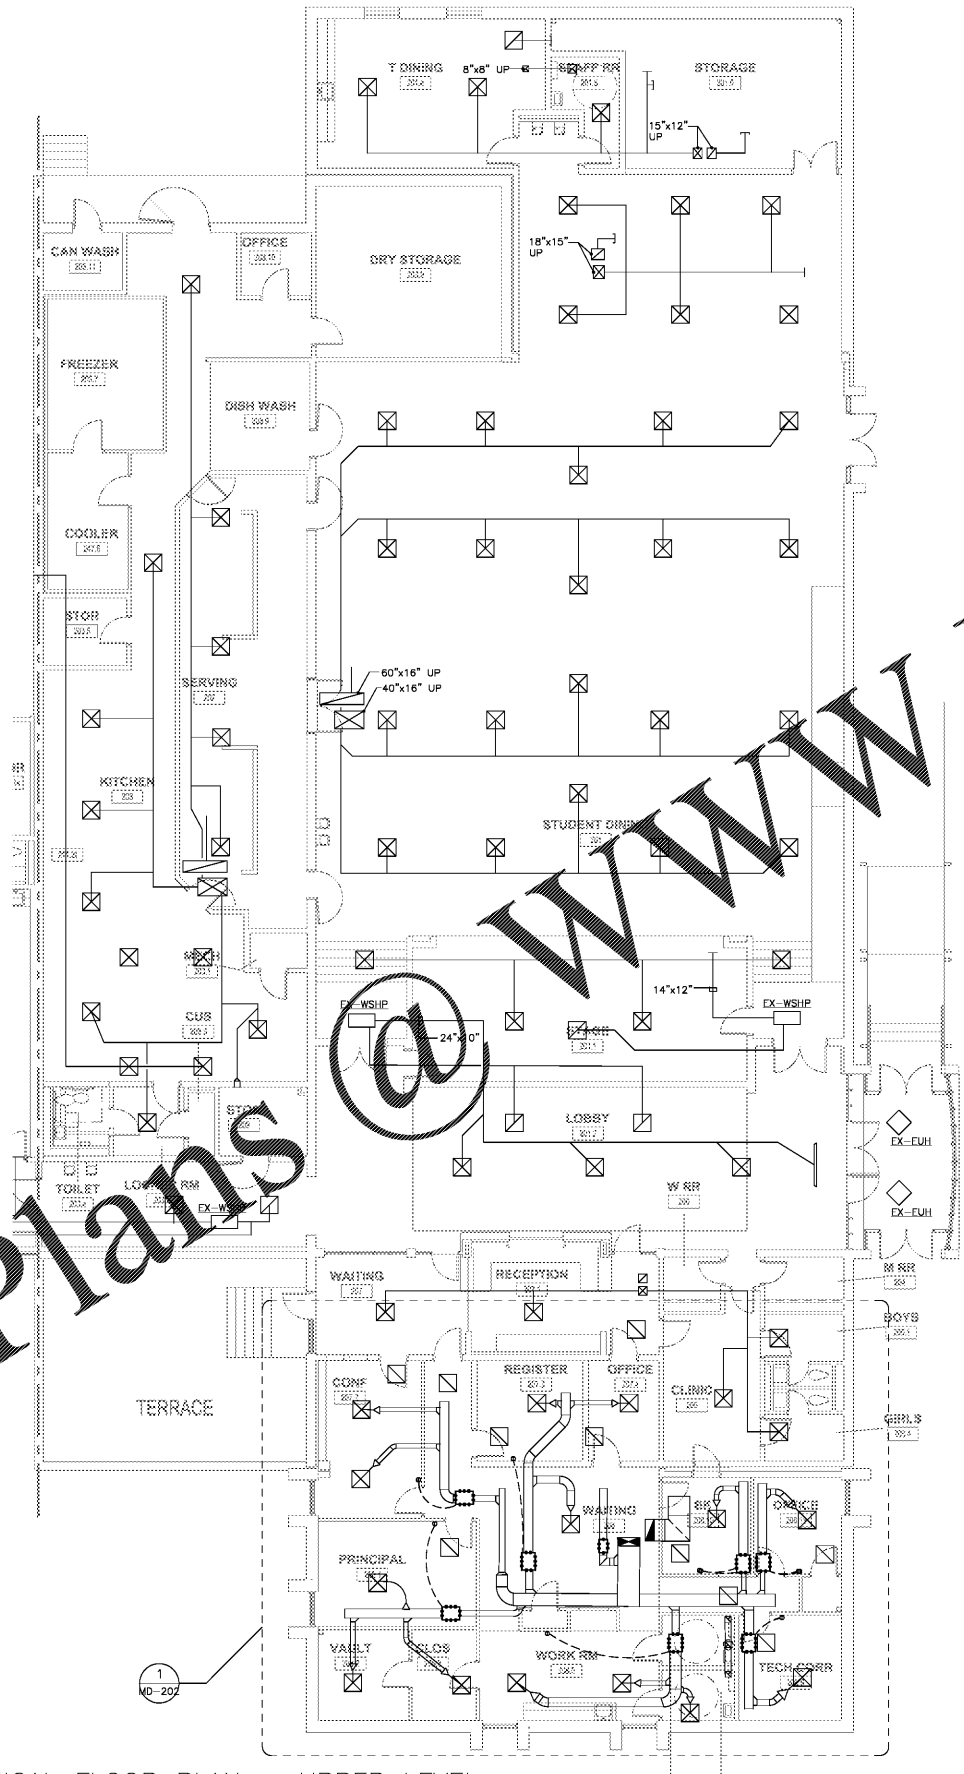

MECHANICAL FLOOR PLAN - UPPER LEVEL  
SCALE: 1/8" = 1' 0"

