



675 Tower Road
Marietta, GA 30060-8958
770.423.0016
www.cdipartners.com

COPYRIGHT © 2018 by CD PARTNERS INC.
All rights reserved.

FULTON COUNTY SCHOOL SYSTEM
EVOLINE C. WEST ELEMENTARY SCHOOL
- RENOVATIONS
7040 RIVERTOWN RD
FAIRBURN, GA 30213

PROJECT NO: 18048.00


CD 55% CD	08/07/2018
CD 55% CD - resubmit	11/20/2018
CD 80% CD	10/04/2018
CD PERMIT SET	11/15/2018
CD BID SET	12/20/2018





SHEET TITLE
MECHANICAL DEMOLITION PLAN - ROOF

SHEET NUMBER
MD103B

DRAWING NOTES:
① REMOVE EXISTING ROOFTOP AIR HANDLING UNIT AND DISCONNECT ALL ASSOCIATED CONTROLS AND WIRING.

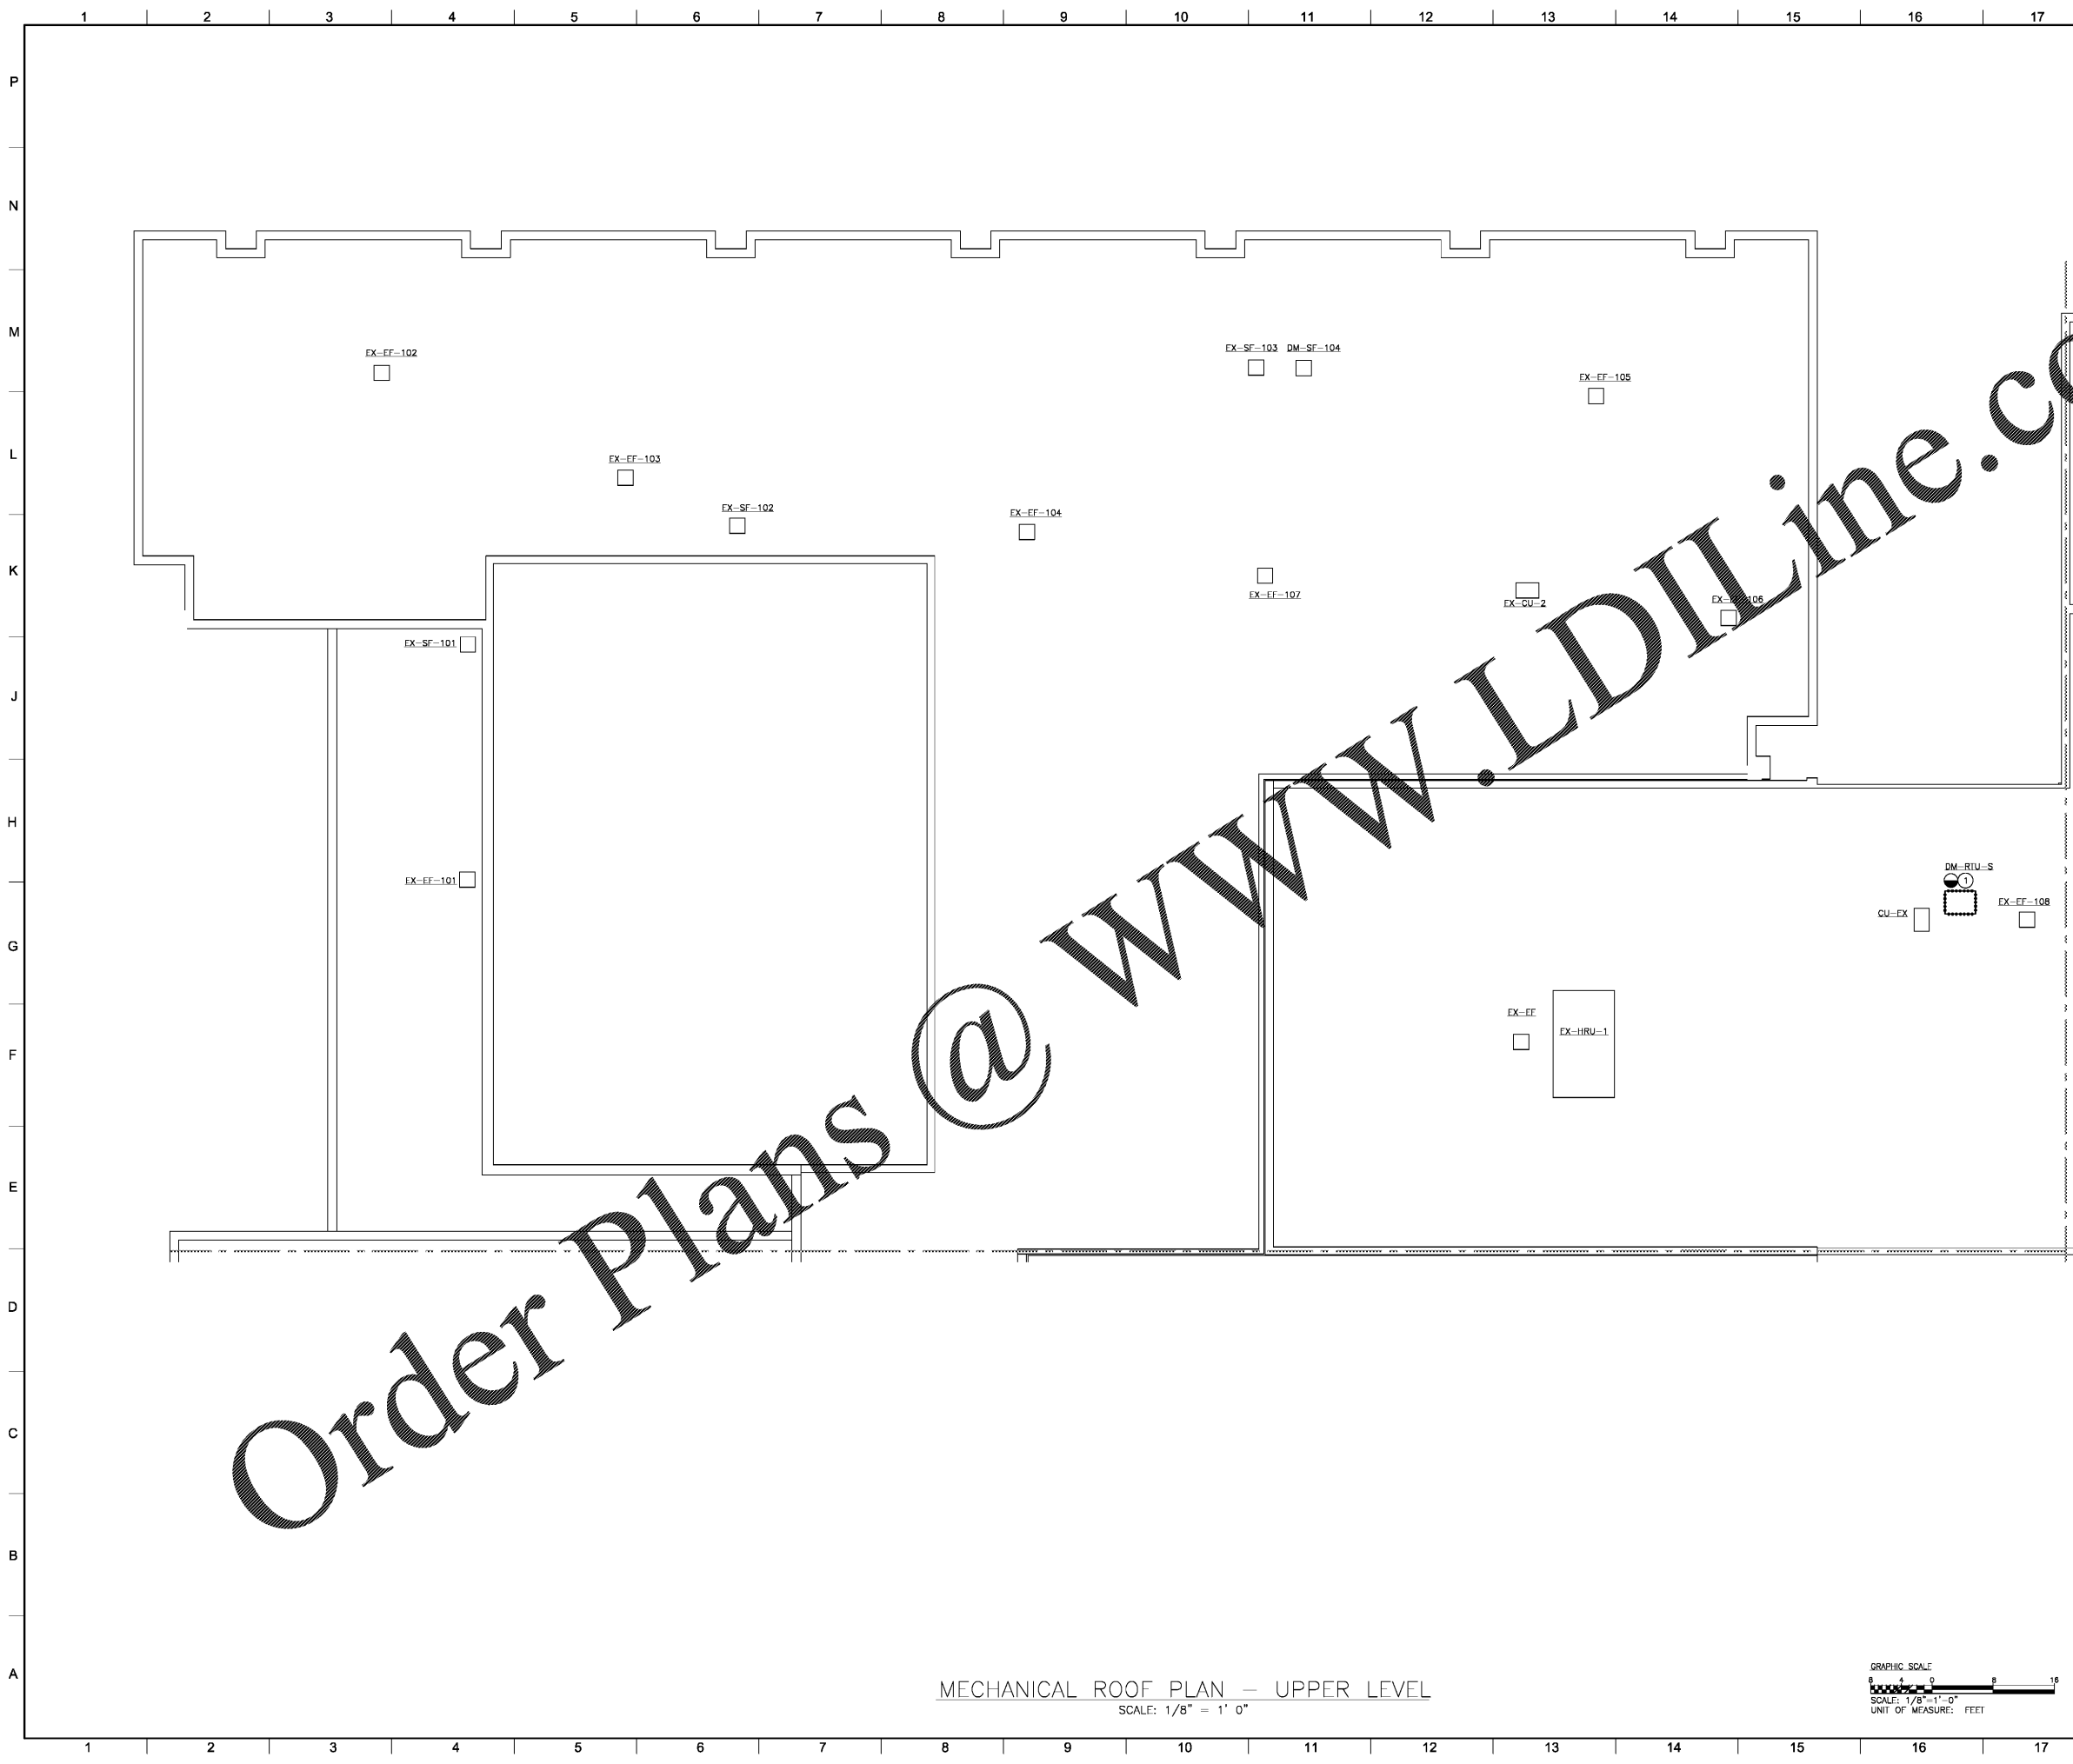

 MECHANICAL ROOF PLAN - UPPER LEVEL
SCALE: 1/8" = 1' 0"

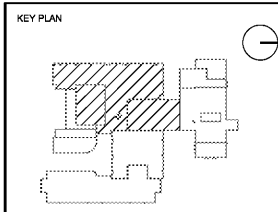

Order Plans @ www.LDILine.com