




675 Tower Road
Marietta, GA 30060-8958
770.423.0016
www.cdhparkers.com

COPYRIGHT © 2018 BY CDH PARTNERS INC.
ALL RIGHTS RESERVED.

FULTON COUNTY SCHOOL SYSTEM
EVOLINE C. WEST ELEMENTARY SCHOOL
- RENOVATIONS

7040 RIVERTOWN RD
FAIRBURN, GA 30213


PROJECT NO:	18048.00
50% CD	08/07/2018
50% CD - re-submit	11/20/2018
80% CD	10/04/2019
PERMIT SET	11/19/2019
BID SET	12/20/2019

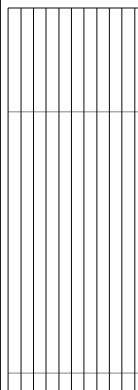

SHEET TITLE
MECHANICAL FLOOR
PLAN - UPPER
LEVEL

SHEET NUMBER

M102C

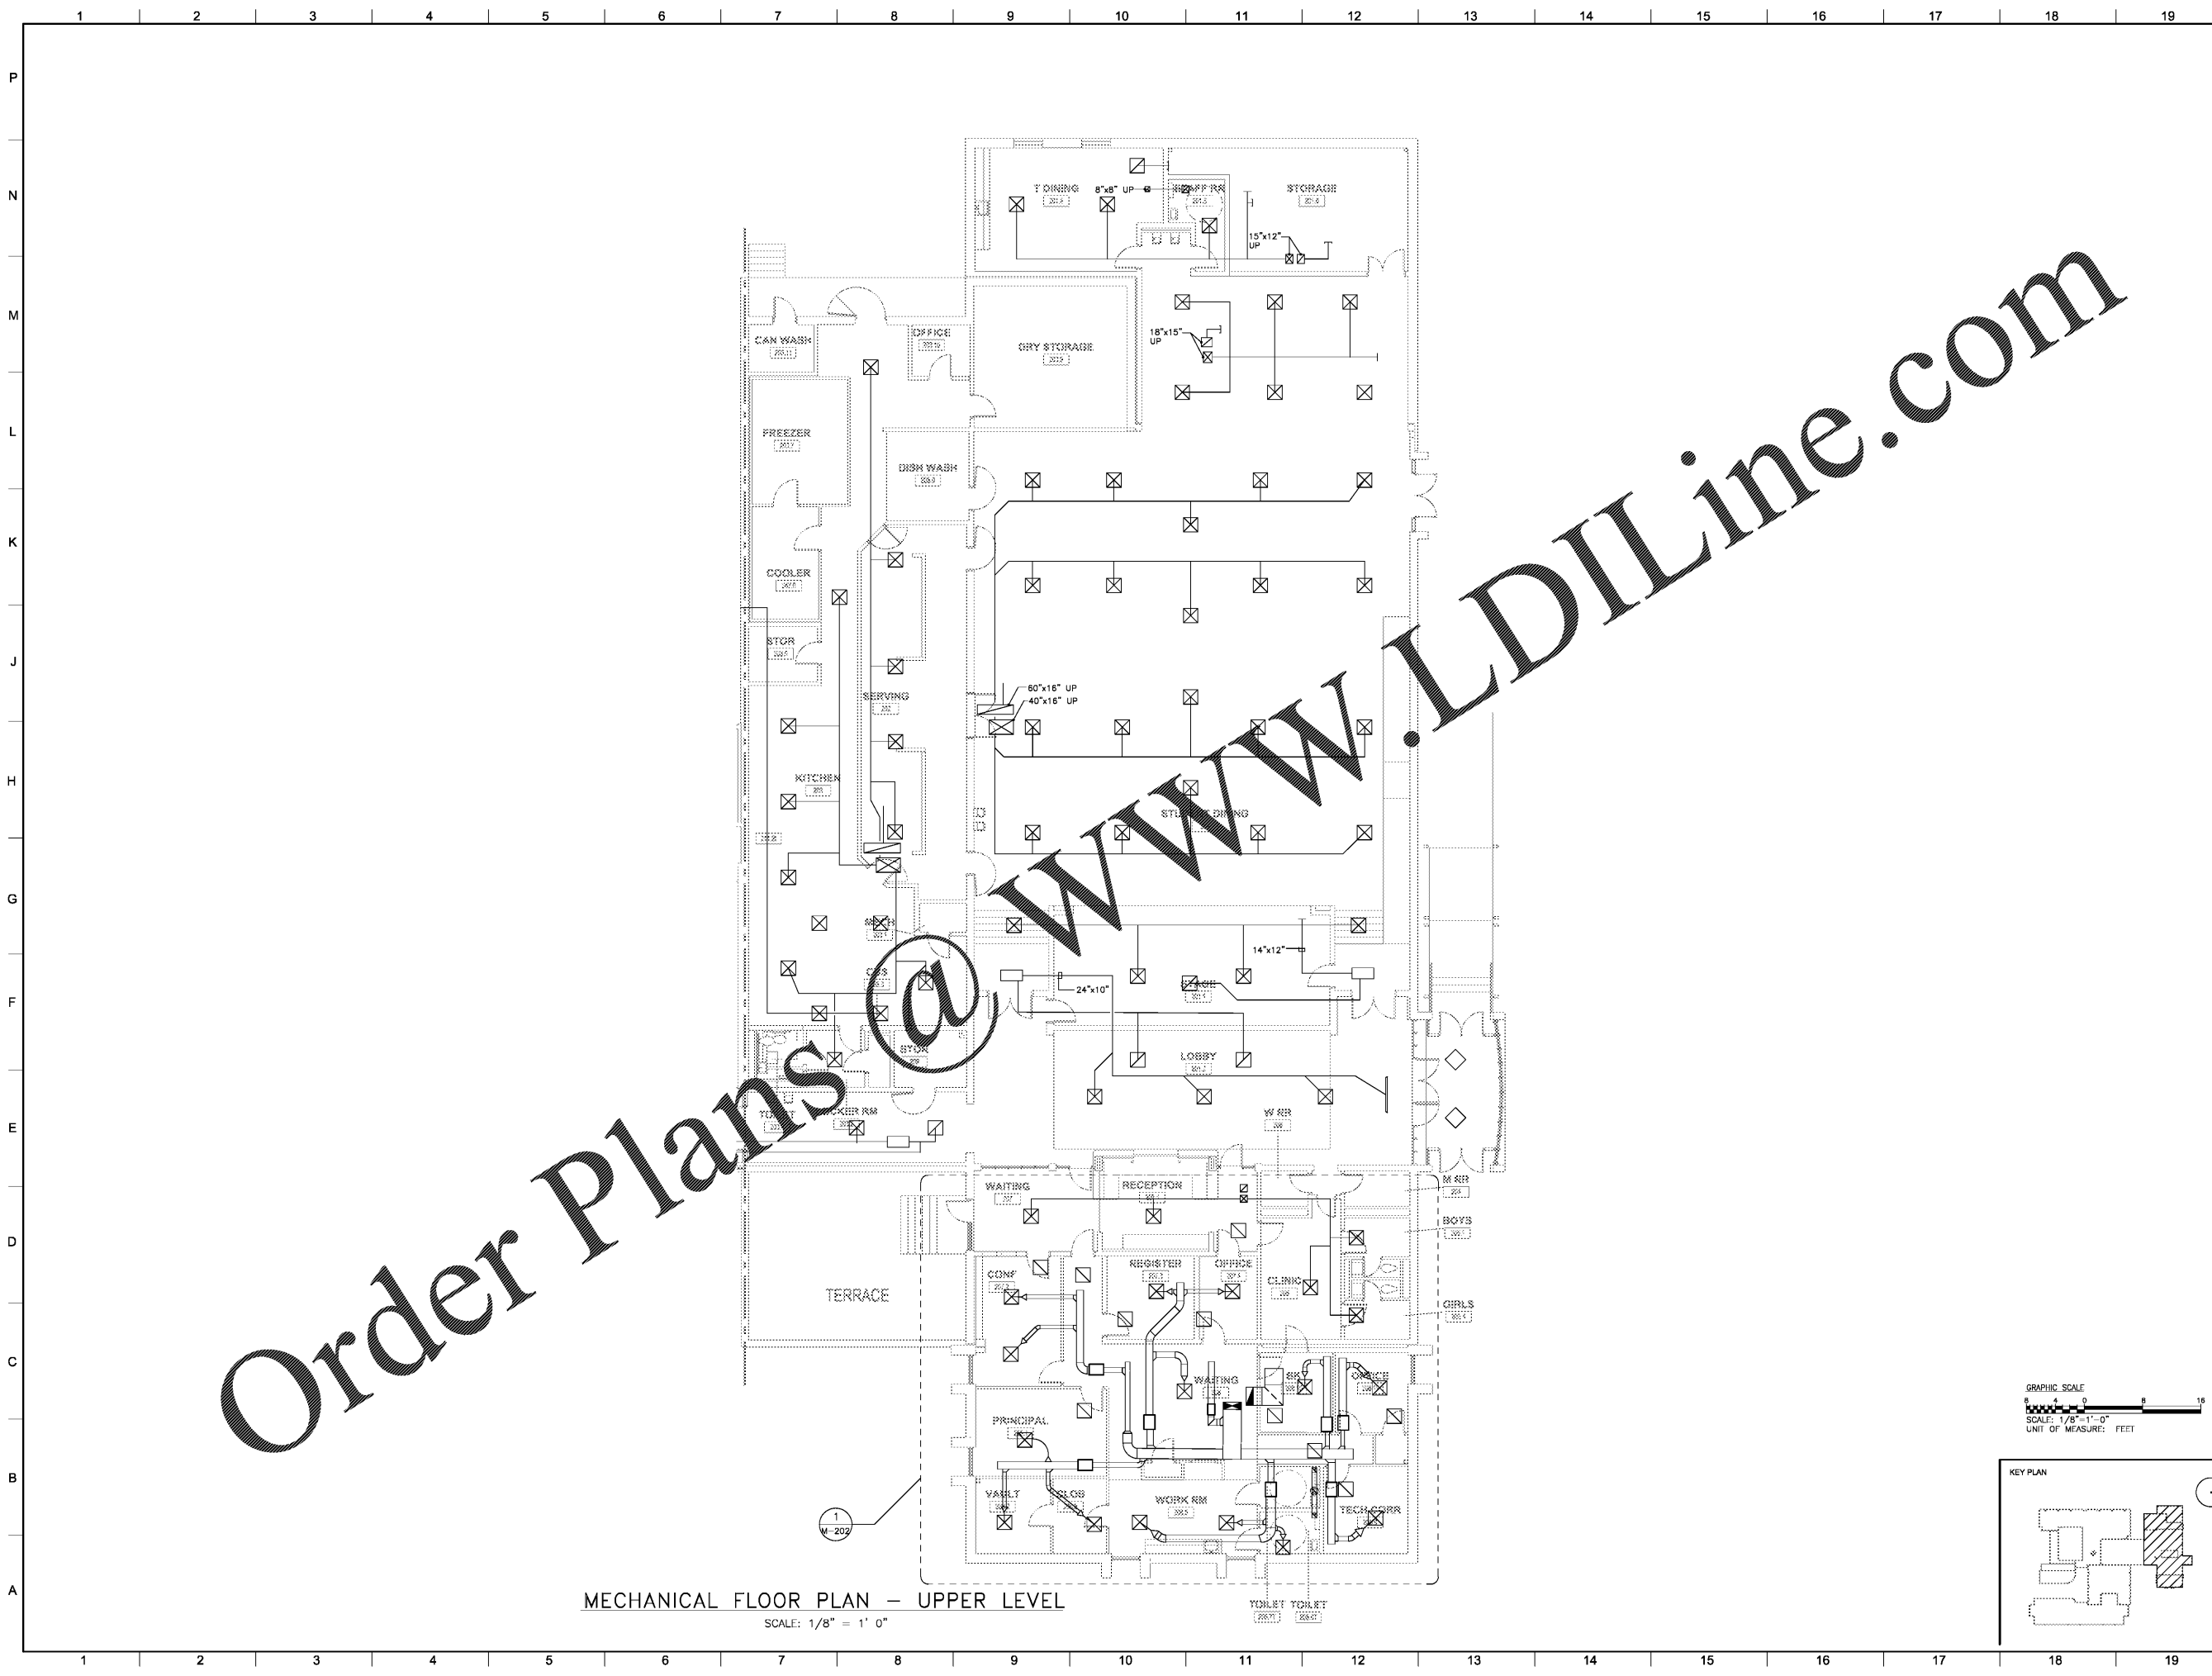

Order Plans @ www.LDILine.com

MECHANICAL FLOOR PLAN - UPPER LEVEL
SCALE: 1/8" = 1' 0"

