



675 Tower Road
Marietta, GA 30060-8958
770.423.0016
www.cdhparkers.com

COPYRIGHT © 2018 BY CDH-PARTNERS INC.
ALL RIGHTS RESERVED.

FULTON COUNTY SCHOOL SYSTEM
**EVOLINE C. WEST ELEMENTARY SCHOOL
- RENOVATIONS**
7040 RIVERTOWN RD
FAIRBURN, GA 30213

PROJECT NO: 18048.00


CD 50% CD	08/07/2018
CD 50% CD - re-submit	11/20/2018
CD 80% CD	10/04/2018
CD PERMIT SET	11/19/2018
CD BID SET	12/20/2018



SHEET TITLE
MECHANICAL ROOF PLAN

SHEET NUMBER
M103C

DRAWING NOTES:
① INSTALL NEW ROOFTOP AIR HANDLING UNIT AND CONNECT TO ASSOCIATED PIPING, DUCTWORK, CONTROLS, AND WIRING.

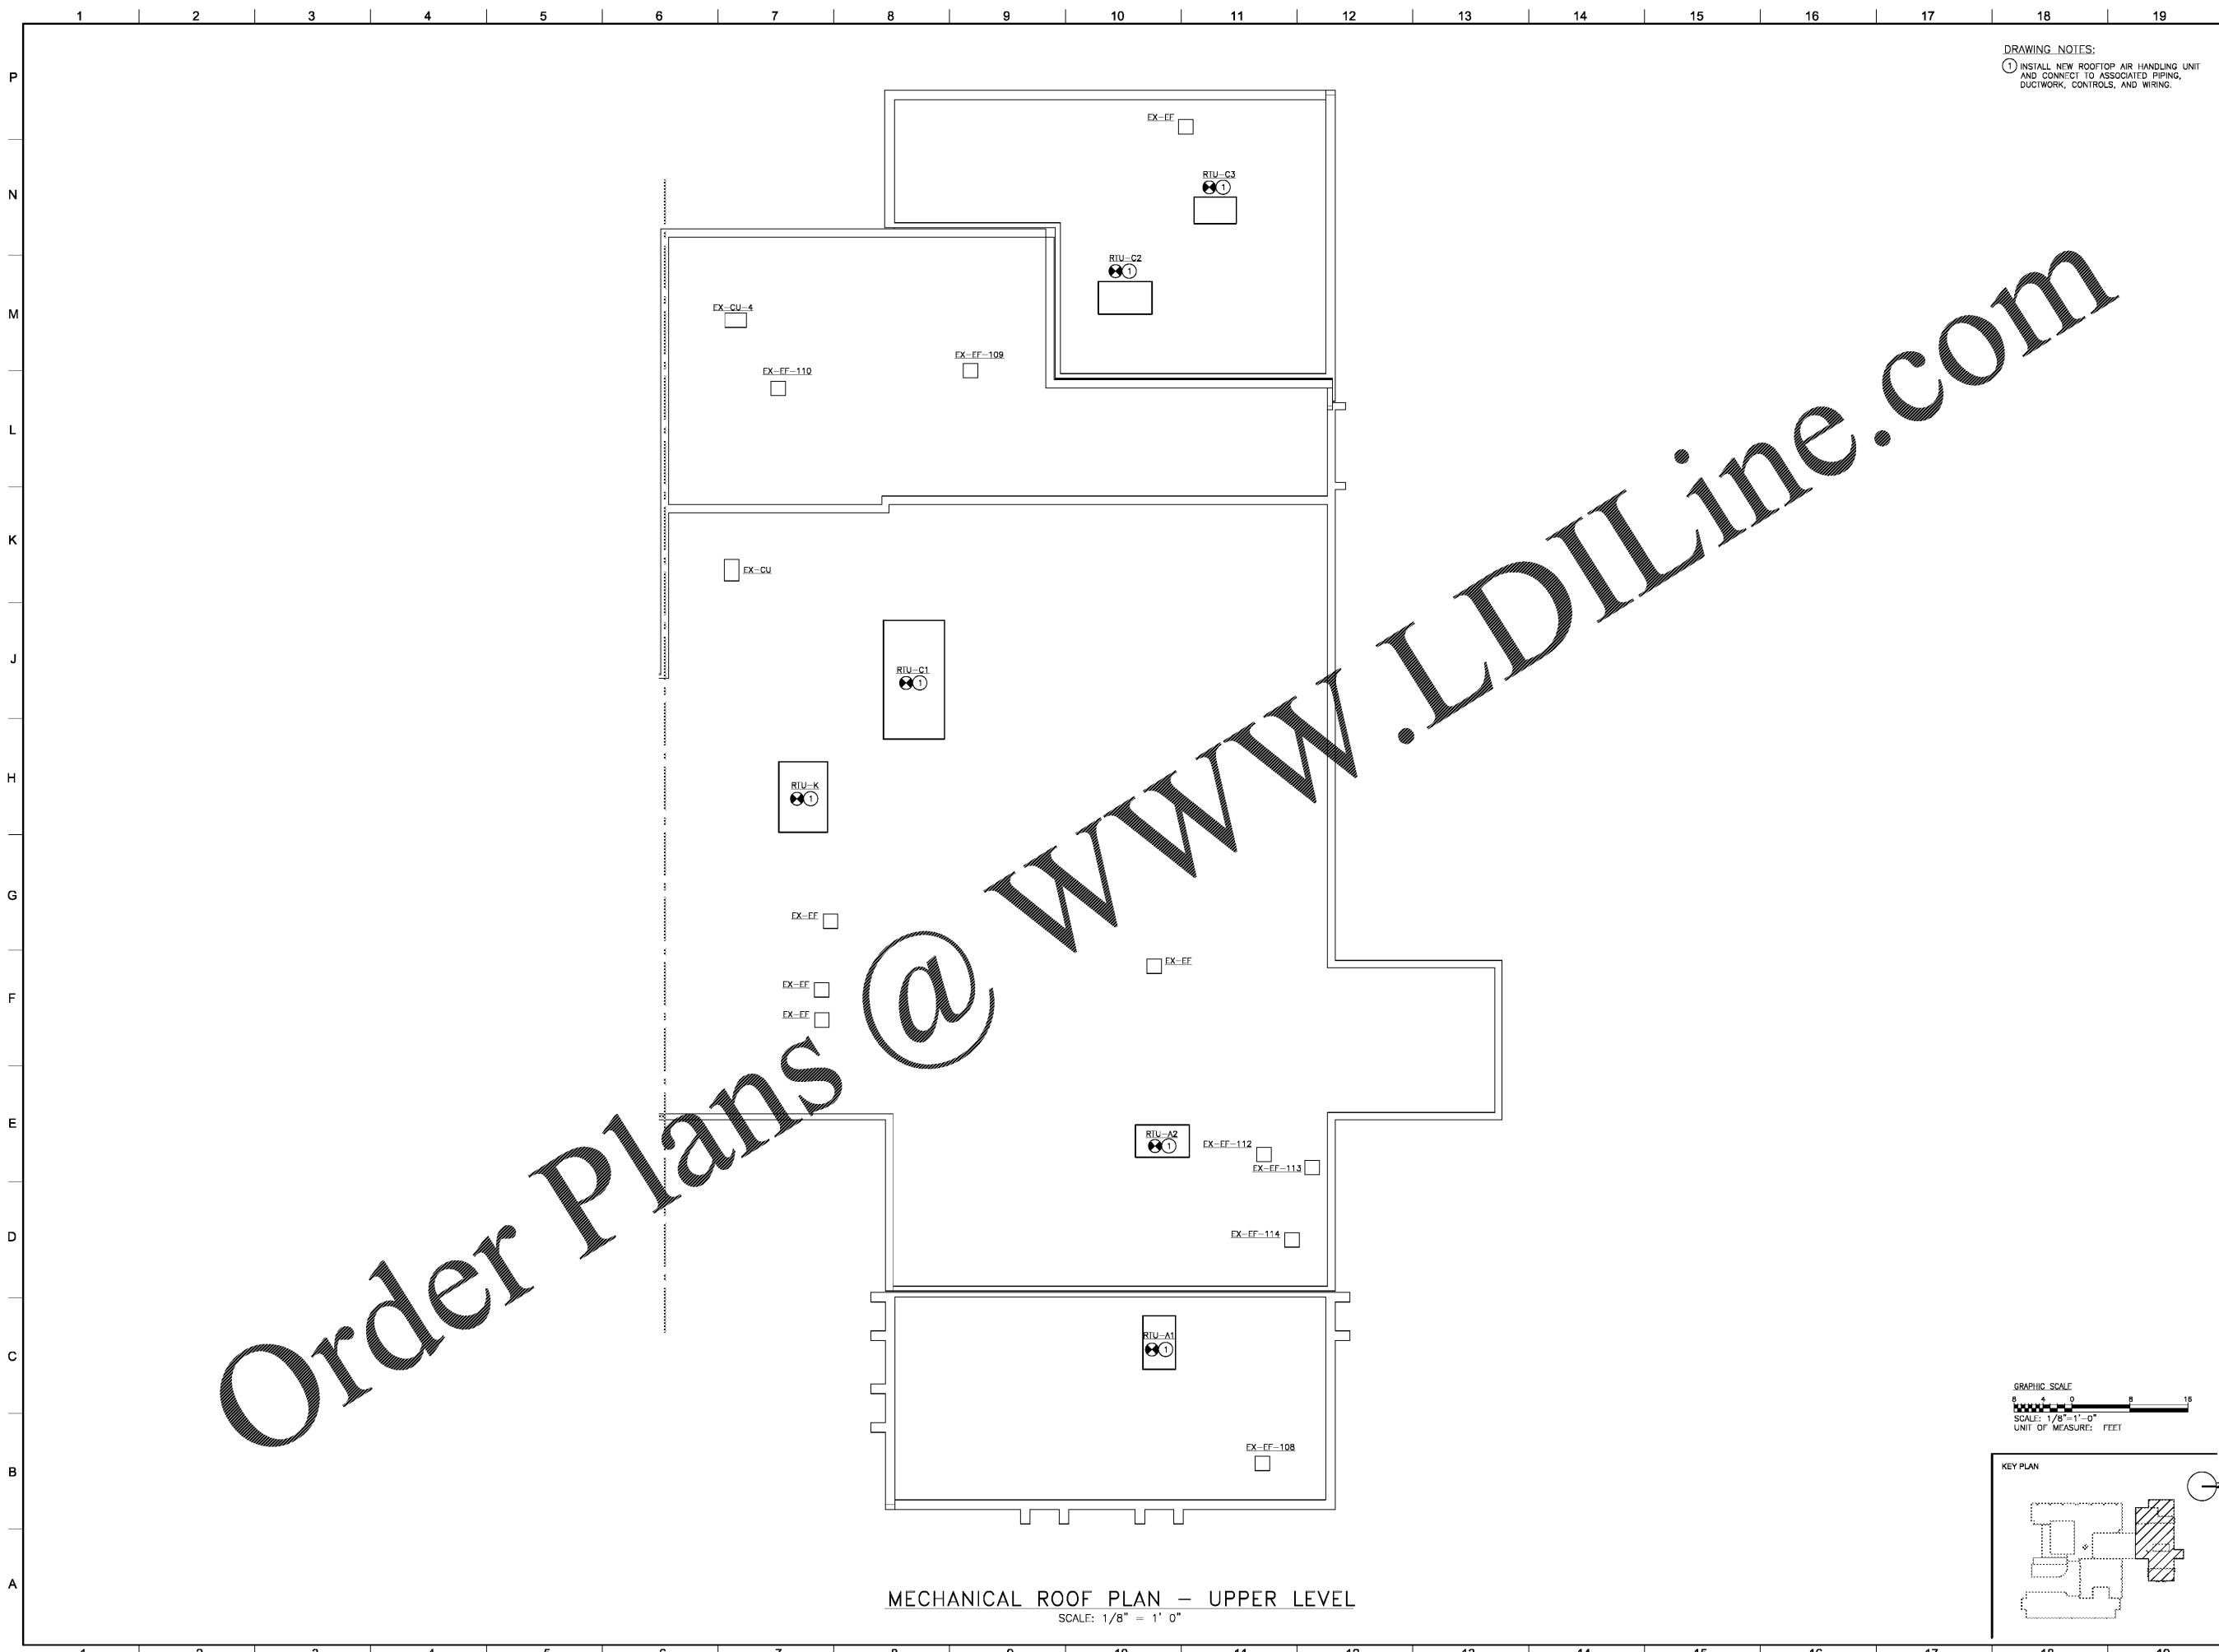

Order Plans @ www.LDILine.com

MECHANICAL ROOF PLAN - UPPER LEVEL
SCALE: 1/8" = 1' 0"