

These drawings are instruments of service and as such remain the property of the architect. No copies or reproductions of these drawings are permitted without the consent of the architect. Upon completion of the work all the drawings (except the contract copies) are to be returned to the architect.  
 Copyright © 2019



1920 Hwy. 54, Suite 700, Durham, NC 27713  
 Ph. 919-544-1936 - Fax 919-544-2540 - License: C-1813

RENOVATIONS TO :

ABC STORE

HOLLOWAY ST.  
 DURHAM, NC

PROJECT NUMBER  
 19-063

Plumbing Plan -  
 Roof


**DTW**  
 Architects &  
 Planners, Ltd.  
 229 North Gregson Street  
 Durham, NC 27701  
 919.317.4020

CONSTRUCTION DOCUMENTS

Revisions

Drawn LDH  
 Checked CTC  
 Date 12/18/2019  
 Sheet

P2.3  
 of

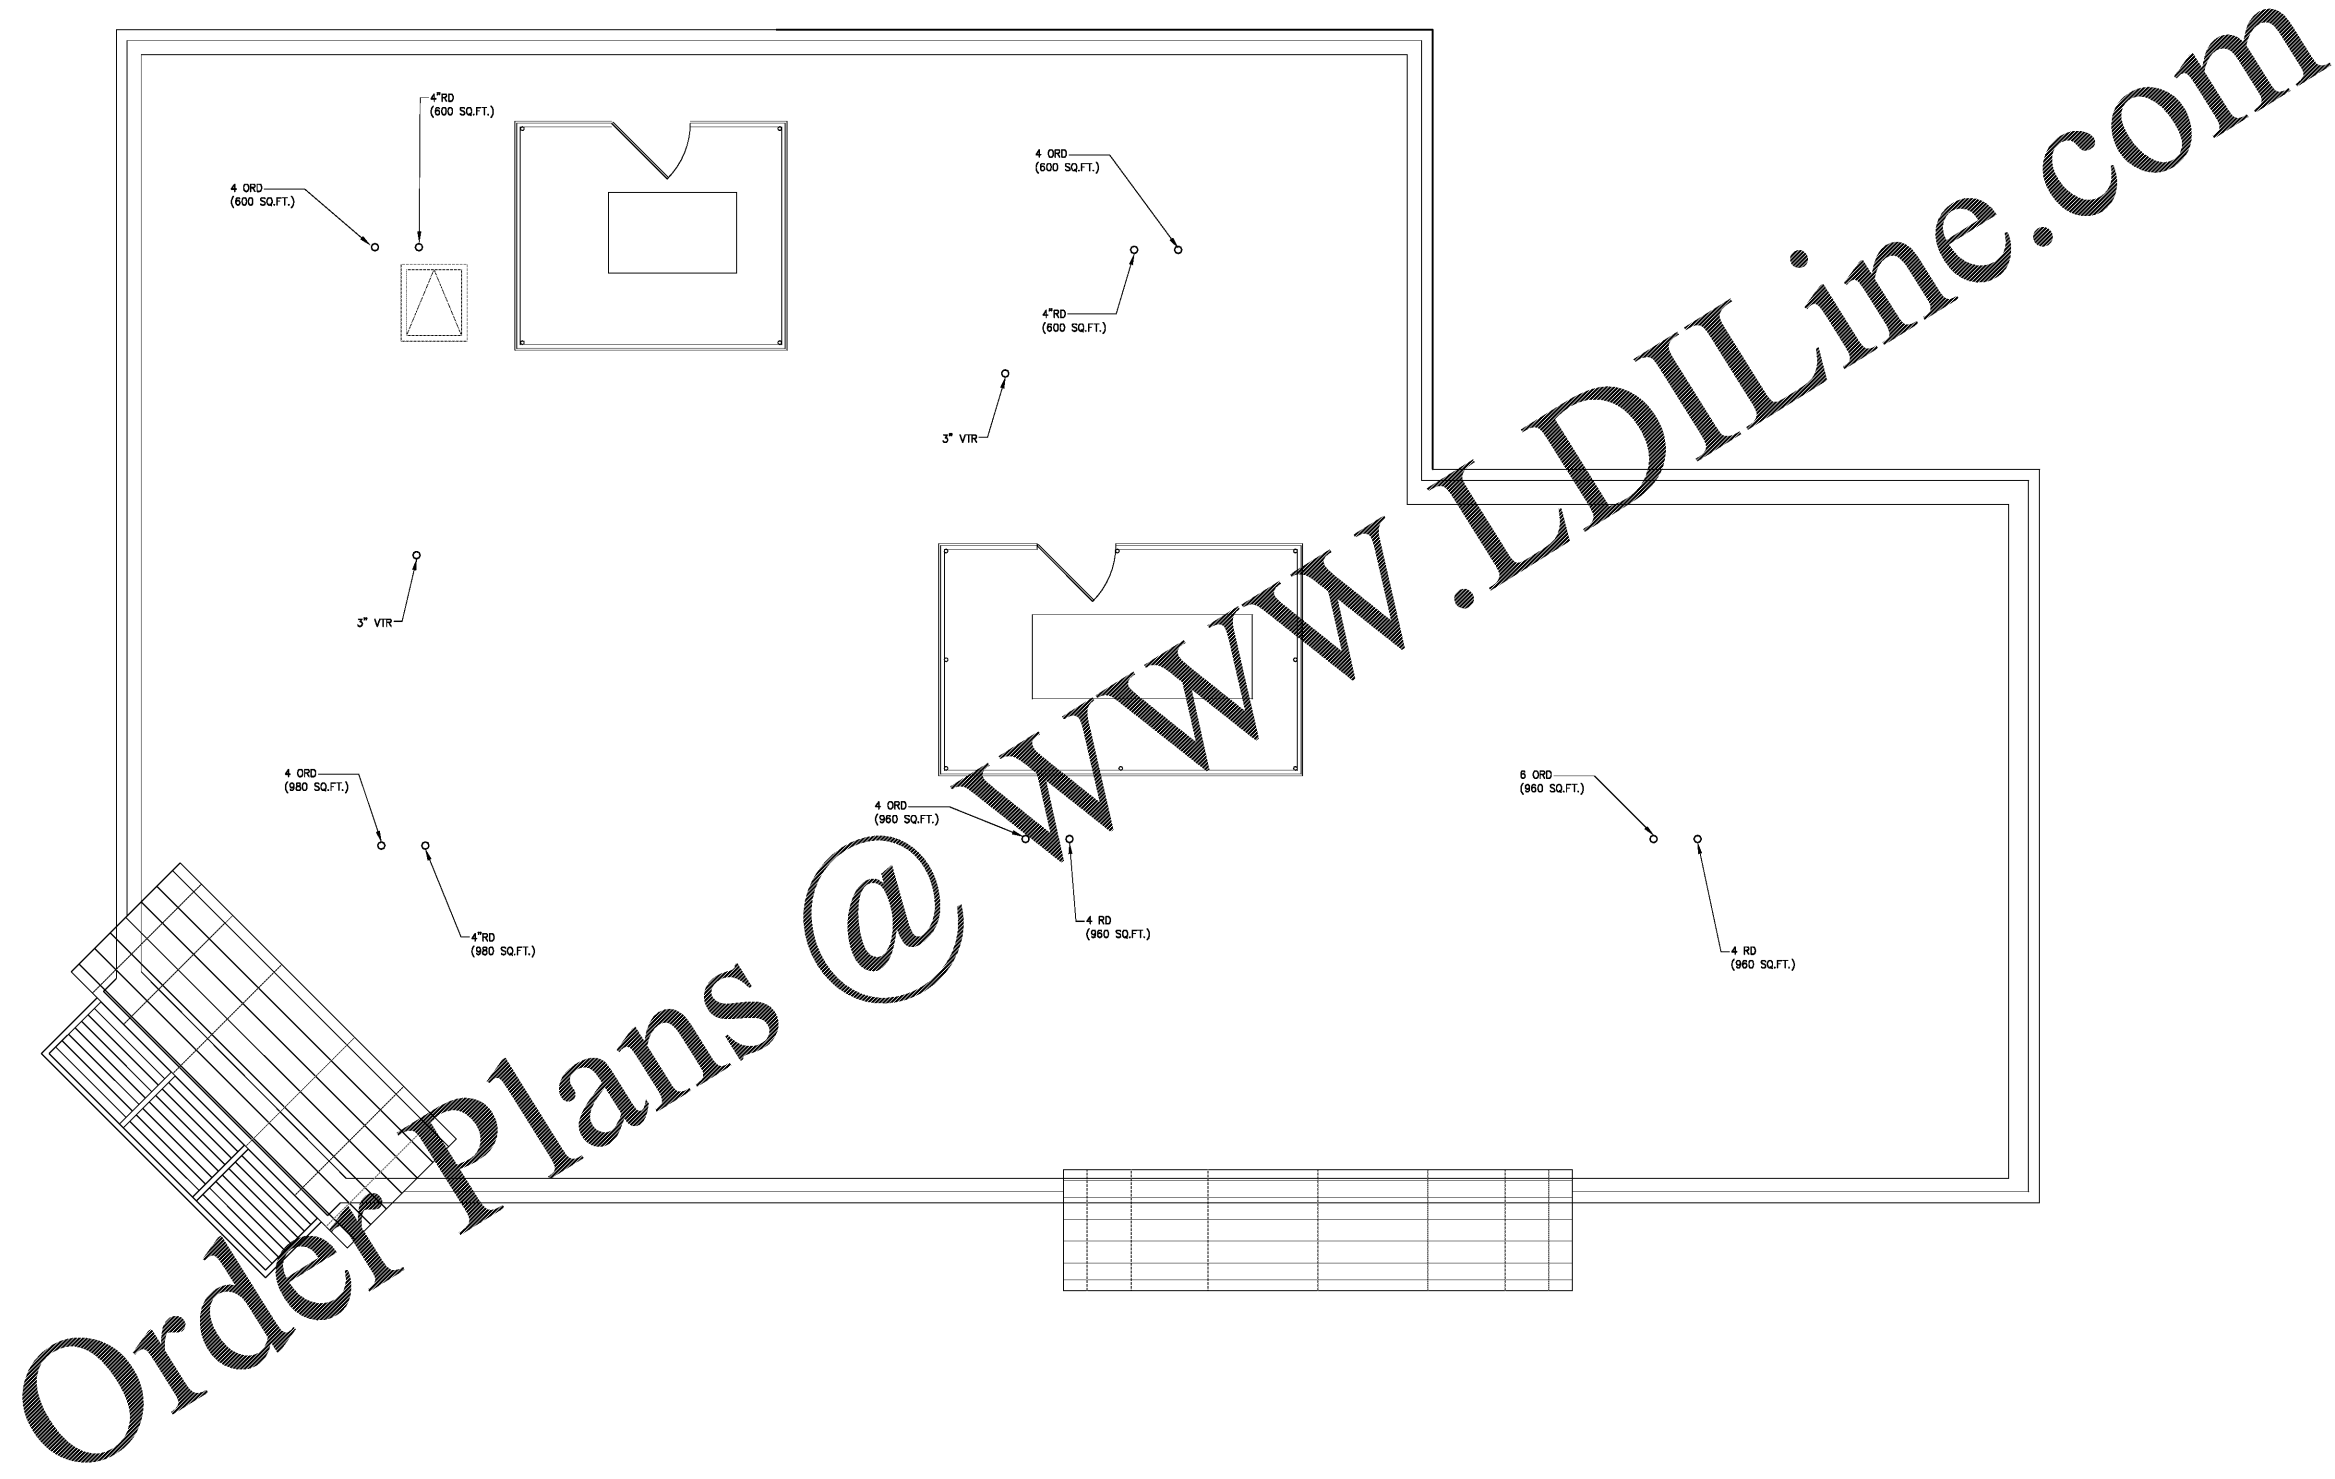

**2** Plumbing Renovation Plan - Roof  
**P2.3** SCALE: 1/4" = 1'-0"

P:\PROJECTS\19-063-ABC STORE - HOLLOWAY ST.\19-063 PLUMBING\19-063-ROOF.PLT DWG 12/18/2019 1:17 PM BY: DUBEN, KESTER