

RENOVATION AND
ADDITION FOR
**ABERDEEN
POLICE
DEPARTMENT**



**SPRINKLER SYSTEM
FLOOR PLAN FIRE
PROTECTION**


DATE: 10/25/2019
PROJECT NO: 18062

REVISIONS

NO.	DATE	DESCRIPTION

THIS DRAWING IS THE PROPERTY OF ADW ARCHITECTS, P.A. AND SHALL NOT BE REPRODUCED OR COPIED IN WHOLE OR PART. IT SHALL NOT BE USED ON ANY OTHER PROJECT OR GIVEN TO ANY OTHER COMPANY OR AGENCY WITHOUT THE CONSENT OF ADW ARCHITECTS, P.A.

SHEET NUMBER
FP101

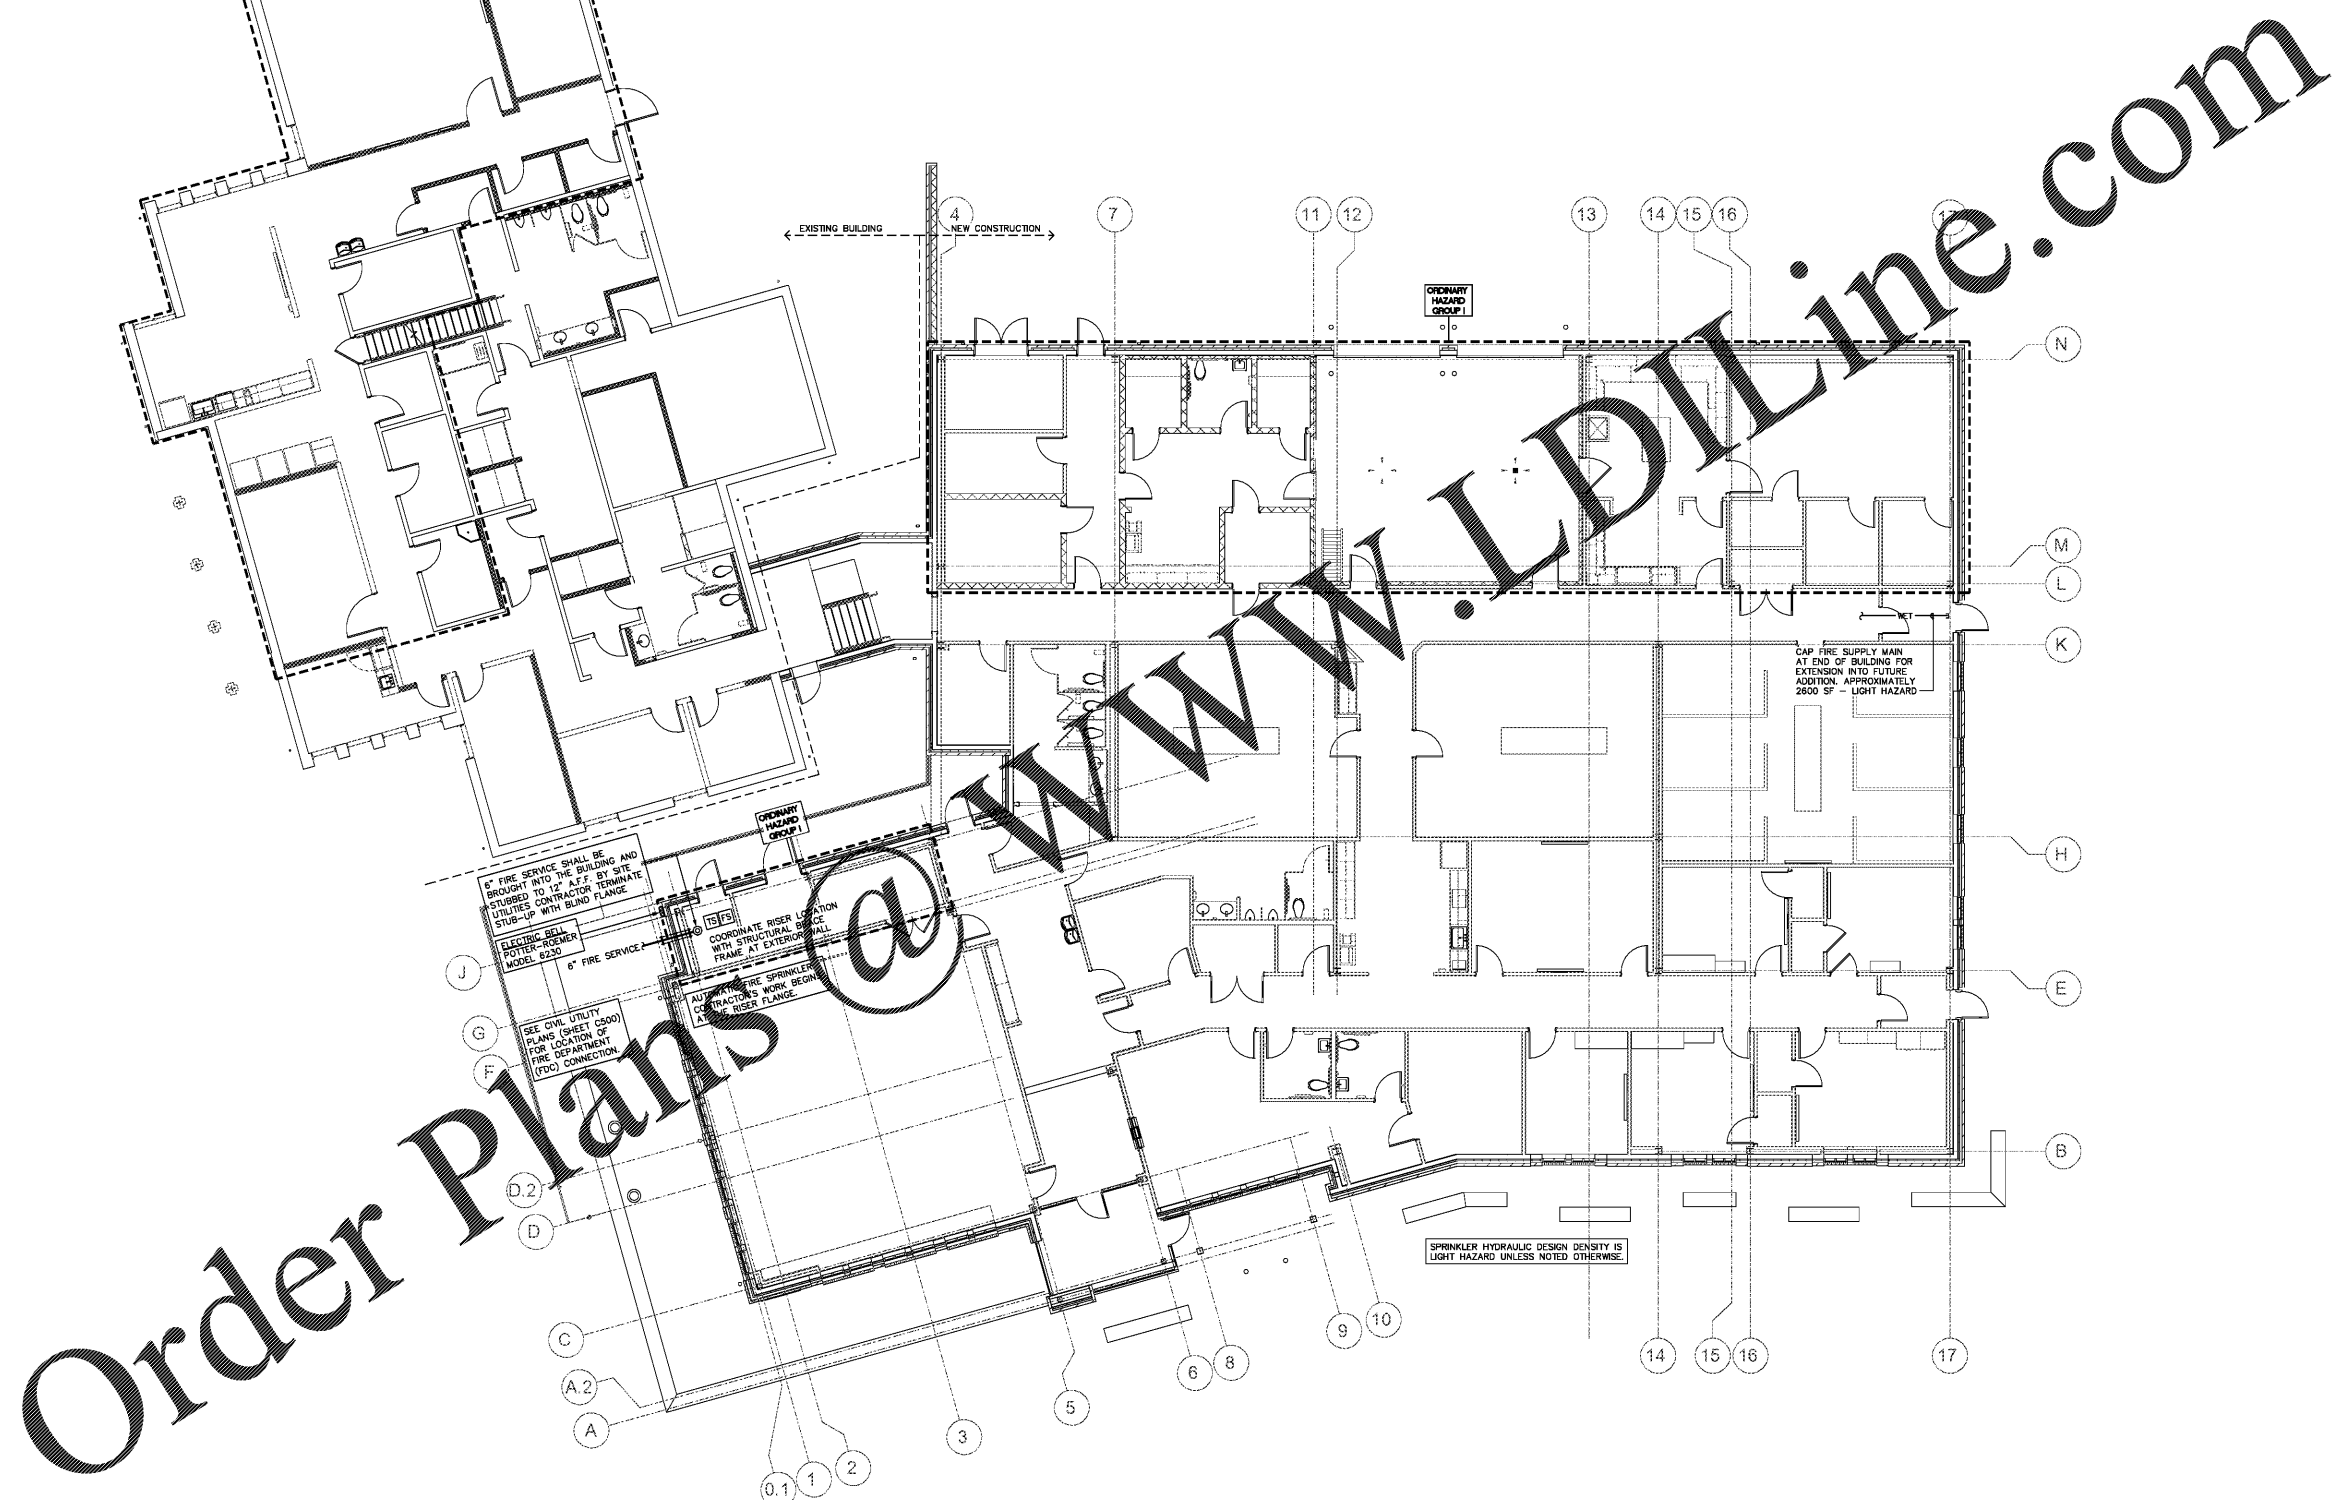

1 SPRINKLER SYSTEM FLOOR PLAN - FIRE PROTECTION
1/8" = 1'-0"

Order Plans @