

RENOVATION AND
ADDITION FOR
**ABERDEEN
POLICE
DEPARTMENT**



10/25/2019

**WATER SUPPLY
FLOOR PLAN
PLUMBING**

DATE: 10/25/2019
PROJECT NO: 18062


REVISIONS
NO. DATE DESCRIPTION:

THIS DRAWING IS THE PROPERTY OF ADW ARCHITECTS, P.A. AND SHALL NOT BE REPRODUCED OR COPIED IN WHOLE OR PART. IT SHALL NOT BE USED ON ANY OTHER PROJECT OR GIVEN TO ANY OTHER COMPANY OR AGENCY WITHOUT THE CONSENT OF ADW ARCHITECTS, P.A.

SHEET NUMBER

P201

5 OF 7

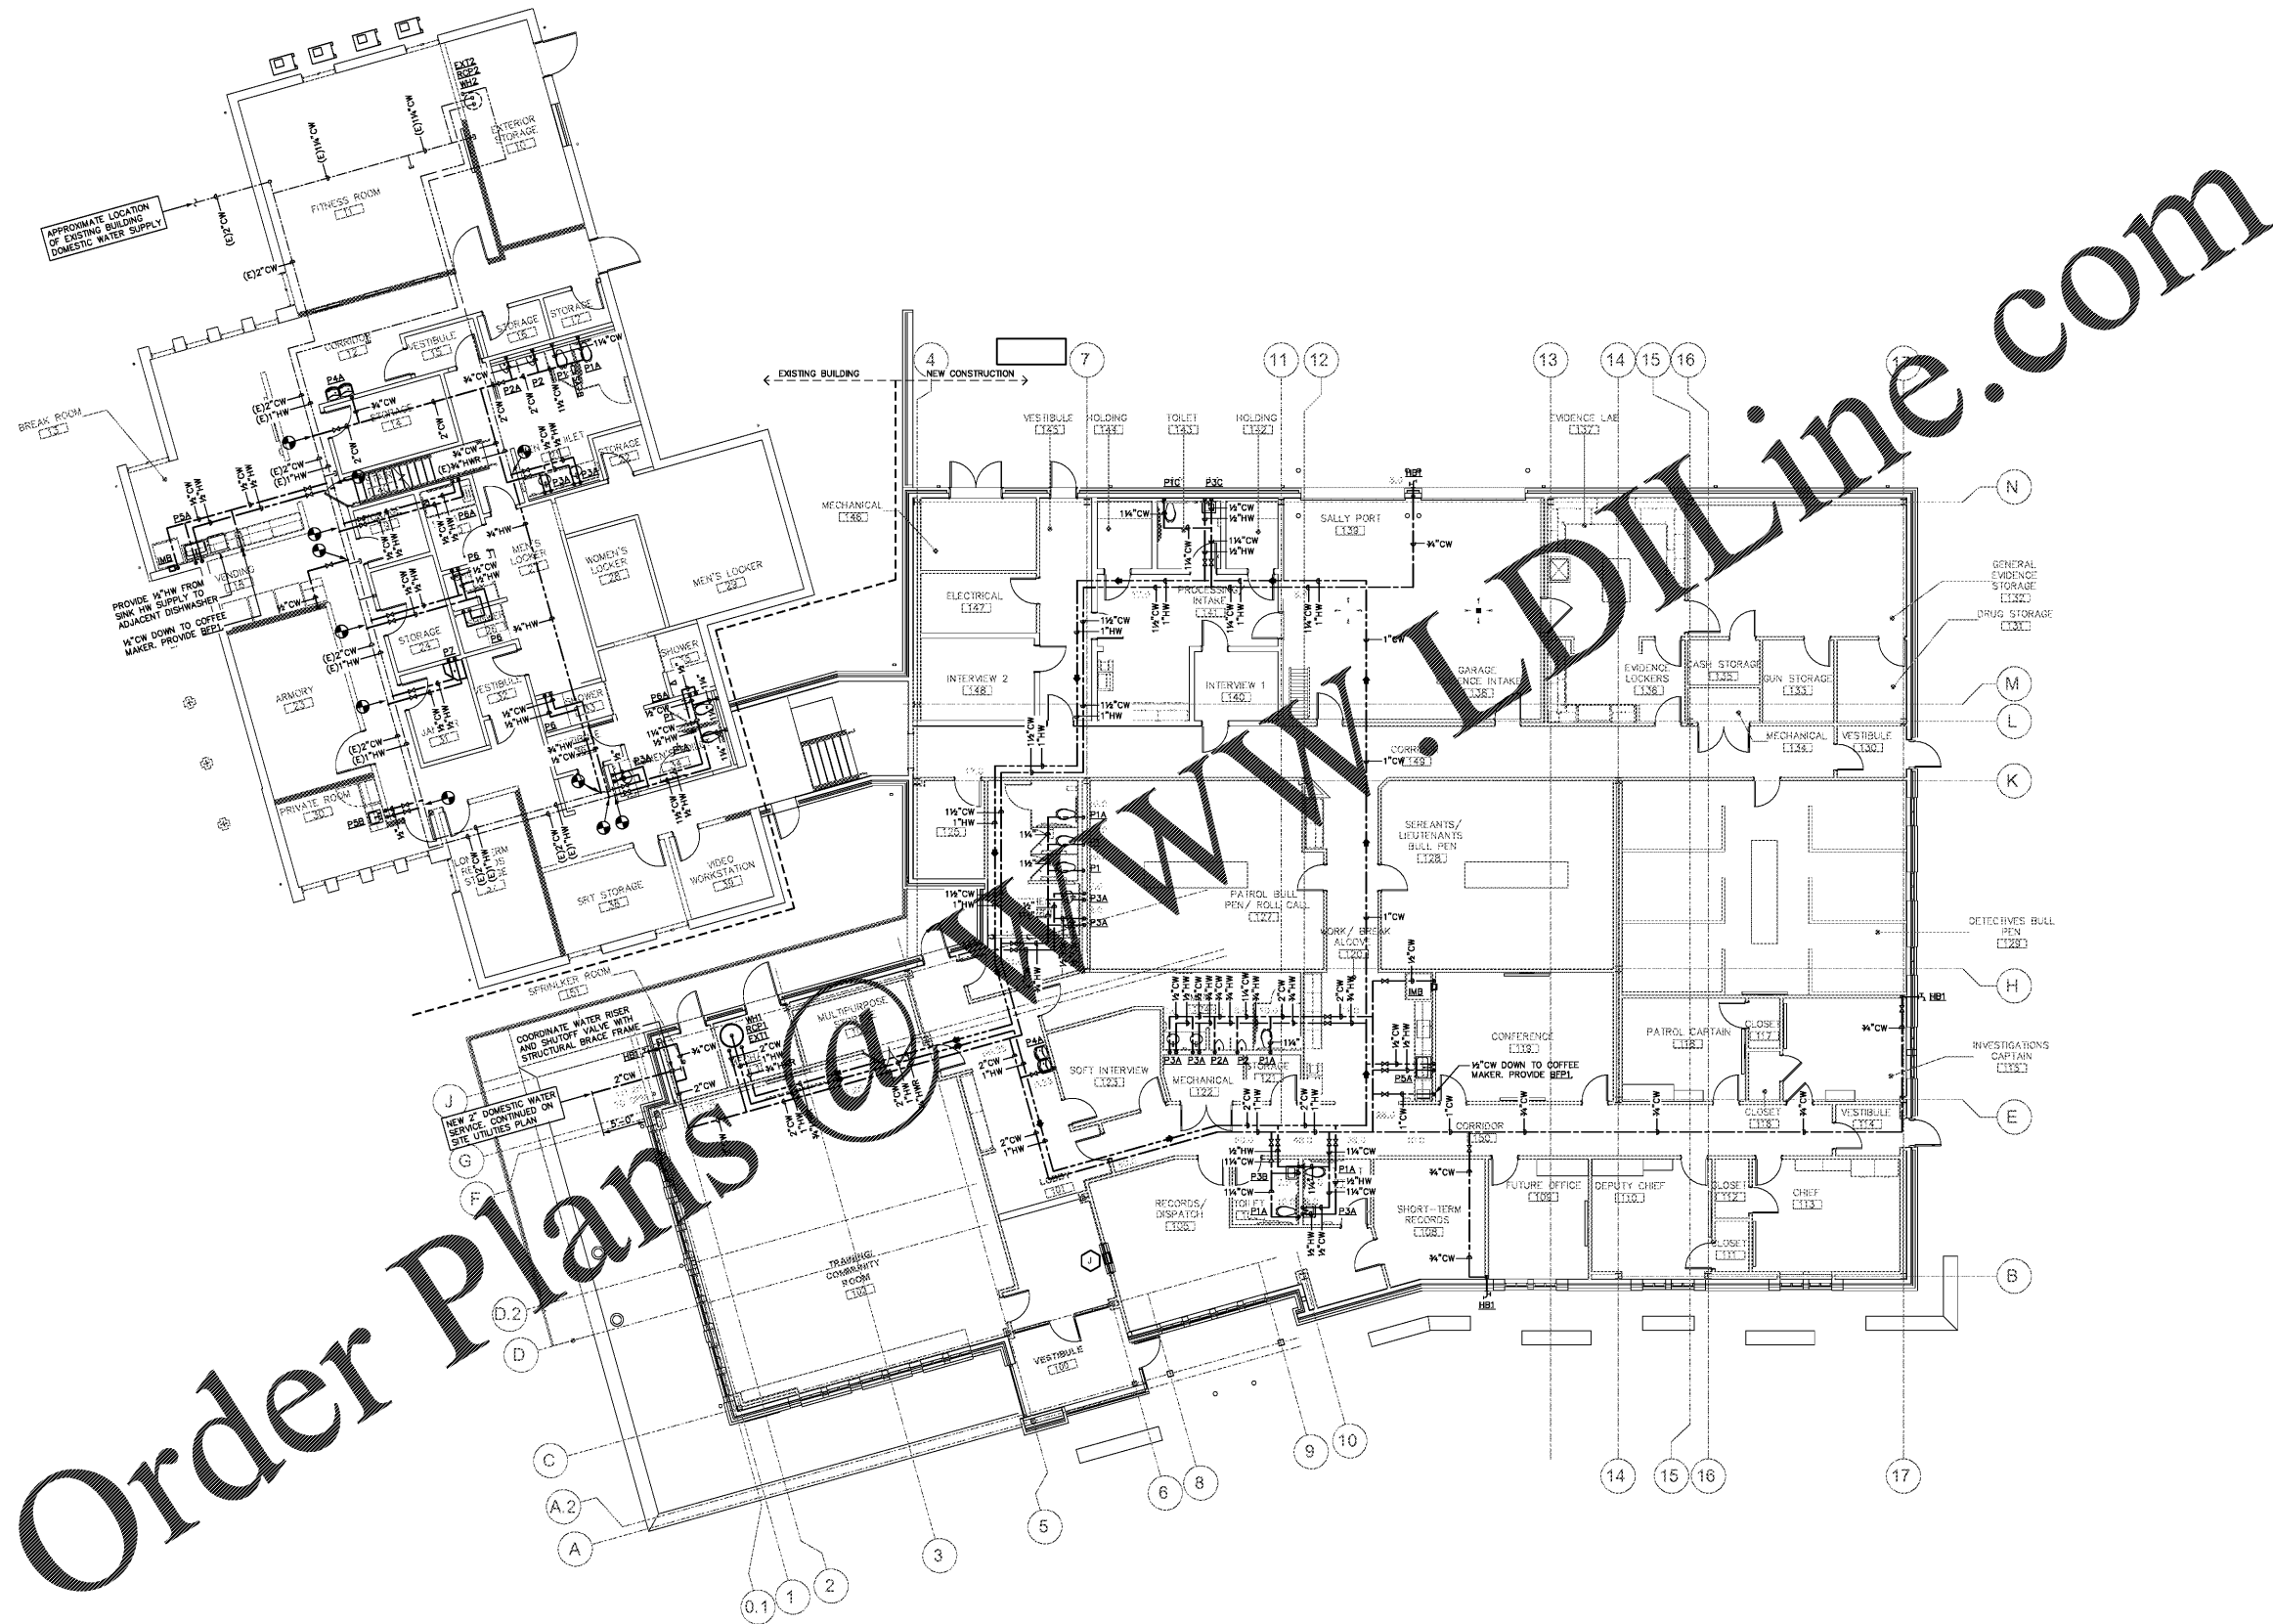

Order Plans @

1 WATER SUPPLY FLOOR PLAN - PLUMBING
1/8" = 1'-0"