

RENOVATION AND  
ADDITION FOR  
**ABERDEEN  
POLICE  
DEPARTMENT**



**ELECTRICAL  
DEMOLITION PLAN**

DATE: 10/25/2019  
PROJECT NO: 18062


REVISIONS

NO.	DATE	DESCRIPTION

THIS DRAWING IS THE PROPERTY OF ADW ARCHITECTS, P.A. AND SHALL NOT BE REPRODUCED OR COPIED IN WHOLE OR PART. IT SHALL NOT BE USED ON ANY OTHER PROJECT OR GIVEN TO ANY OTHER COMPANY OR AGENCY WITHOUT THE CONSENT OF ADW ARCHITECTS, P.A.

SHEET NUMBER

**E100**

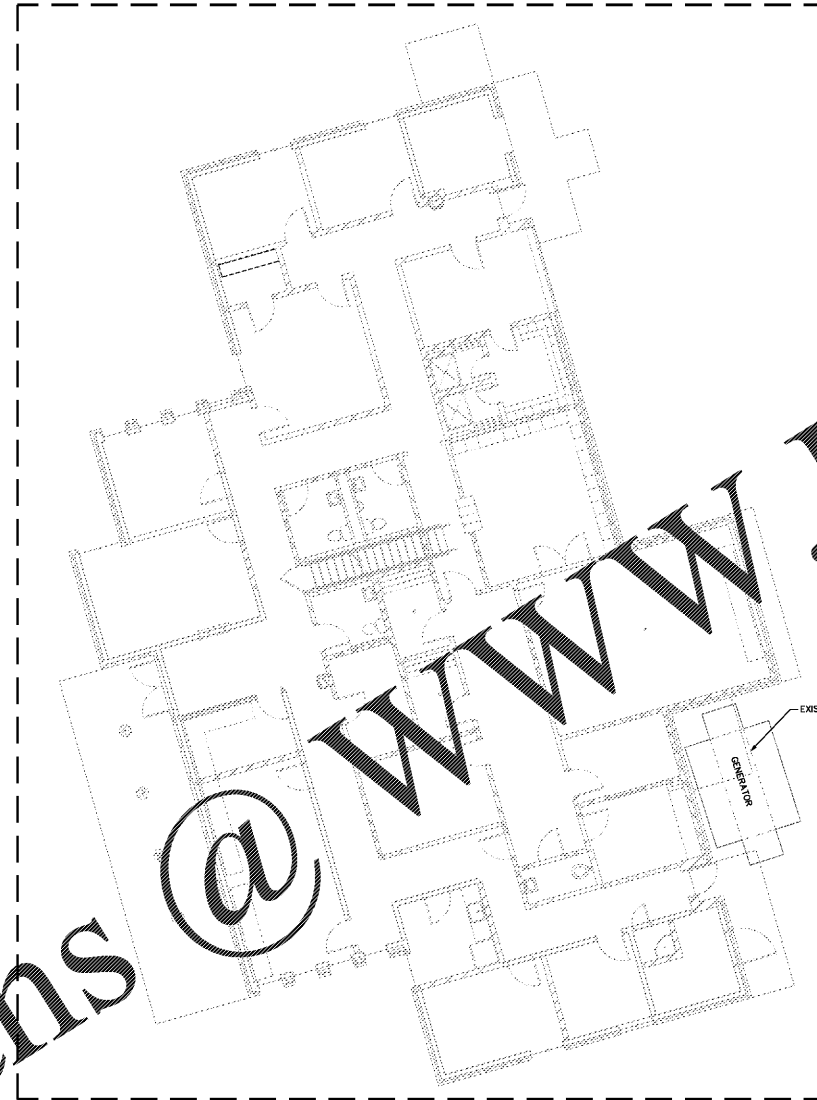

**DEMOLITION NOTES:**

1. ELECTRICAL CONTRACTOR SHALL REMOVE ALL EXISTING ELECTRICAL FIXTURES AND ASSOCIATED DEVICES WITHIN THE INDICATED PROJECT BOUNDARY, INCLUDING BUT NOT LIMITED TO RECEPTACLES, ASSOCIATED WIRING, CIRCUIT BOXES, CONTROLS AND ASSOCIATED CONTROL WIRING.
2. CONTRACTOR SHALL FIELD VERIFY EXISTING CONDITIONS PRIOR TO DEMOLITION.
3. CONTRACTOR SHALL REMOVE CIRCUITS BACK TO SERVICE WHERE NOT REUSED. LABEL AND UPDATE PANEL SCHEDULES ACCORDINGLY. ALL SPARE BREAKERS SHALL BE LEFT IN THE "OFF" POSITION.

① **ELECTRICAL DEMOLITION PLAN**  
1/8" = 1'-0"

Order Plans @ [www.lawline.com](http://www.lawline.com)