


RENOVATION AND
ADDITION FOR
**ABERDEEN
POLICE
DEPARTMENT**

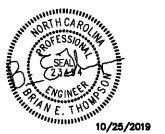

ROOF
POWER PLAN -
NEW CONSTRUCTION


DATE: 10/25/2019
PROJECT NO: 18062

REVISIONS
NO. DATE DESCRIPTION

THIS DRAWING IS THE PROPERTY OF ADW ARCHITECTS, P.A. AND SHALL NOT BE REPRODUCED OR COPIED IN WHOLE OR PART. IT SHALL NOT BE USED ON ANY OTHER PROJECT OR GIVEN TO ANY OTHER COMPANY OR AGENCY WITHOUT THE CONSENT OF ADW ARCHITECTS, P.A.

SHEET NUMBER

E203

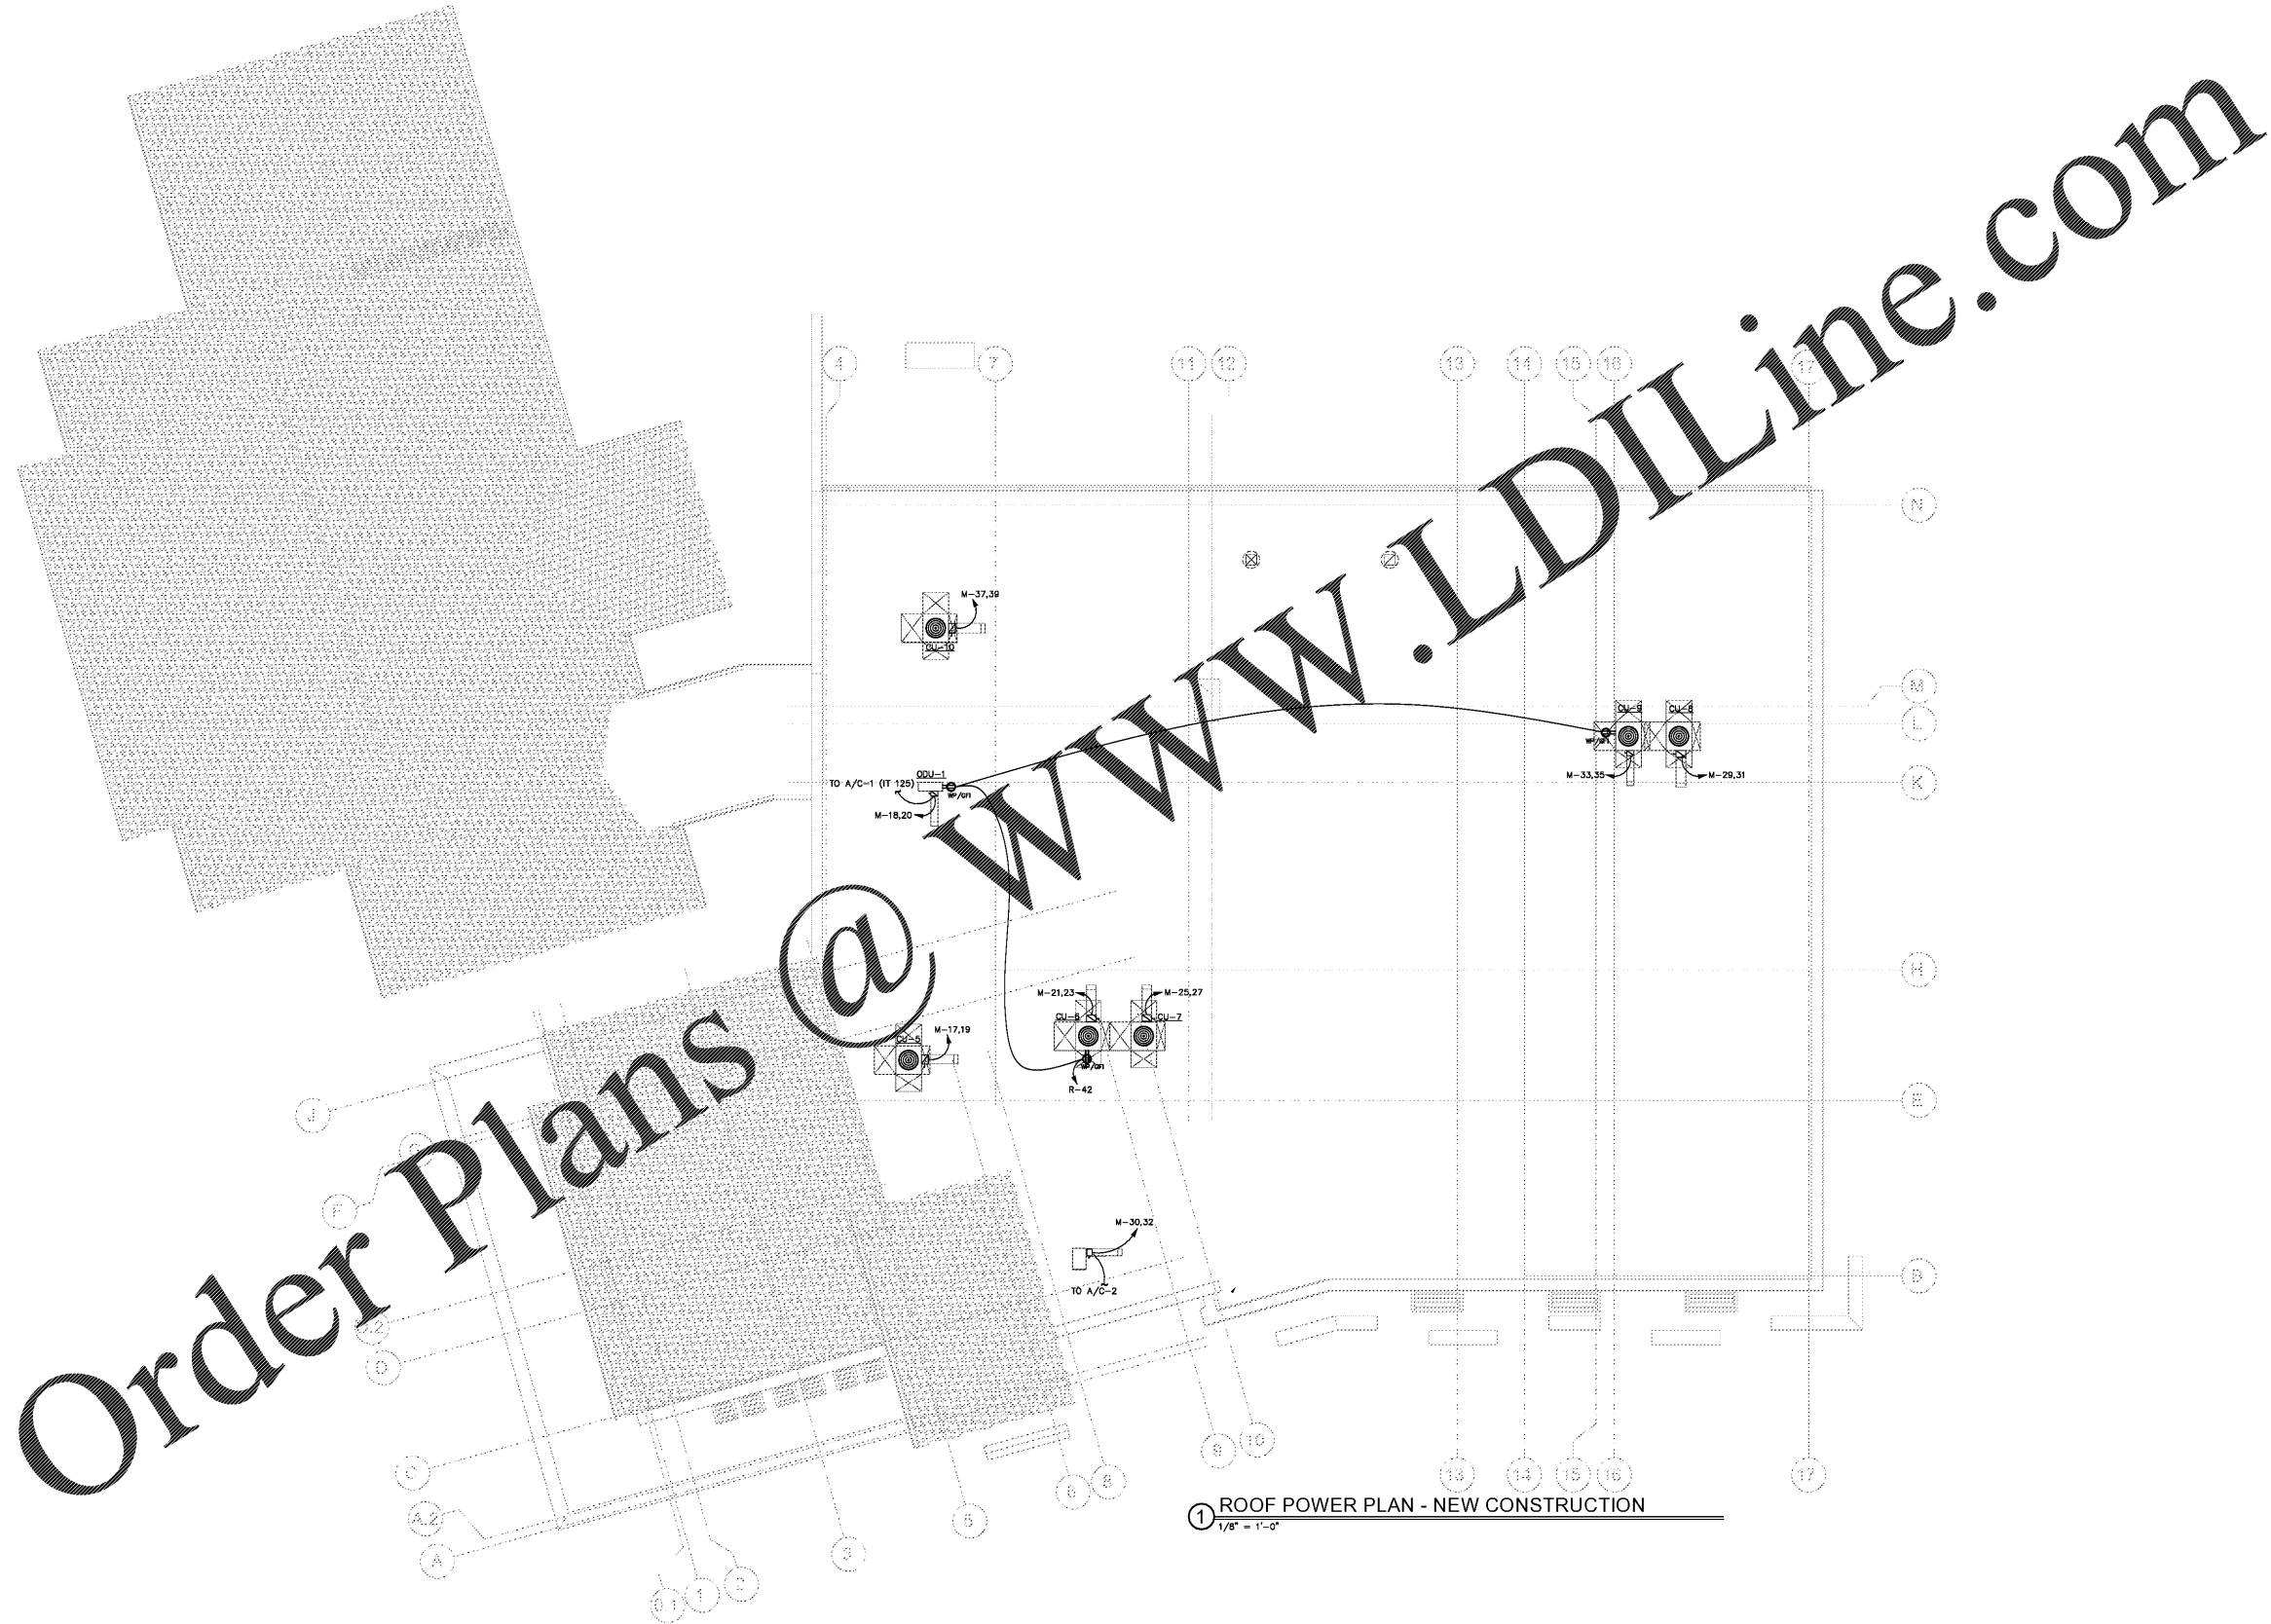

1 ROOF POWER PLAN - NEW CONSTRUCTION
1/8" = 1'-0"

Order Plans @