


**SITE LIGHTING PLAN GENERAL NOTES**

1. CONTRACTOR TO PROVIDE AND INSTALL ALL CONDUIT, WIRE AND DEVICES REQUIRED FOR MONUMENT SIGN. VERIFY LOCATION AND REQUIREMENTS WITH SIGN MANUFACTURER PRIOR TO ROUGH-IN.
2. PROVIDE ALL GROUNDING FOR MONUMENT SIGN PER MANUFACTURER'S AND LOCAL CODE REQUIREMENTS.
3. REFERENCE PHOTOMETRIC SITE LIGHTING PLAN FOR THE FOLLOWING INFORMATION:
  - 3.1. POLE SPECIFICATIONS
  - 3.2. LIGHTING FIXTURE MOUNTING HEIGHT
  - 3.3. LIGHTING FIXTURE SPECIFICATIONS
  - 3.4. LIGHTING FIXTURE DESIGNATIONS
4. REFER TO SHEET E1 FOR BUILDING MOUNTED LIGHT FIXTURE LOCATIONS AND DESIGNATIONS.

**Ⓢ SITE LIGHTING PLAN KEYNOTES**

1. REFERENCE SHEET E5 FOR CONTACTOR DIAGRAM AND PANELBOARD SCHEDULES.

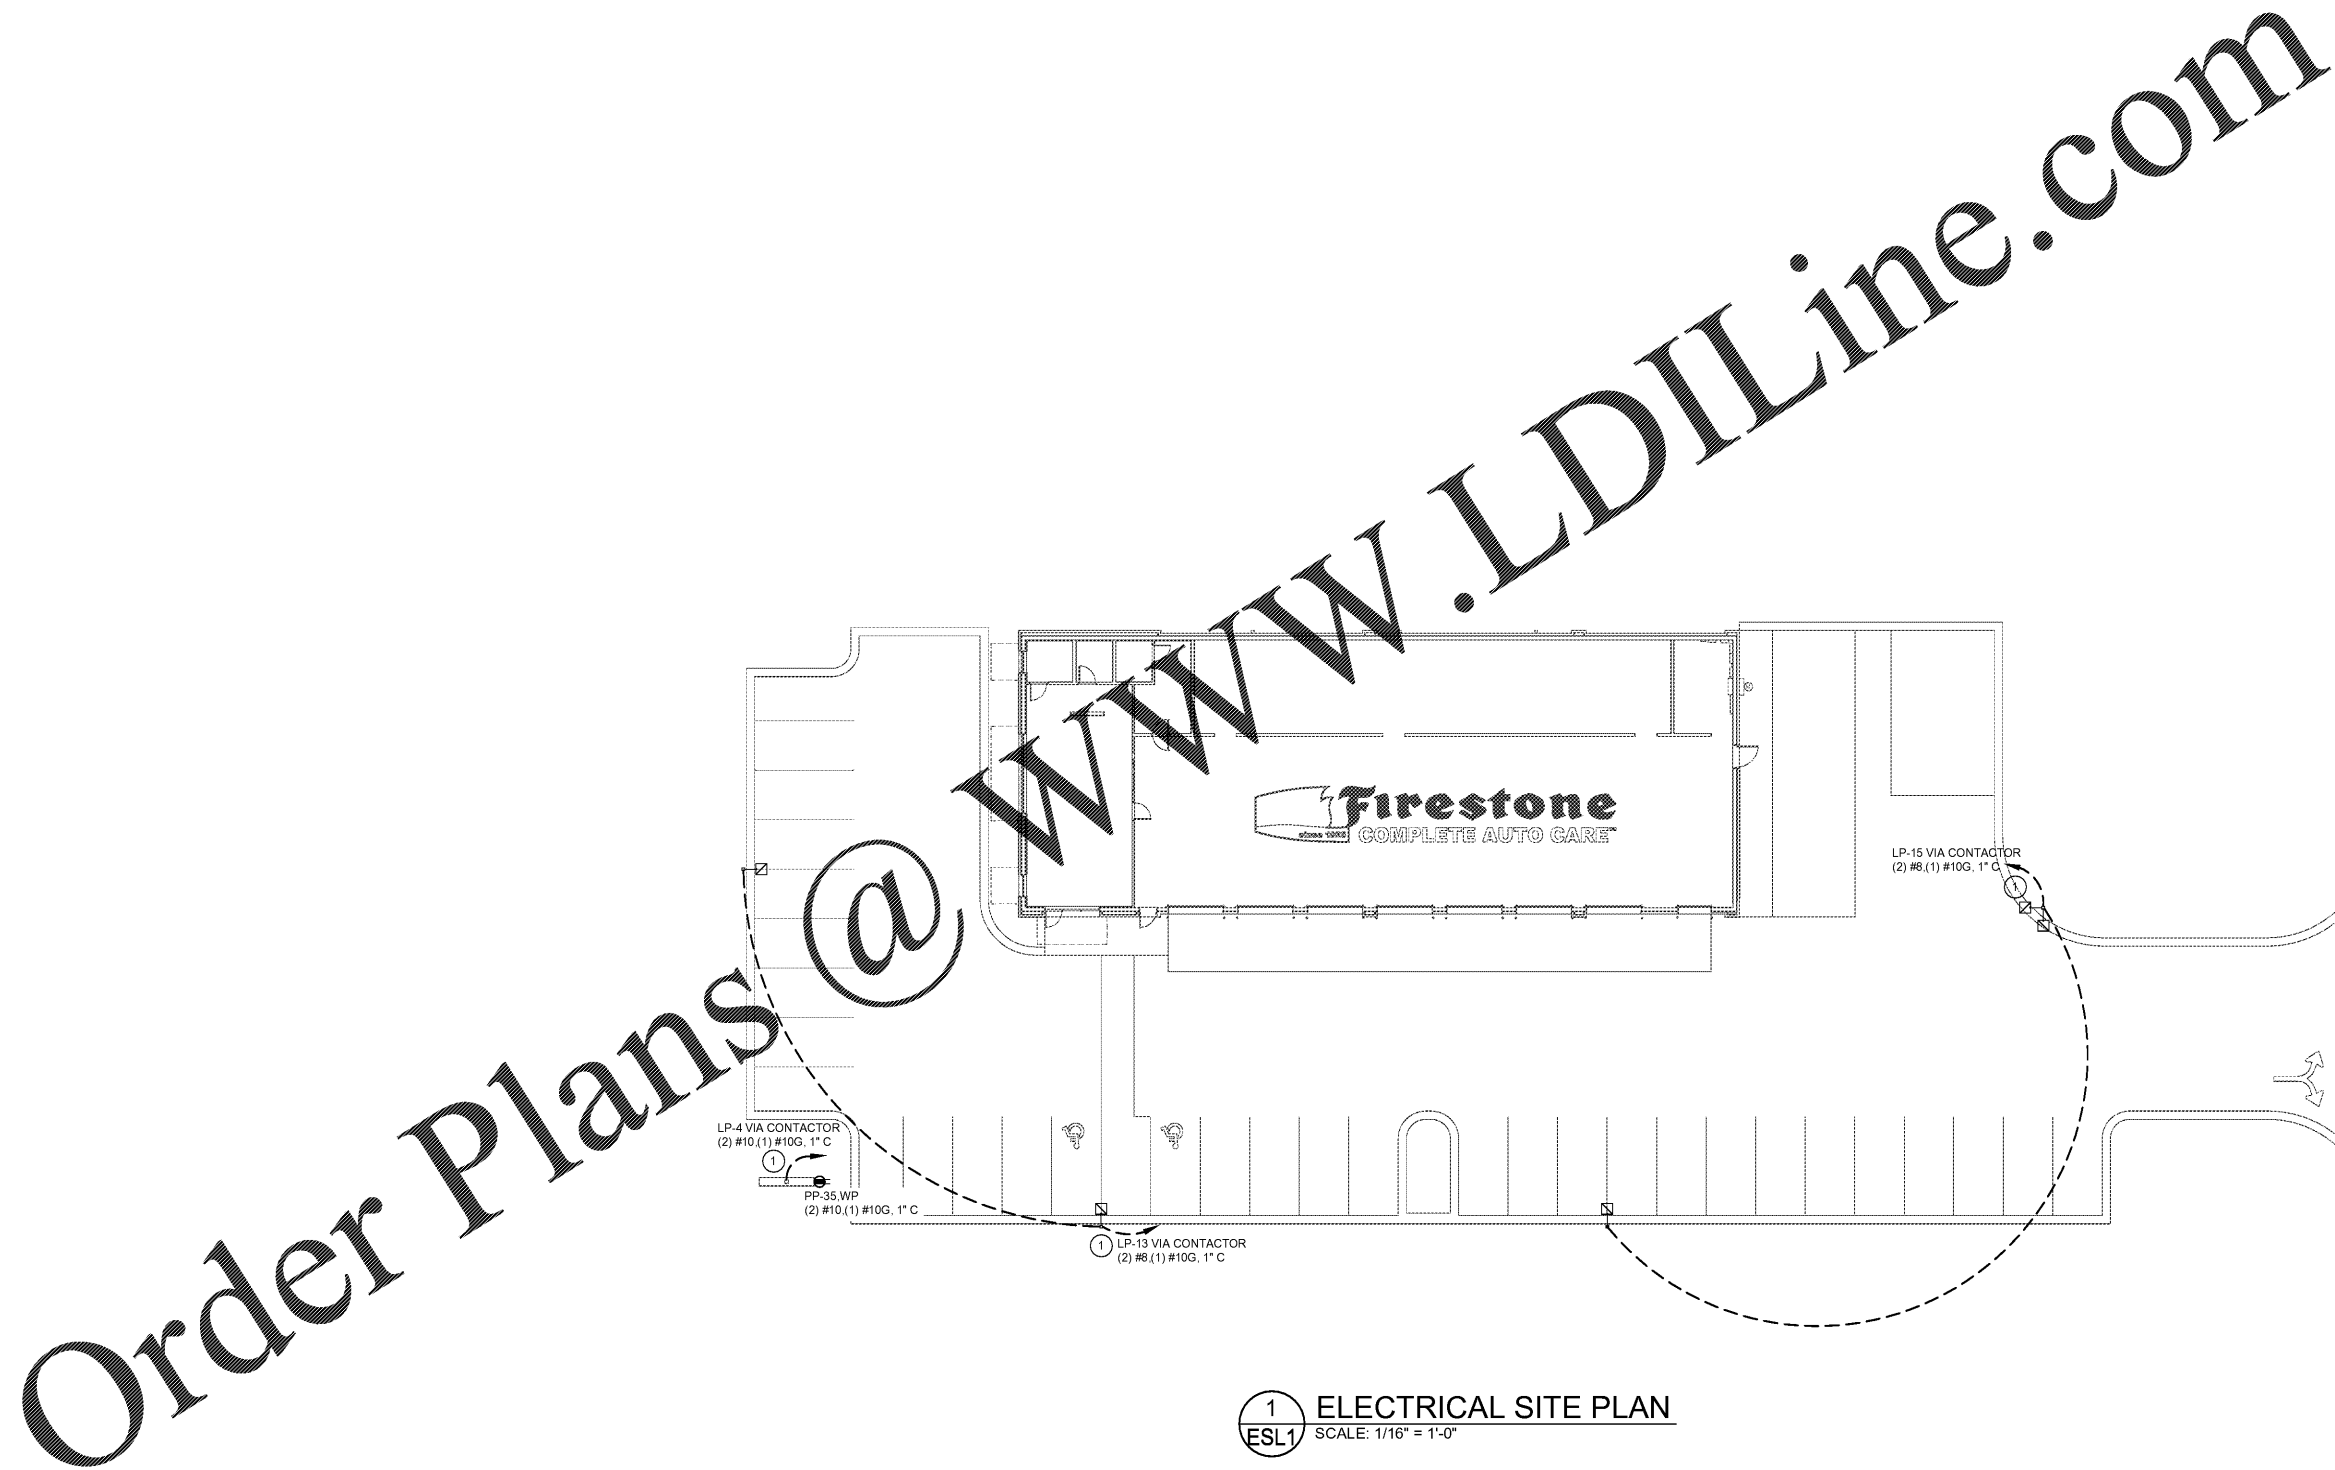


**1 ELECTRICAL SITE PLAN**  
SCALE: 1/16" = 1'-0"

Order Plans @ [WWW.LDILine.com](http://WWW.LDILine.com)



STATEMENT OF WORK  
THIS DRAWING WAS PREPARED FOR USE ON A SPECIFIC SITE AT SUMMERVILLE, SC. CONTRACTOR SHALL VERIFY ALL DIMENSIONS AND CONDITIONS PRIOR TO CONSTRUCTION. THIS DRAWING IS NOT TO BE USED FOR ANY OTHER PROJECTS OR PURPOSES WITHOUT THE WRITTEN PERMISSION OF ACERTUS CONSULTING GROUP, LLC. REPRODUCTION OF THIS DRAWING FOR ANY OTHER PROJECT OR PURPOSE IS STRICTLY PROHIBITED AND MAY BE CONSIDERED A VIOLATION OF THE LAW.

**NEW FCAC STORE**  
2020 ER  
1762 STATE RD  
SUMMERVILLE, SC

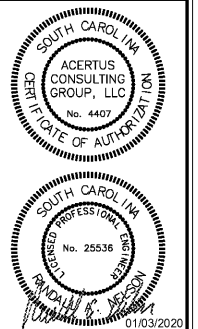

ISSUE BLOCK	
Δ	01/06/20 REV #1

PROPERTY NO.: 317910  
6 DIGIT NO.: 798862  
4 DIGIT NO.: 013K  
AOR PROJECT NUMBER: 1955867  
TO PERMIT: DATE: 12-20-19  
TO BID: DATE: ##-##-##

SHEET TITLE:  
**SITE LIGHTING PLAN**

SHEET NUMBER:  
**ESL1**