

Hendrick

1201 Peachtree Street, NE  
400 Colony Square  
Suite 1900  
Atlanta, GA 30361


T: 404.2619383  
F: 404.2409398  
www.hendrickinc.com



No.	Date	Description
1	01/08/2020	ISSUED/RELEASED FOR CONSTRUCTION

Project Name  
**Franklin Street**  
  
FRANKLIN STREET  
3384 PEACHTREE ROAD  
NE, SUITE 650  
ATLANTA, GA 30326  
  
ISSUE  
ISSUED/RELEASED FOR CONSTRUCTION  
  
ELECTRICAL PLAN

RS	This drawing and all reproductions are property of Hendrick, Inc. and may be used or reproduced only with the written permission of Hendrick, Inc.
Drawn	
KP	
Checked	
As Indicated	
Date	01/08/2020
Project No.	142-001-01
Drawing Number	E-1.6

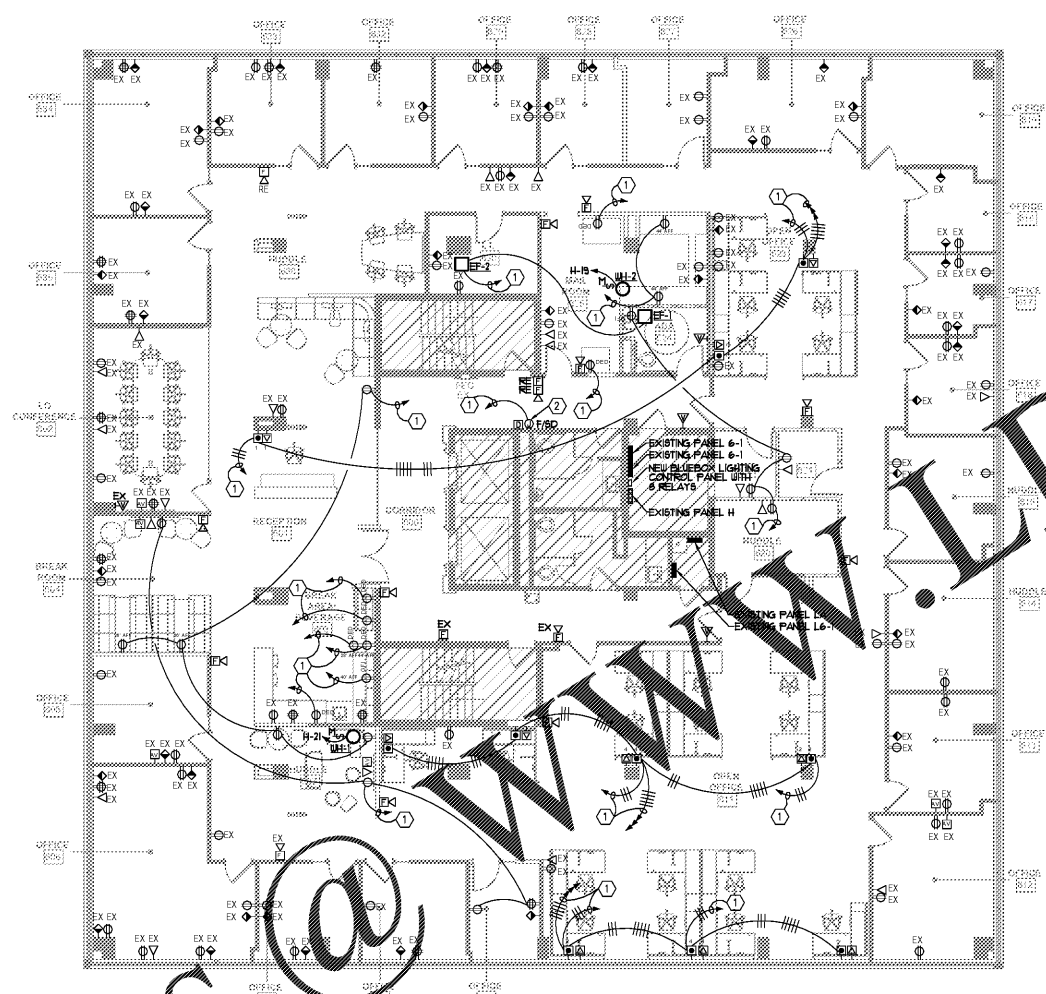

**ELECTRICAL PLAN**  
E-1.6 1/8" = 1'-0"

- GENERAL NOTES**  
APPLY THIS SHEET ONLY
- REFER TO DRAWING E-0.0 FOR SYMBOLS LEGEND.
  - ALL DEVICES SHALL BE NEW UNLESS OTHERWISE NOTED. "EX" ADJACENT TO A DEVICE INDICATES A DEVICE THAT IS EXISTING TO REMAIN. "RE" ADJACENT TO A DEVICE INDICATES THE NEW LOCATION OF AN EXISTING DEVICE. REFER TO ARCHITECTURAL DRAWINGS FOR EXACT LOCATION AND MOUNTING HEIGHTS OF ALL DEVICES.
  - COORDINATE LOCATION AND REQUIREMENTS OF ALL DEVICES, CONDUITS AND SUB-UPS FOR CONNECTION OF ALL EQUIPMENT WITH EQUIPMENT SUPPLIER/INSTALLER AND ARCHITECT. PROVIDE ALL REQUIRED CONNECTIONS.
  - HATCHING INDICATES AREA NOT IN SCOPE.
  - VERIFY ELECTRICAL REQUIREMENTS & RECEPTACLE NEMA TYPES FOR EQUIPMENT WITH EQUIPMENT SUPPLIER PRIOR TO INSTALLATION.
  - PROVIDE PULLSTRINGS IN ALL EMPTY CONDUITS.
  - COORDINATE ALL THROUGH FLOOR STUB-UP LOCATIONS WITH STRUCTURE AND ARCHITECT. ALL THROUGH FLOOR PENETRATIONS SHALL BE FIRE SEALED AS REQUIRED.
  - COORDINATE ALL ABOVE CEILING JUNCTION BOX LOCATIONS WITH INTERIOR DESIGNER PRIOR TO INSTALLATION.
  - SEE ARCHITECTURAL DRAWINGS FOR ALL MOUNTING HEIGHTS.
  - PROVIDE HANDLE TIES FOR ALL MULTI-WIRE CIRCUITS SHARING A NEUTRAL.
- LEGEND NOTES**  
APPLY THIS SHEET ONLY
- ROUTE TO SPARE 20A, 1P CIRCUIT BREAKER(S) MADE AVAILABLE DURING RENOVATION IN 208/120V PANELS "6-1", "6-2", "LA", AND "L5-2". IF NO SPARES ARE AVAILABLE, PROVIDE AND INSTALL NEW BREAKER(S) AS REQUIRED. PROVIDE HANDLE-TIES FOR ALL MULTI-WIRE CIRCUITS SHARING NEUTRAL CONDUCTORS.
  - PROVIDE JUNCTION BOX FOR 120V CONNECTION TO DUCT MOUNTED SMOKE DETECTOR. COORDINATE EXACT LOCATION WITH DIVISION 23.

Order Plans @

**BW & A**  
Barrett, Woodruff & Associates, Inc.  
3495 Holcomb Bridge Road  
Norcross, GA 30092  
Phone (770) 810-8300  
  
PROJECT NORTH

This drawing is copyrighted. It may not be reproduced, stored in a retrieval system, or used in any other form without the written permission of Hendrick, Inc.