



KEYNOTES


- 16.828 ELECTRICAL SEAL-OFFS NOT SHOWN. PROVIDE SEAL-OFFS FOR ALL CONDUITS. ALL SEAL-OFFS AND JUNCTION BOXES TO BE 1" MINIMUM ABOVE PENETRATIONS. ELECTRICAL CONDUITS SHALL NOT BE ROUTED OVER THE MANWAY COVER. FLEXIBLE CONNECTORS FOR THE ELECTRICAL CONNECTIONS FORM EXPLOSION PROOF JUNCTION BOX TO THE SUBMERGED PUMP WILL NOT BE ACCEPTED. ALL CONNECTIONS MUST BE WITH RIGID CONDUIT.
- 16.844 1" GRC TO SITE MONITORING WIRING CABINET IN SERVICE BUILDING.

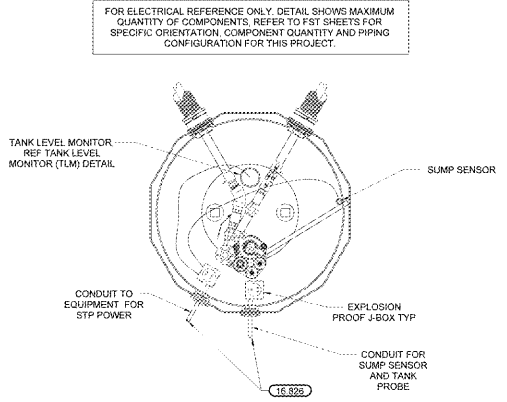


4 STP SUMP SECTION (TYPICAL)
NTS

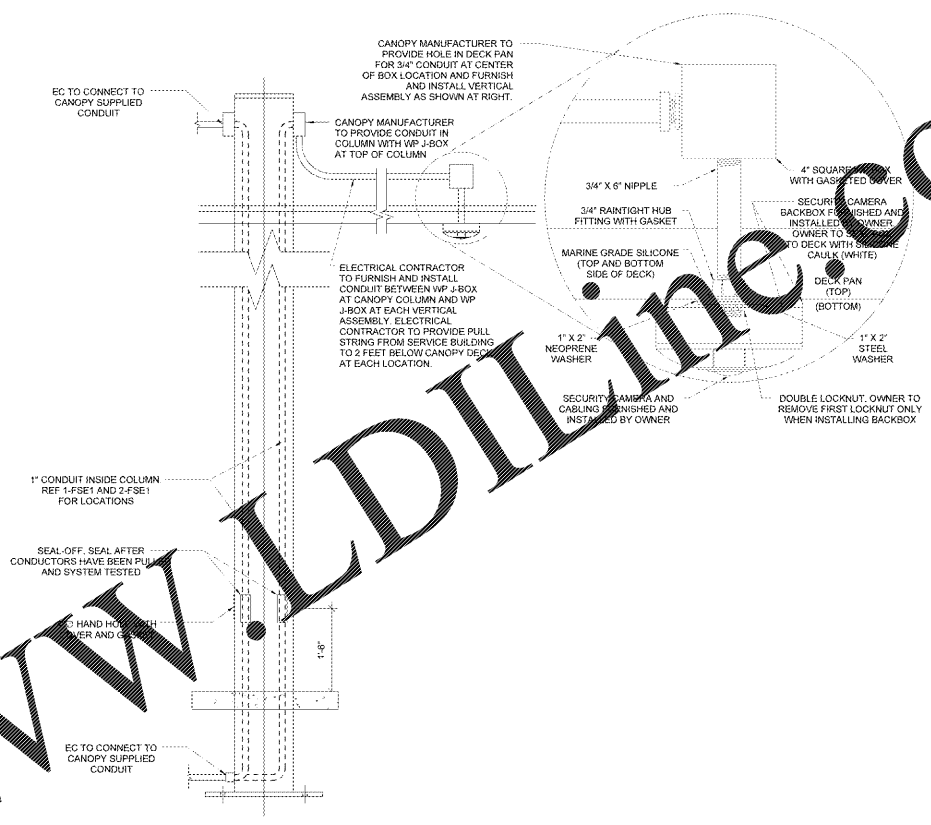

3 CANOPY COLUMN DETAIL (TYPICAL)
NTS

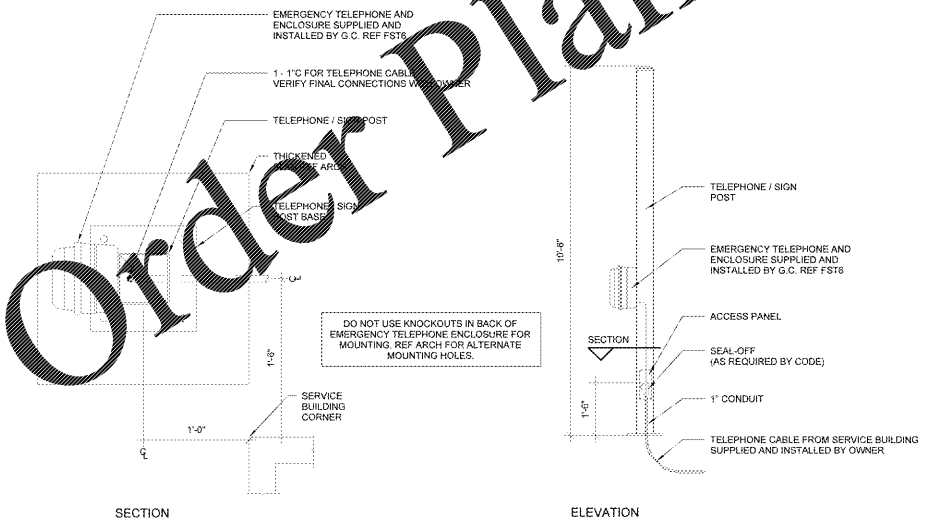

2 TELEPHONE AND SIGN POST PLAN
NTS

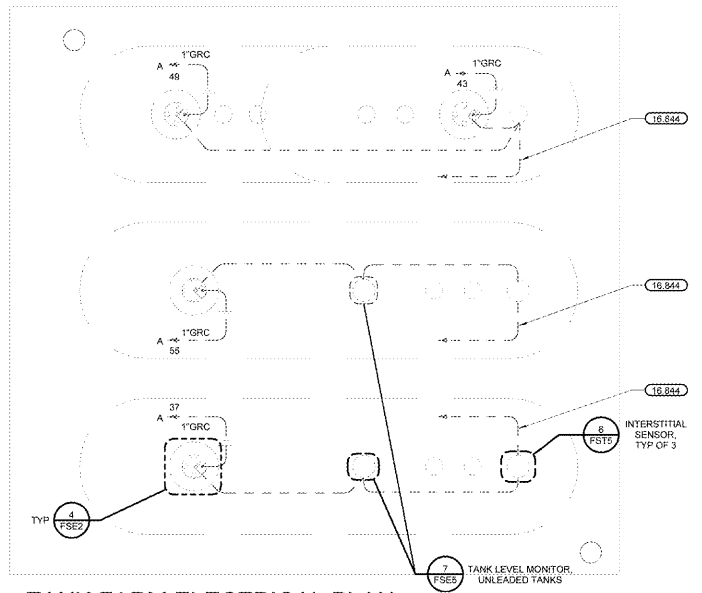

1 TANK FARM ELECTRICAL PLAN
3/32" = 1'-0"

TANK FARM PLAN FOR REPRESENTATIVE PURPOSES ONLY. FUELING CONTRACTOR SHALL COORDINATE ALL CONDUITS AND CONDUCTORS. REFER TO FST SHEETS.

STIPULATION FOR REUSE:
THIS DOCUMENT IS THE PROPERTY OF SAMS CLUBS. IT IS TO BE USED ONLY FOR THE PROJECT AND SITE SPECIFICALLY IDENTIFIED HEREIN. IT IS NOT TO BE REPRODUCED, COPIED, OR TRANSMITTED IN ANY FORM OR BY ANY MEANS, ELECTRONIC OR MECHANICAL, INCLUDING PHOTOCOPYING, RECORDING, OR BY ANY INFORMATION STORAGE AND RETRIEVAL SYSTEM, WITHOUT THE WRITTEN PERMISSION OF SAMS CLUBS. ANY UNAUTHORIZED REUSE OF THIS DOCUMENT IS STRICTLY PROHIBITED.

CONSULTANTS
Randall C. Hulse
REGISTERED PROFESSIONAL ENGINEER
STATE OF NORTH CAROLINA
LICENSE NO. 12078
EXPIRES 12/31/2024

Sams CLUBS
CHARLOTTE, NC
CLUB#: 6540
JOB NUMBER: 24278 | PROTO: SWS-102

ISSUE BLOCK

CHECKED BY: SAG
DRAWN BY: JUN
FILE NAME: FSE2
PROTO CYCLE: 102516
DOCUMENT DATE: 09/20/19

NOT FOR CONSTRUCTION

TANK ELECTRICAL PLANS AND ELECTRICAL DETAILS

SHEET: FSE2