



3 COMMUNICATION ONE-LINE DIAGRAM
NTS

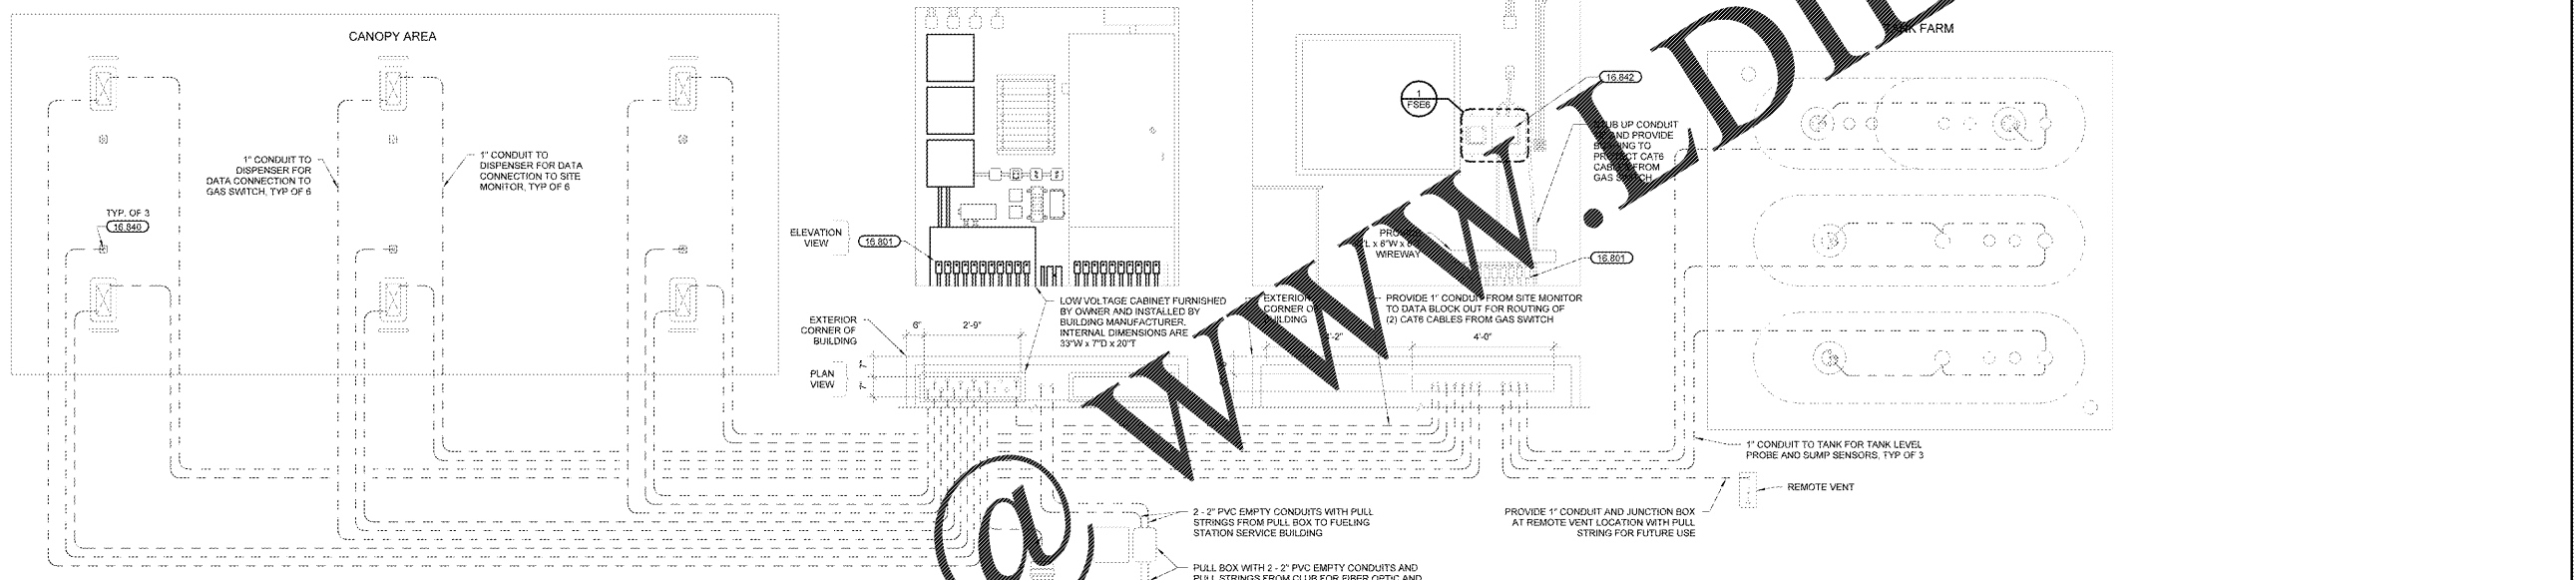

2 DATA ONE-LINE DIAGRAM
NTS

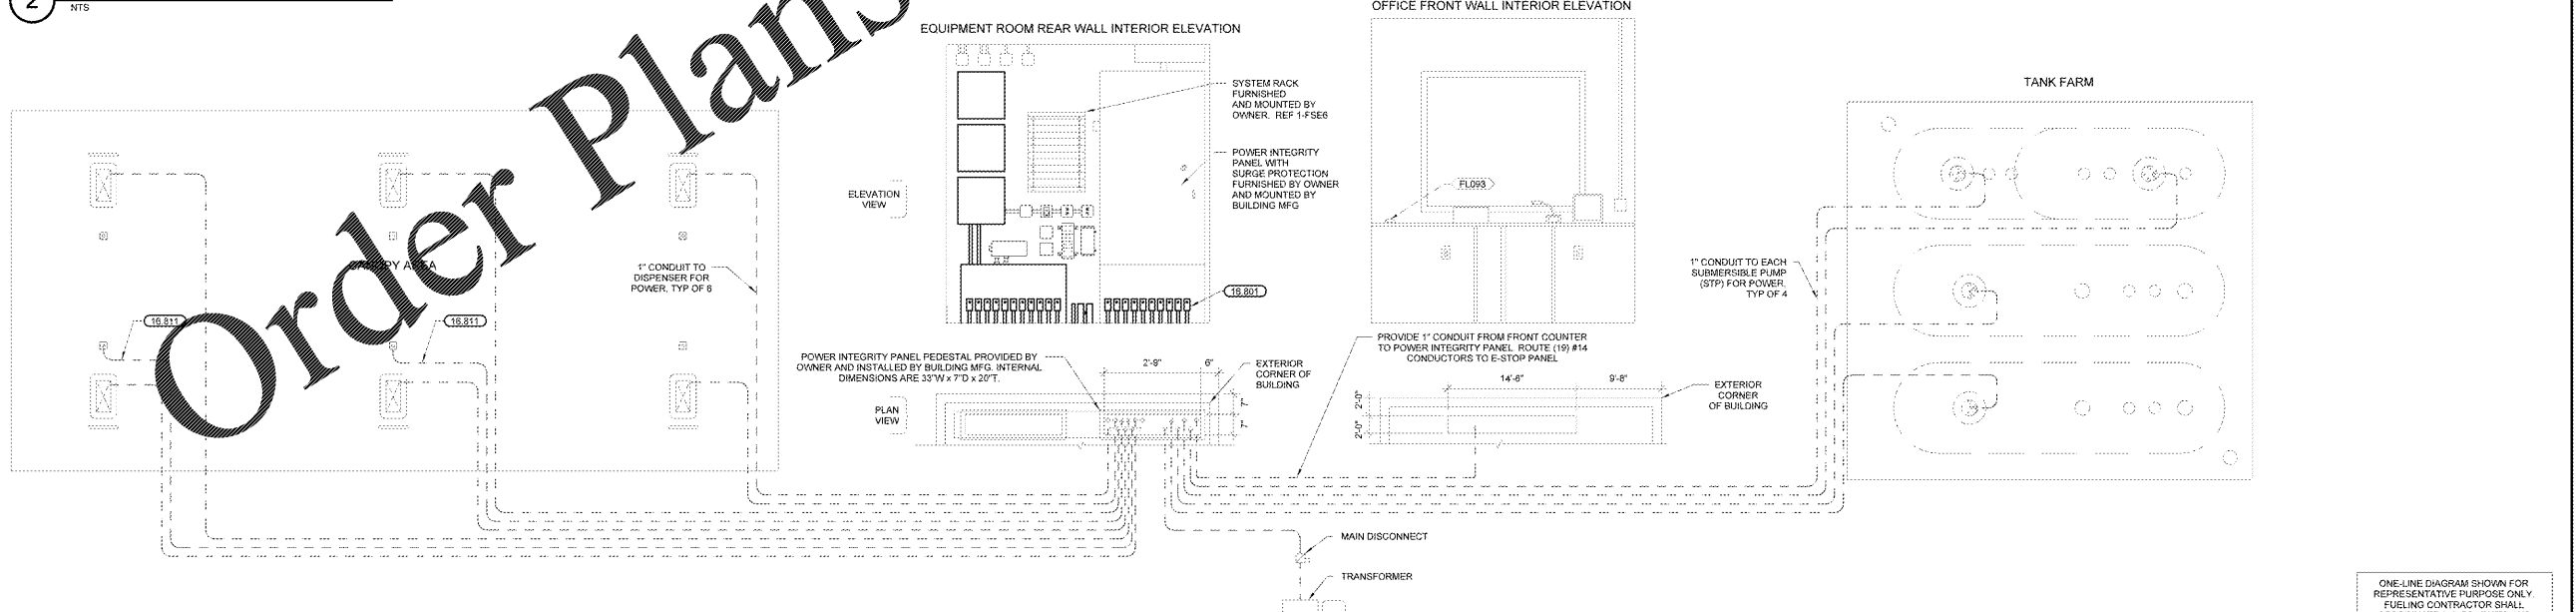

1 POWER ONE-LINE DIAGRAM
NTS

KEYNOTES	
18.801	SEAL-OFF ALL CONDUIT THAT ENTER OR PASS THROUGH A CLASSIFIED AREA. REF 2-FSES 1.
18.811	1 - 1" CONDUIT WITH SEAL-OFF INSIDE COLUMN BY CANOPY MANUFACTURER. REF TO CANOPY MANUFACTURER'S DRAWINGS FOR EXACT LOCATION OF COLUMN. SEAL AFTER CIRCUITS HAVE BEEN PULLED, TESTED, AND ARE FUNCTIONING PROPERLY.
18.840	PROVIDE 1" GRC FROM SECURITY CAMERA IN CANOPY DECK TO DATA CONDUIT WIRING CABINET WITH SEAL-OFFS AT EACH END. CONTRACTOR TO MAKE CONNECTION AT EACH COLUMN BASE AND CONTINUE CONDUIT FROM TOP OF COLUMN TO JUNCTION BOX AT DECK PAN SECURITY CAMERA. CABLING AND EQUIPMENT SUPPLIED AND INSTALLED BY OWNER. REF 1-FSE1 FOR EXACT CANOPY COLUMN LOCATIONS.
18.842	INSTALL SITE MONITOR PANEL FURNISHED BY OWNER. DIRECT CONNECT. PROVIDE ISOLATED GROUNDING CONDUCTOR PER MANUFACTURER'S RECOMMENDATION. ALL TERMINATIONS SHOULD BE INSTALLED PER RECOMMENDATION OF MANUFACTURER. REF 1-FSES.

ETIPLICATION FOR REUSE
THIS DOCUMENT IS THE PROPERTY OF SAMS CLUBS AND IS NOT TO BE REPRODUCED OR TRANSMITTED IN ANY FORM OR BY ANY MEANS, ELECTRONIC OR MECHANICAL, INCLUDING PHOTOCOPYING, RECORDING, OR BY ANY INFORMATION STORAGE AND RETRIEVAL SYSTEM. VIOLATION OF THIS NOTICE IS SUBJECT TO PROSECUTION.

CONSULTANTS
Randall C. Hbase
REGISTERED PROFESSIONAL ENGINEER
STATE OF NORTH CAROLINA
NO. 10001
EXPIRES 12/31/2024
PROJECT NO. 24278
SHEET NO. 102

Charlotte, NC
Sams Club
CLUB#: 6540
JOB NUMBER: 24278 | PHOTO: SAG-102

ISSUE BLOCK	

CHECKED BY:	SAG
DRAWN BY:	JUN
FILE NAME:	FSE4
PROTO CYCLE:	102516
DOCUMENT DATE:	09/20/19

NOT FOR CONSTRUCTION

SITE CONDUIT DIAGRAMS

ONE-LINE DIAGRAM SHOWN FOR REPRESENTATIVE PURPOSE ONLY. FUELING CONTRACTOR SHALL COORDINATE ALL CONDUITS AND CONDUCTORS.

SHEET: FSE4