

QTY.	SYMBOL	LAMP #	MFR. / CATALOG #	FIXTURE DESCRIPTION	FINISH	MOUNTING	REMARKS
15	A-1H A-3H A-3H	SUB-T IN	KOLINSING NORVIMHC-ELMIRAT	HOLDING WITH DIRECT LED CONNECT		RECESSED	PRIMARY
15	A-1	SUB-T IN	MODULE: MAXILITE RB1120W-L7	9" LED DOWNLIGHT	WHITE	RECESSED	
-	A-2	SUB-T IN	MODULE: MAXILITE RB1120W	6" LED EYE-BALL (ARMABLE)	WHITE	RECESSED	
4	B-4	SUB-T IN	MODULE: MAXILITE MLF220P301A10	24"x24" LED PANEL	WHITE	LAY-IN	
8	K-10	SUB-T IN	INDESSA-574-1LED19-8RZ-3500	WALL SCENCE (EXTERIOR)	BRONZE	SURFACE (WALL)	
-	P-4L	SUB-T IN	LAMBERT 815 AGS (20-24 SOCKET)	LARGE DECORATIVE PENDANT	MATTE WHITE/BRASS	PENDANT (CHAIN)	S.D.F. @ 8' F.A.F.F
-	P-5	SUB-T IN	ARKANSAS LIGHTING-420P-LED	LARGE DECORATIVE PENDANT	MATTE BLACK	PENDANT (CABLE)	S.D.F. @ 7' F.A.F.F


**GENERAL NOTES**

- HOLD DOWN CLIPS SHALL BE PROVIDED FOR ALL CEILING TILES IN THE VESTIBULES.
- SEE INTERIOR FINISH SCHEDULE FOR CEILING TILE.
- DO NOT SCREW THE CEILING GRID TO THE STAINLESS STEEL HOODS. USE DOUBLE-FACED TAPE.
- REFER TO ELECTRICAL AND/OR HVAC DRAWINGS FOR ADDITIONAL INFORMATION REGARDING ALL FIXTURES, DEVICES AND EQUIPMENT SHOWN ON THIS PLAN.
- VERIFY EXISTING MUSIC SYSTEM IN DINING ROOM. COORDINATE REQUIREMENTS WITH WENDY'S REP.
- VERIFY EXISTING WIFI SYSTEM. COORDINATE REQUIREMENTS WITH WENDY'S REP.

**LEGEND**

	FLUORESCENT LIGHTING FIXTURE		HANGING LIGHT FIXTURE
	NEW CEILING GRID AND ACOUSTICAL TILE		RECESSED OR WALL WASH CAN LIGHT FIXTURE
	(E) CEILING GRID AND NEW A.C.T. (T-2) DESIGNATED BY (E)		WALL MOUNTED LIGHT FIXTURE
	NEW WASHABLE SUSPENDED ACOUSTICAL CEILING TILE		LINEAR COMMUNITY FIXTURE
	EXIT LIGHT FIXTURE		PENDANT LIGHT FIXTURE
	X'-X' CEILING MOUNTED LIGHT TRACK		SUPPLY AIR DIFFUSER
ABBREVIATION LEGEND:			RETURN AIR DIFFUSER
(E) INDICATES EXISTING CEILING MOUNTED ITEMS.			CEILING RECESSED EMERGENCY FLOOD LIGHT
(R) INDICATES RELOCATED CEILING MOUNTED ITEMS.			EXTERIOR REMOTE EMERGENCY FLOOD LIGHT
(N) INDICATES NEW CEILING MOUNTED ITEMS.			CEILING SPEAKER

NOTE:  
ALL FIXTURES TO BE PROVIDED BY ELECTRICAL CONTRACTOR UNLESS OTHERWISE NOTED. ELECTRICAL CONTRACTOR TO VERIFY COLOR SCHEME BEFORE PLACING ORDER.

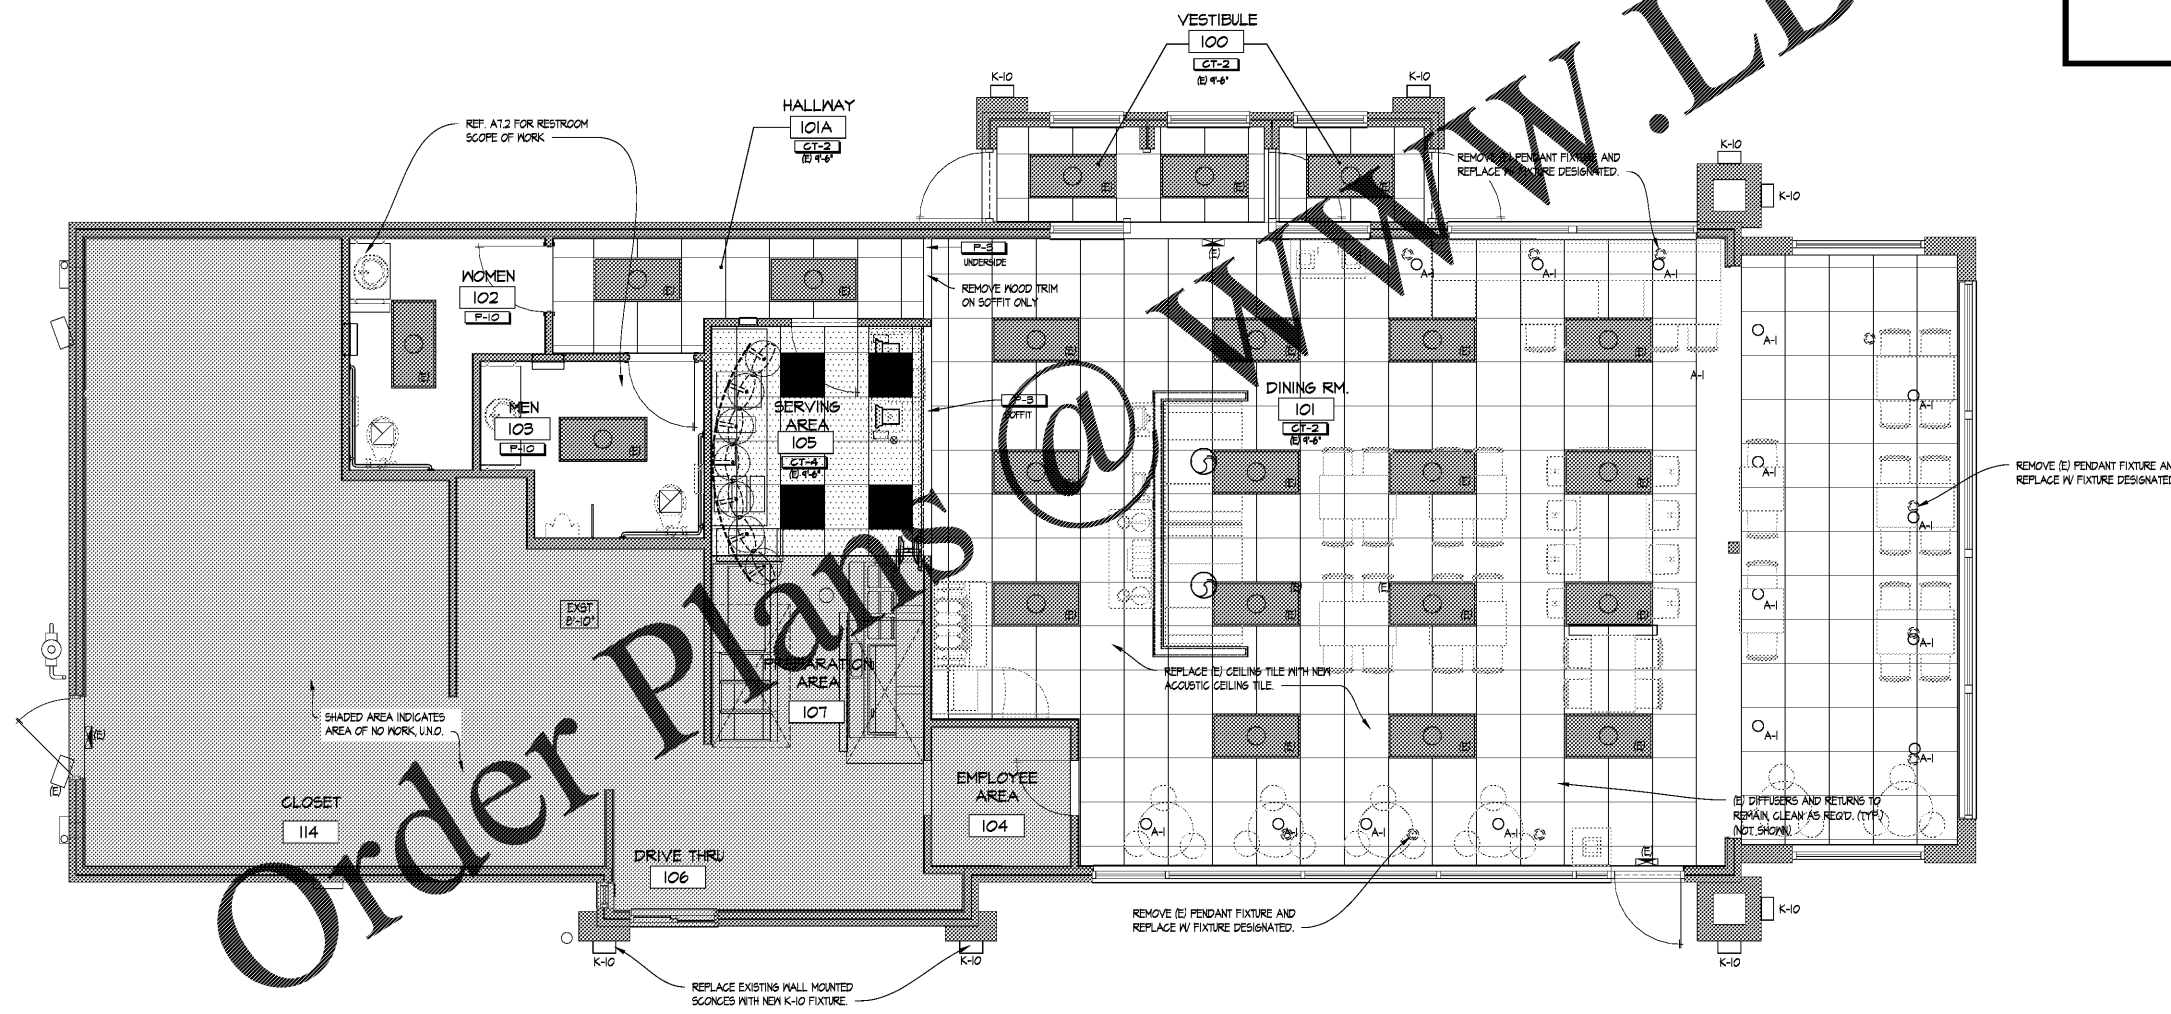

SITE NUMBER:	03302
BASE MODEL:	3076
ASSET TYPE:	FRANCHISE
CLASSIFICATION:	REFRESH LITE
OWNER:	TAR HEEL CAPITAL
BASE VERSION:	2016 JUL
UPGRADE CLASSIFICATION:	N/A
PROJECT YEAR:	2020
FURNITURE PACKAGE:	UM BRIGHT
DRAWING RELEASE:	FALL 2019

Project No. **19-133**

**snidesign**  
ARCHITECTS

Design +,  
Bardonia-Eastern Building  
1440 Bardonia Rd., Suite 300  
Louisville, Kentucky 40204  
(502) 454-9211 (502) 454-4311 (MO)

**Wendy's**  
1210 HIGHWAY 70 SOUTHWEST  
HICKORY, NC. 28602

REV.	DATE	DESCRIPTION

ISSUE DATE: 12/24/2019  
PROJECT NUMBER: 03302  
DRAWN BY: KEN BROWN  
CHECKED BY: KEN BROWN



1/6/2020 10:19  
REFLECTED CEILING PLAN

SHEET NUMBER  
**A1.2**

12/25/2019 9:14 PM, N:\Projects\2019-133 Wendy's Hickory NC\Drawings\Sheets\10\_3076\_A1\_2\_REFLECTED\_CEILING\_PLAN.DWG, Ken B.