

- GENERAL NOTES:
- REFER TO SHEET E0.1 FOR SYMBOLS, ABBREVIATIONS AND LEGEND.
 - EXIT SIGNS AND EMERGENCY LIGHT UNITS SHALL BE CIRCUITED AHEAD OF SWITCHING AND LIGHTING CONTROL DEVICES.



Seals



Project Name

**Affordable Suites of
Chattanooga, TN**
6046 Relocation Way, Chattanooga, TN

Issued For Construction

Issue Date: 12/17/2019

Revisions

Revision Date:

#	Revision	Date:

E2.5-Level 2 Reflected Ceiling Plan

Sheet Data:

Project #: Project Number

Drawn By: Author


Checked By: Checker

Sheet Title:

Level 2
Reflected
Ceiling Plan

Drawing Number:

E2.5

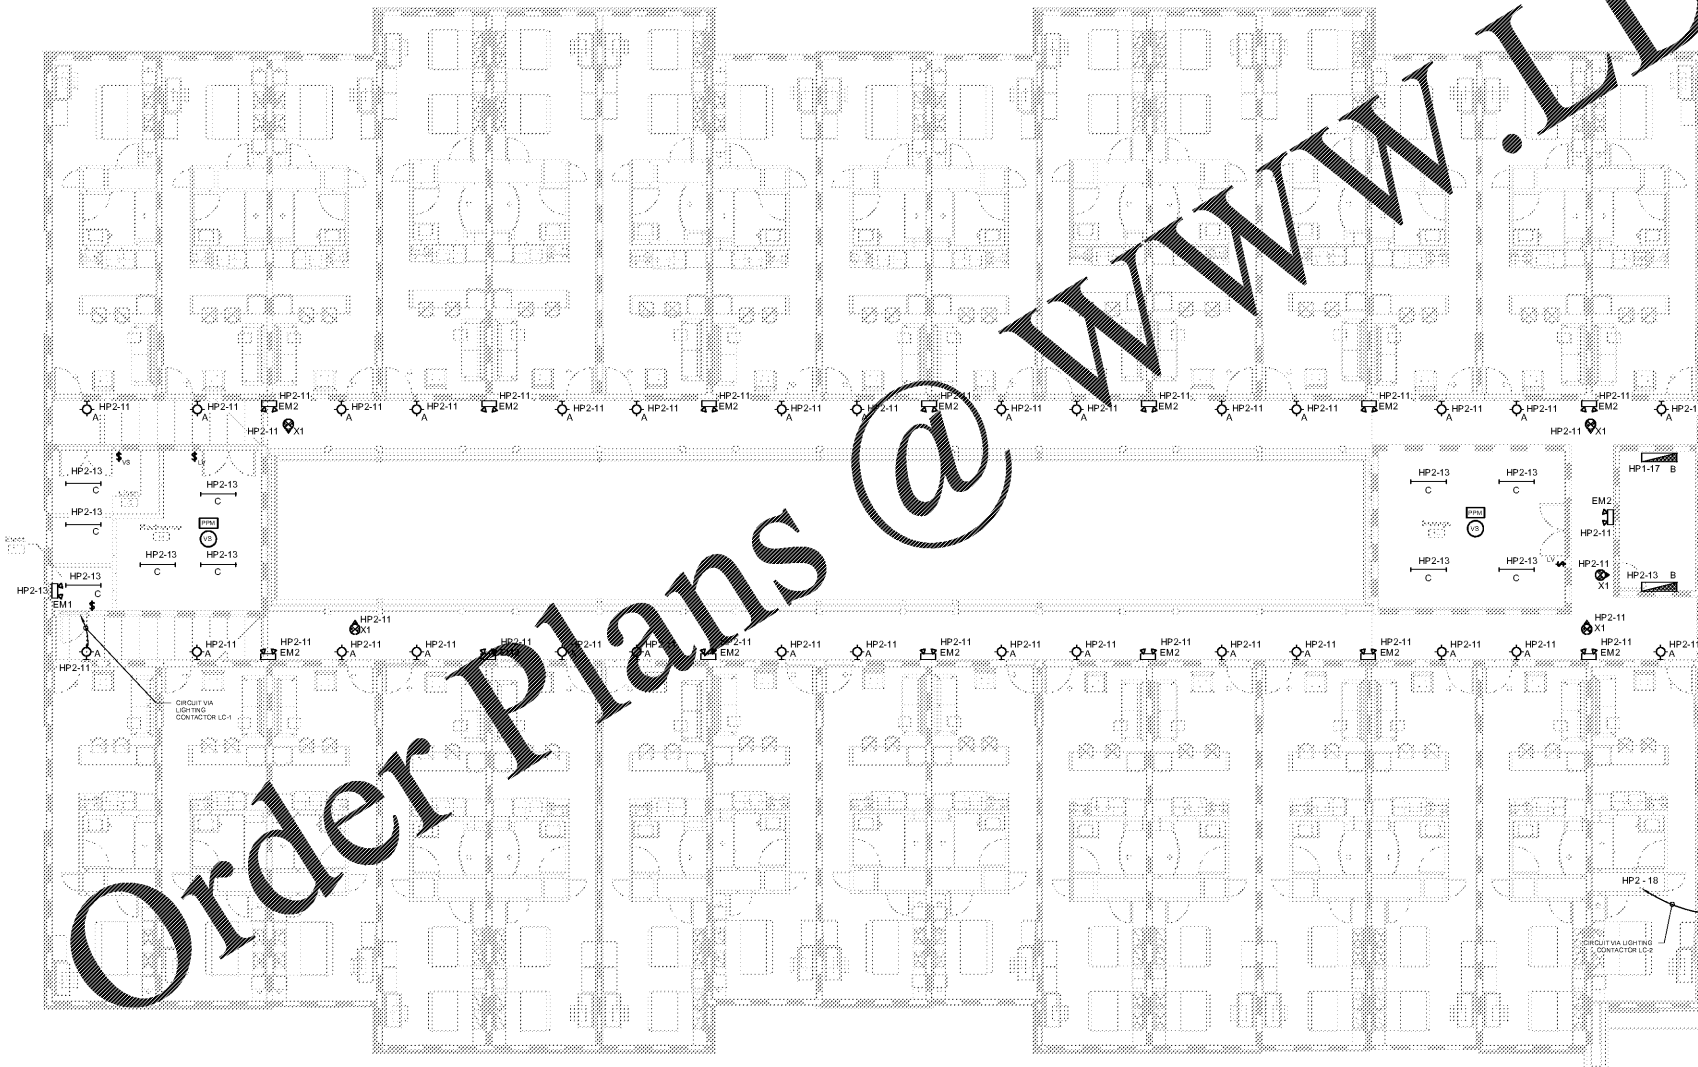

Level 2 - Lighting Plan
SCALE: 1/8" = 1'-0"

WWW.LDILine.com

Order Plans @