





COOPER CARRY
THE CENTER FOR CONNECTIVE ARCHITECTURE

191 Peachtree Street NE
Suite 2400
Atlanta, GA 30303-1770
(404) 237-2000
coopercarry.com

©2020 COOPER CARRY

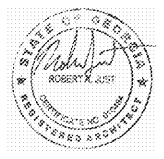

ISSUANCES		
No.	Drawing Issue Description	Date
A	DOE PRELIMINARY SUBMITTAL	20180731
B	DESIGN DEVELOPMENT	20191016
C	CHECK SET	20191202
D	FINAL APPROVAL	20200108
E	ISSUED FOR BIDD	20200203

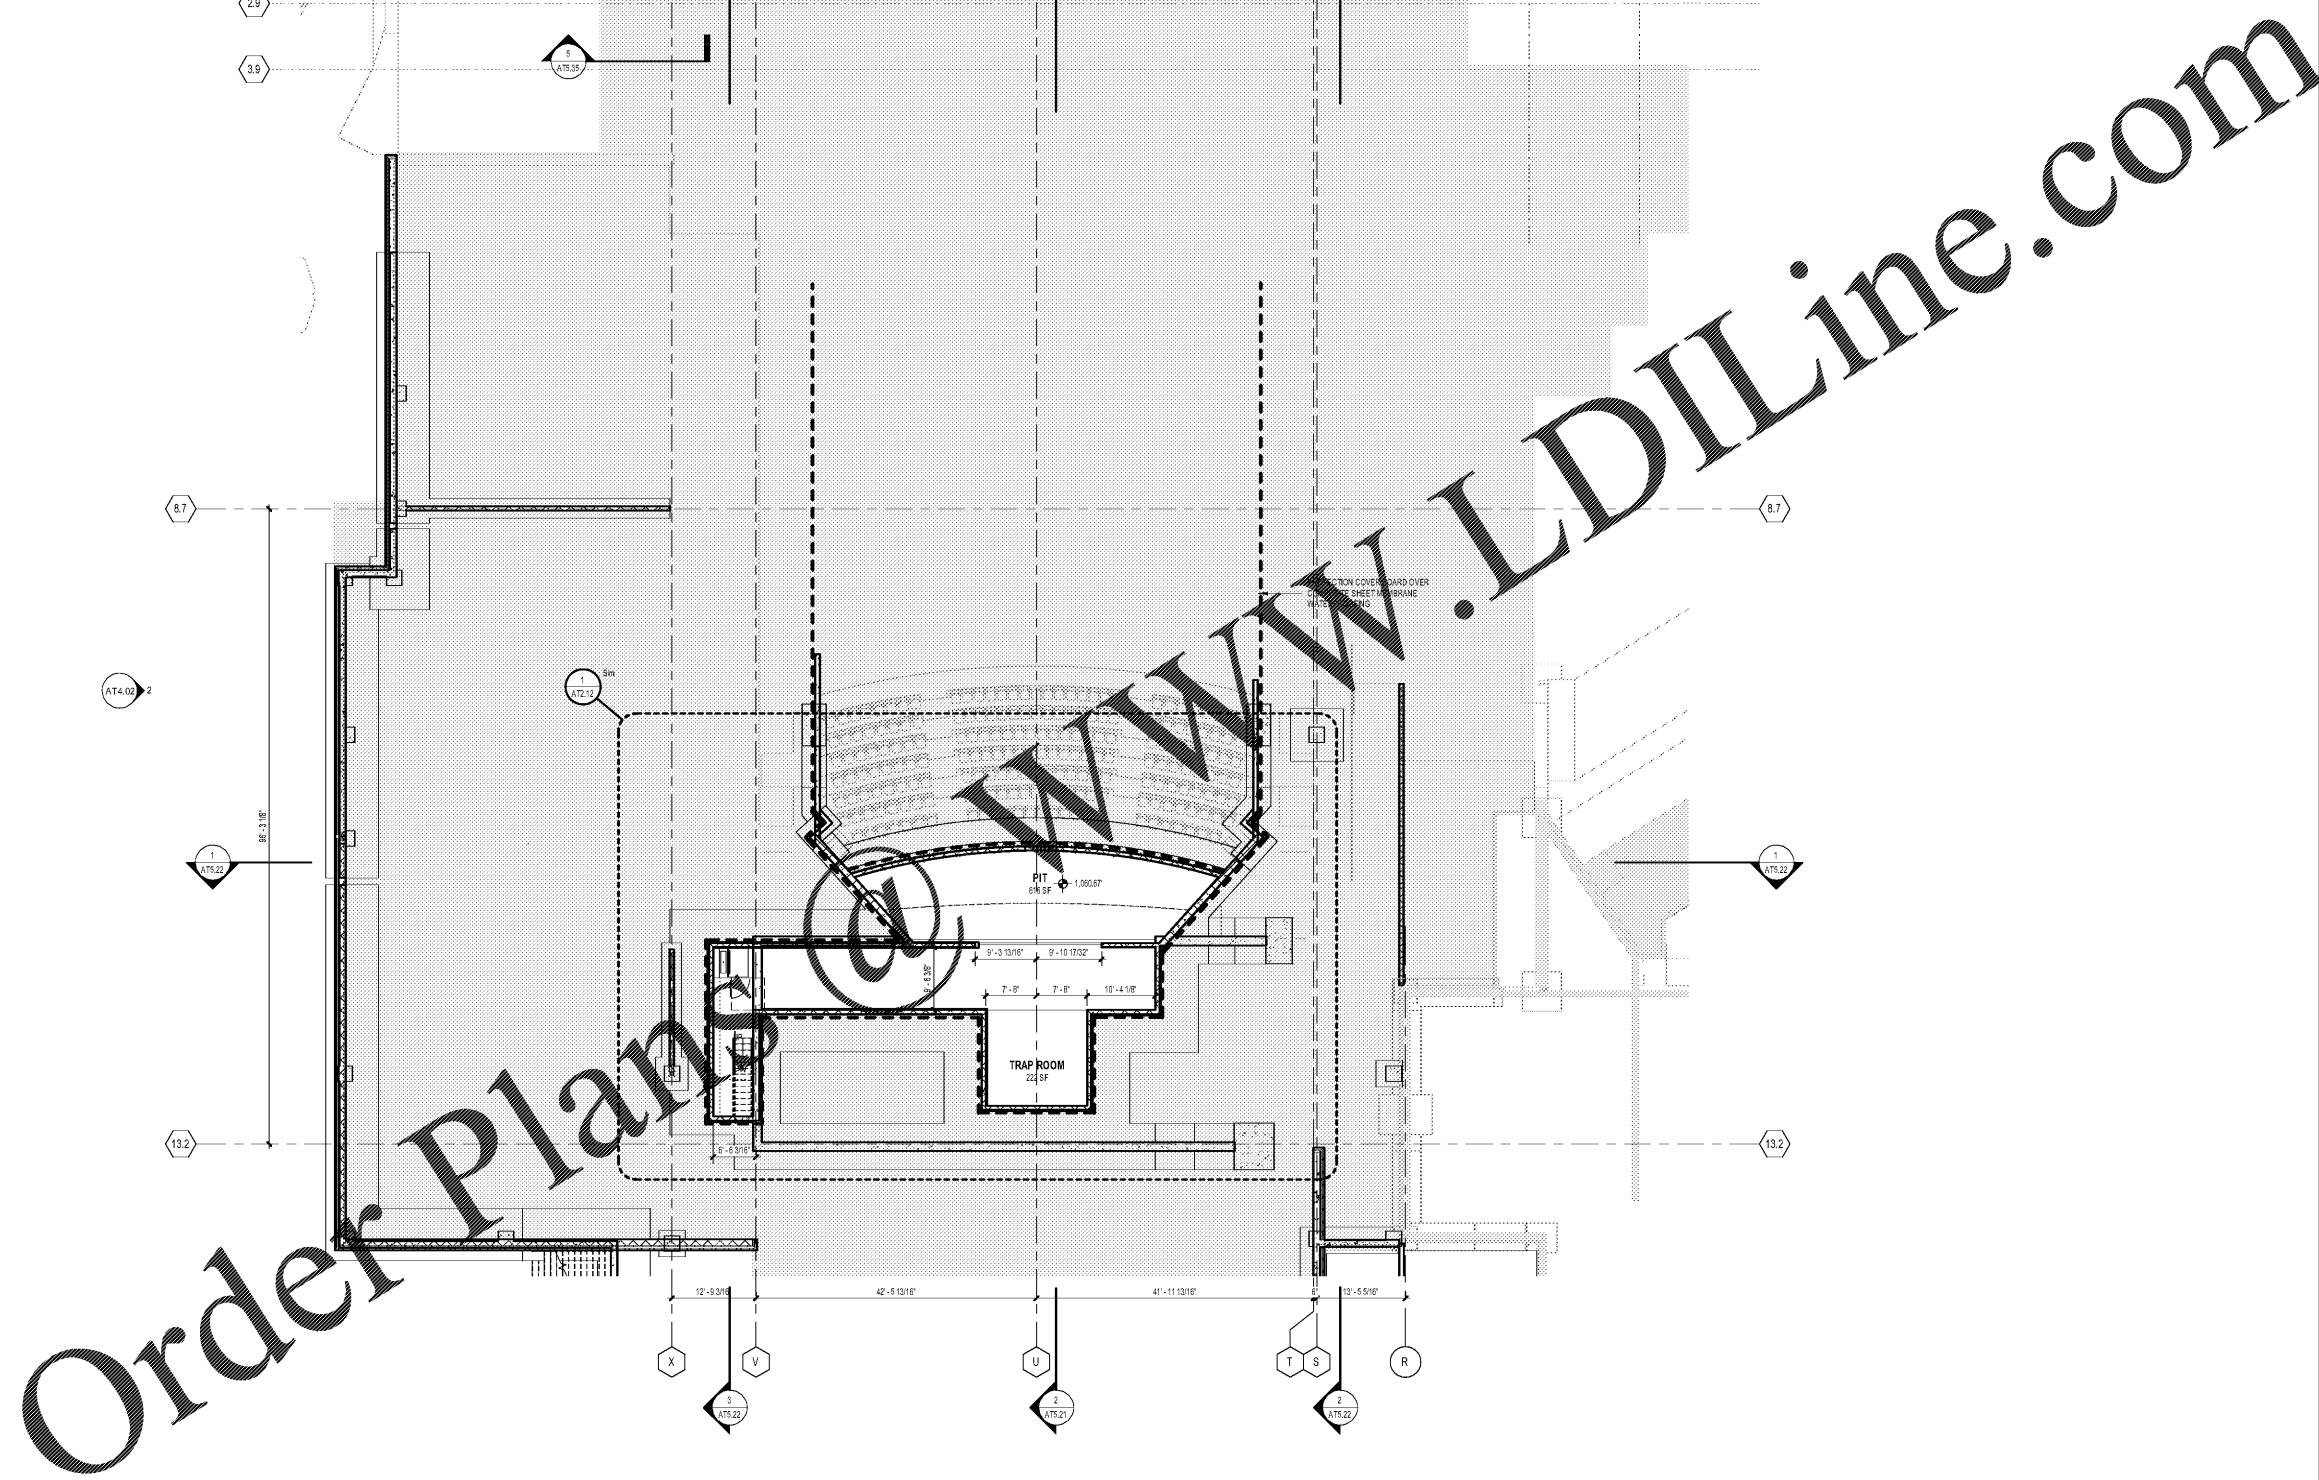

1 T/LPIT - OVERALL
AT2.03 SCALE: 3/32" = 1'-0"



MAGNATE THEATER (GROSS AREA)	
THEATER / STAGE / PIT	34,963 SF
EXISTING	14,020 SF
CONTROL BOOTH	899 SF
	49,882 SF

PEBBLEBROOK HS B007 -
MAGNET THEATER
DOE Facility Code 4066
FTE = 2787
IU = 143
991 OLD ALABAMA ROAD
MABLETON, GA 30126
COBB COUNTY SCHOOL DISTRICT
FLOOR PLAN -PIT LEVEL -
OVERALL

ROBERT A. JUST 20180308
Principal/Designer
SOPHIA TARKHAN 02/03/20
Project Manager
MARC NUNES
Project Architect
MATTHEW PARKS
Staff Architect

AT2.03

ISSUED FOR CONSTRUCTION

PROJECT NUMBER: 20180308 PROJECT NAME: PEBBLEBROOK HS B007 - MAGNET THEATER
SHEET NUMBER: AT2.03 - FLOOR PLAN -PIT LEVEL - OVERALL
M:\2018\20180308\7 drawings\7-1 rev\Users\20180308_Pebblebrook B007_Theater_2019_Nunes\02178.rvt
1/30/2020 3:33:13 PM