


Order Plans @

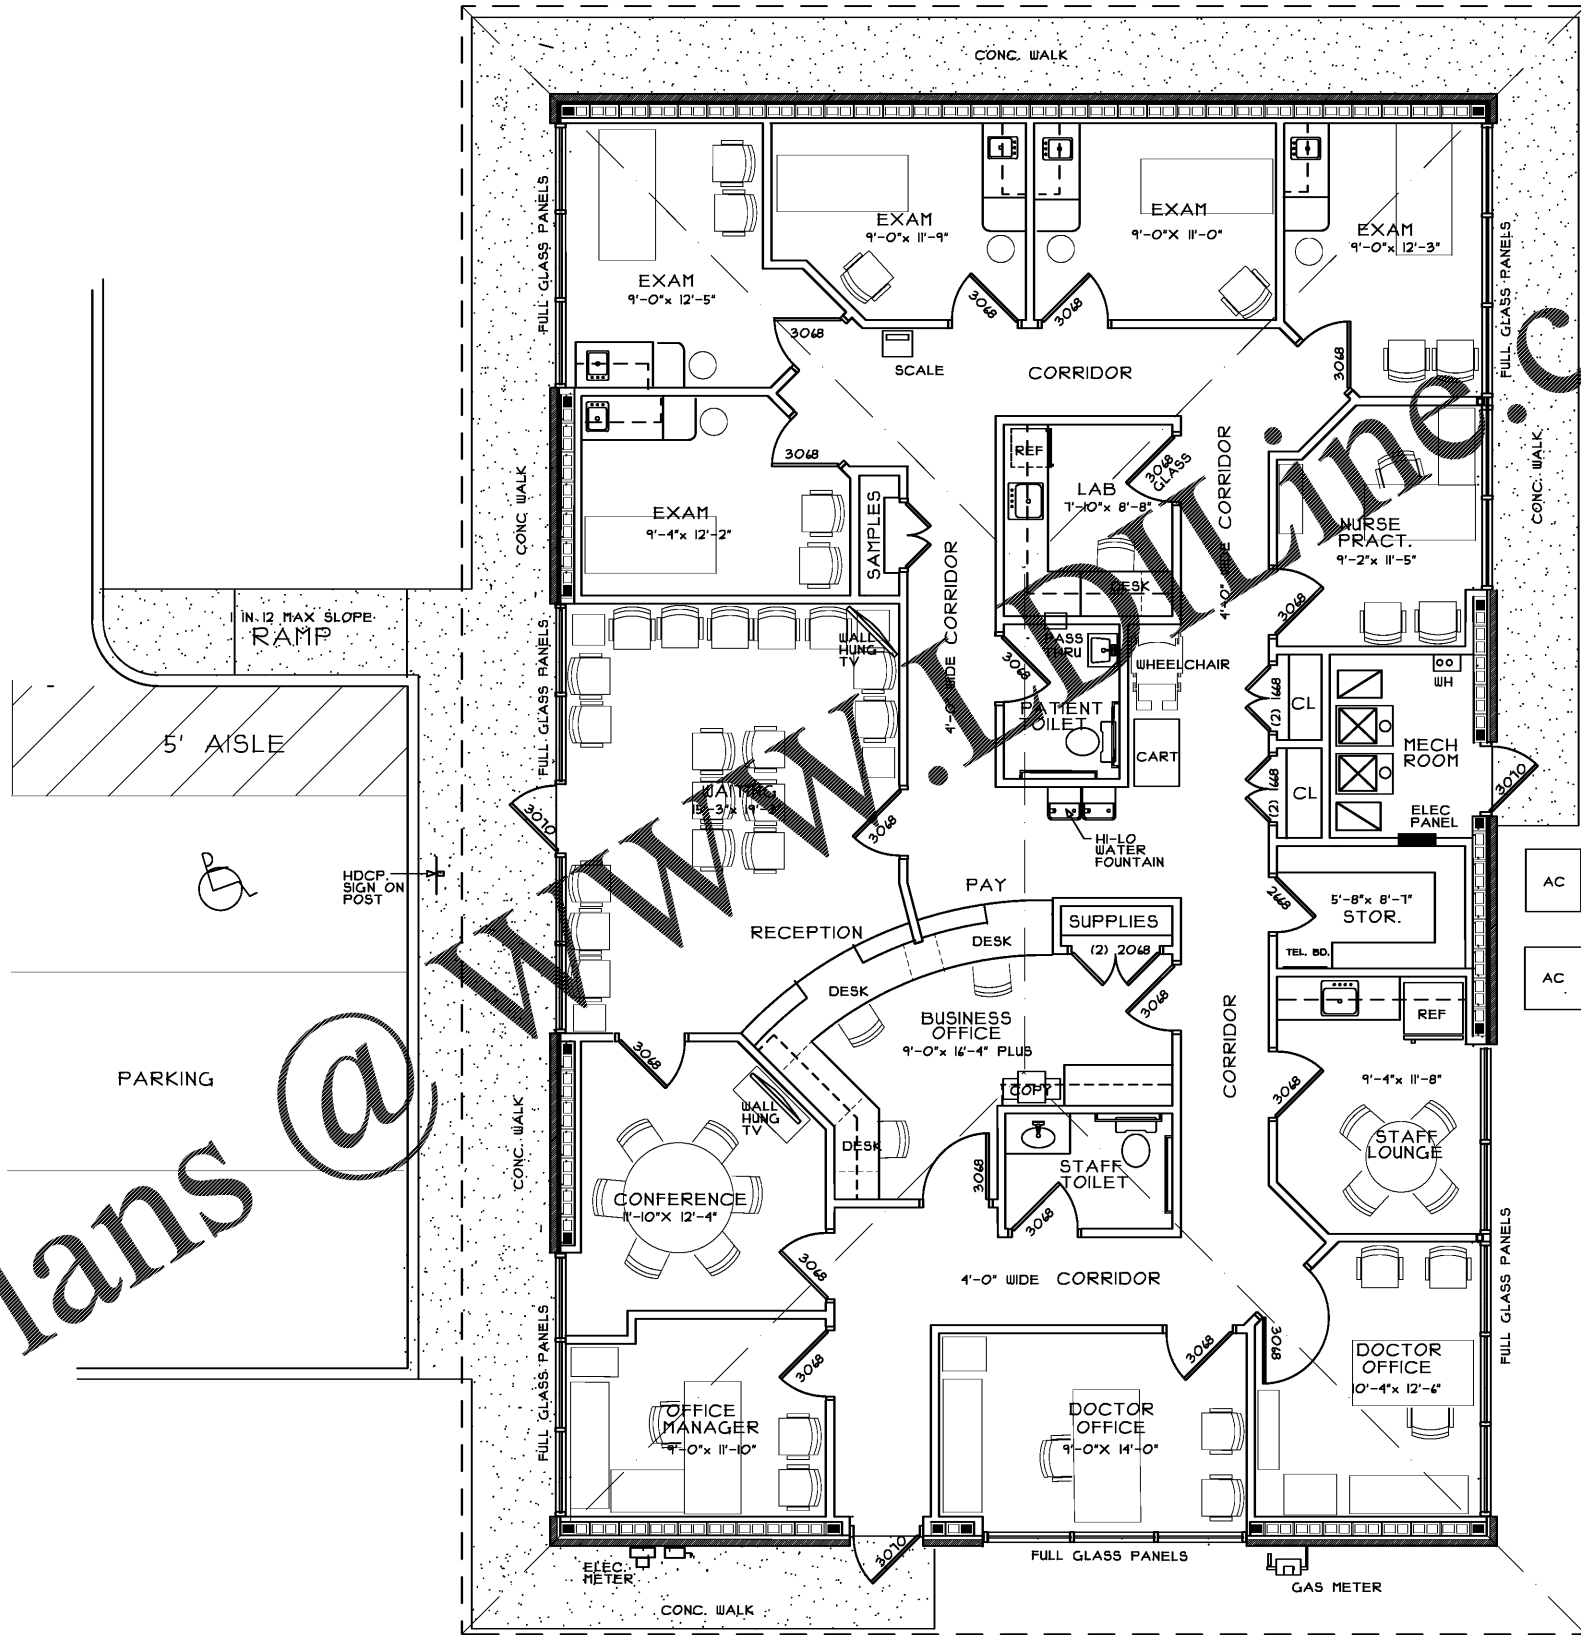


FLOOR PLAN WITH FURNITURE

SCALE: 1/4" = 1'-0"

2420 SQ.FT. LEASEABLE SPACE

F.E.
D.

WALL MOUNTED PORTABLE FIRE EXTINGUISHER
HANDLE AT 48" A.F.F.

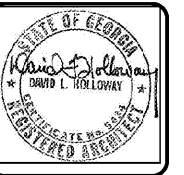

DAVID L. HOLLOWAY & ASSOCIATES
ARCHITECT
1888 WINDCREST DRIVE
LILBURN, GA. 30148-8854

NO.	REVISION	BY
1		DLH

RELEASED FOR CONSTRUCTION
MEDICAL OFFICE LEASE SPACE BUILDING
FOR
CRESCENT MEDICAL CENTRE, LLC
AT
CRESCENT MEDICAL CENTER
1404 MONTREAL ROAD
TUCKER, GEORGIA

DRAWN : DLH	CHECKED : DLH
DATE :	
SCALE : AS NOTED	
JOB NO. :	
SHEET	
AI	
JANUARY 21, 2020	