


DAVID L. HOLLOWAY & ASSOCIATES
ARCHITECT
1986 WINDCREST DRIVE LILBURN, GA. 30068-0654

NO.	REVISION	BY	DATE
1		DLH	


MEDICAL OFFICE LEASE SPACE BUILDING
FOR
CRESCENT MEDICAL CENTRE, LLC
AT
CRESCENT MEDICAL CENTER
1404 MONTREAL ROAD
TUCKER, GEORGIA

RELEASED FOR CONSTRUCTION


DRAWN :	CHECKED :
DLH	DLH
DATE :	
SCALE : AS NOTED	
JOB NO. :	
SHEET	
A3	
JANUARY 21, 2020	

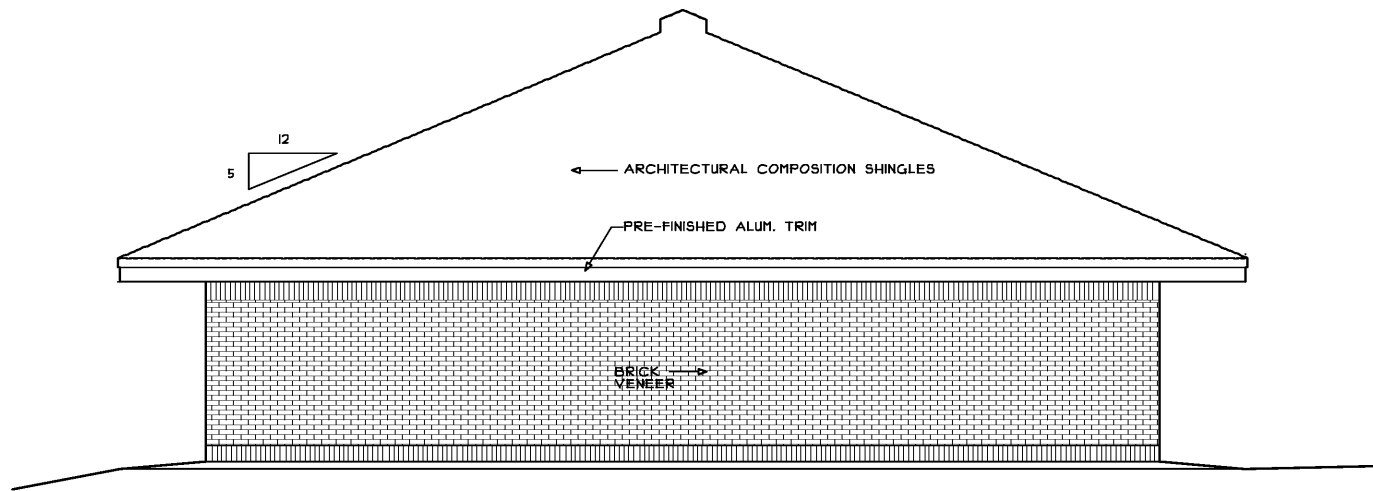


SOUTH ELEVATION
SCALE: 1/4" = 1'-0"

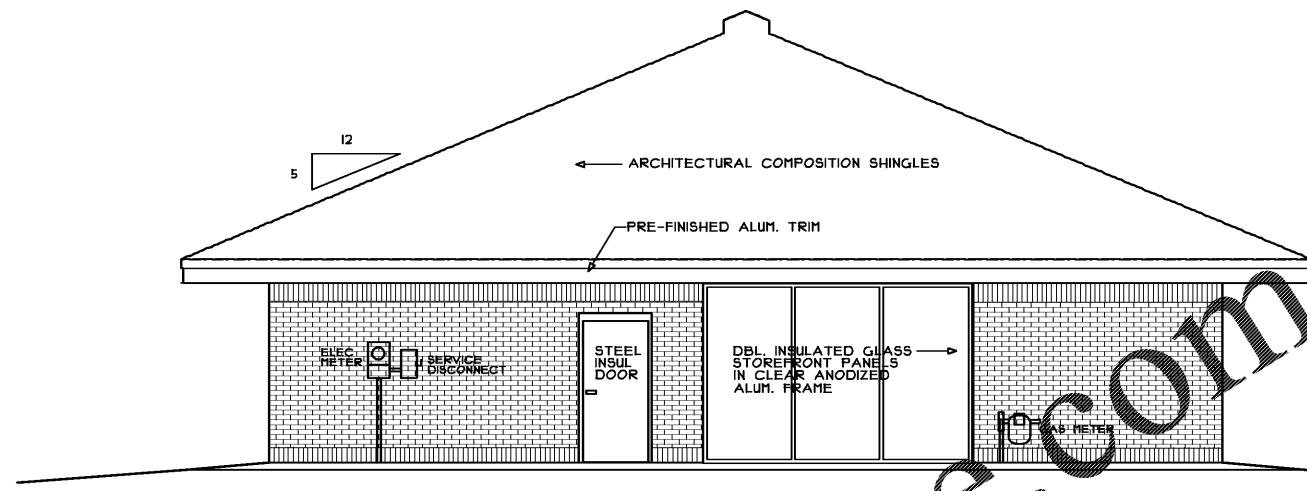

NORTH ELEVATION
SCALE: 1/4" = 1'-0"

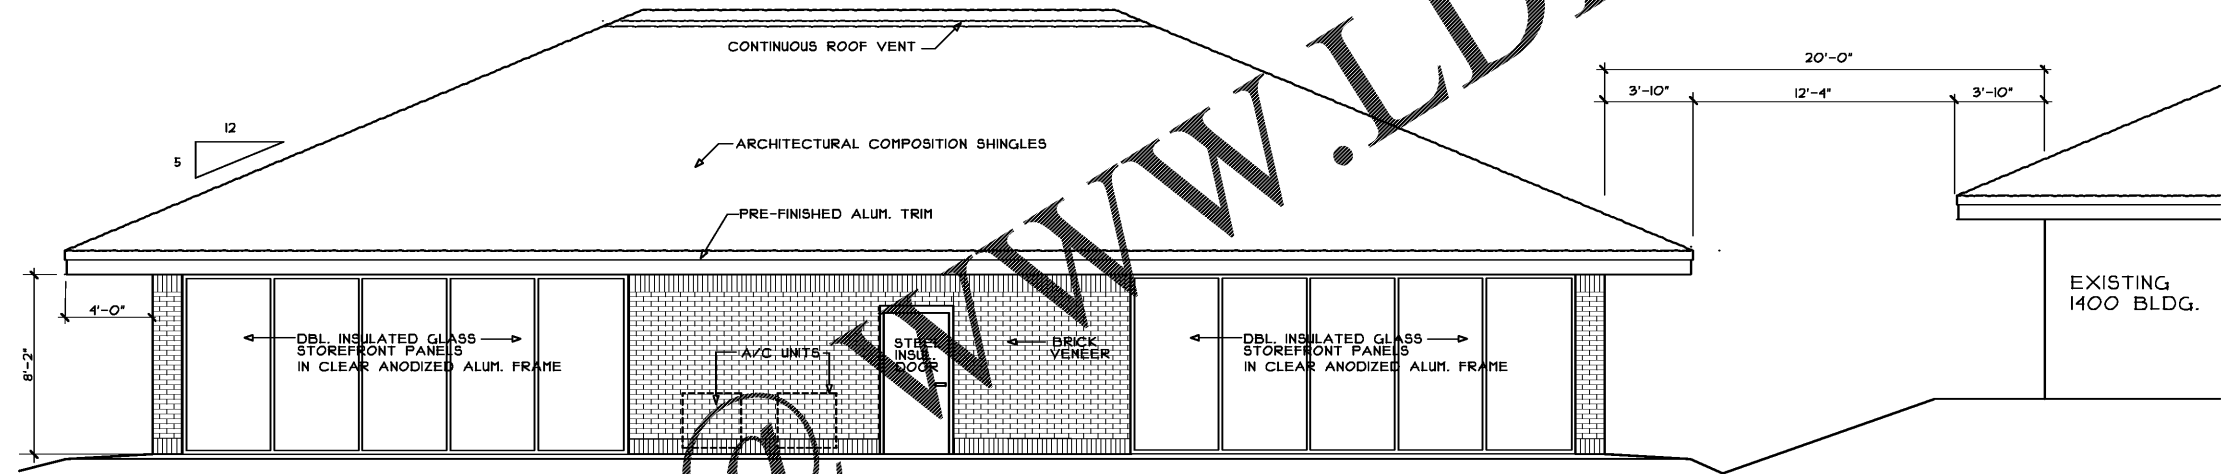

WEST ELEVATION (EXPRESSWAY SIDE)
SCALE: 1/4" = 1'-0"

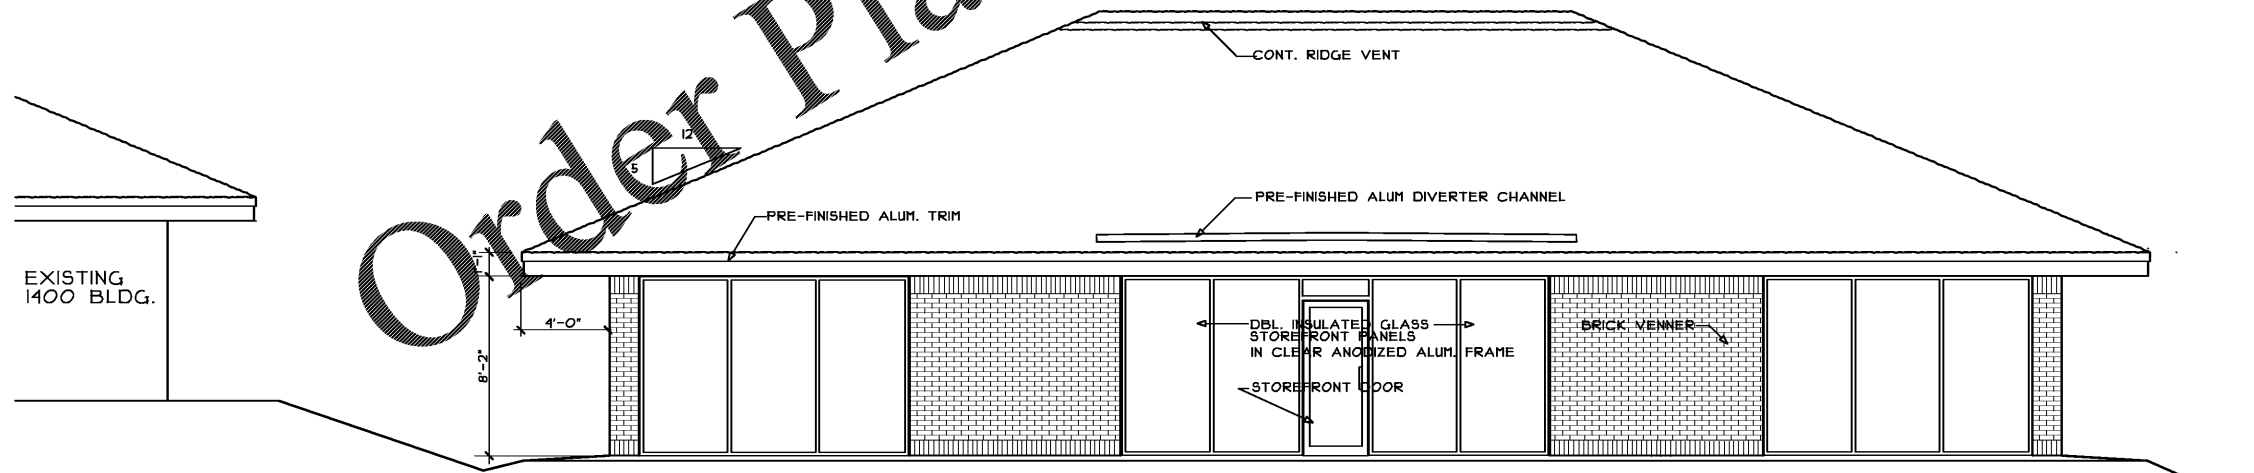

EAST ELEVATION (FRONT)
SCALE: 1/4" = 1'-0"

Order Plans @ www.LDILine.com