



Order Plans @ www.LDILine.com

FOOTING SCHEDULE		3000 PSI CONCRETE
MARK	SIZE	REINF.
F1	12" THICK x 36" x 36"	(3) #4 EA. WAY
F2	12" THICK x 24" CONT.	(2) #4 CONT.
F3	12" THICK x 30" x 30"	(2) #4 EA. WAY
F4	12" THICK x 42" x 42"	(3) #4 EA. WAY
F5	1'-6" THICK x 8" WIDE CONT. MONOLITHIC SLAB EDGE	(2) #4 (TOP & BOT) CONT.

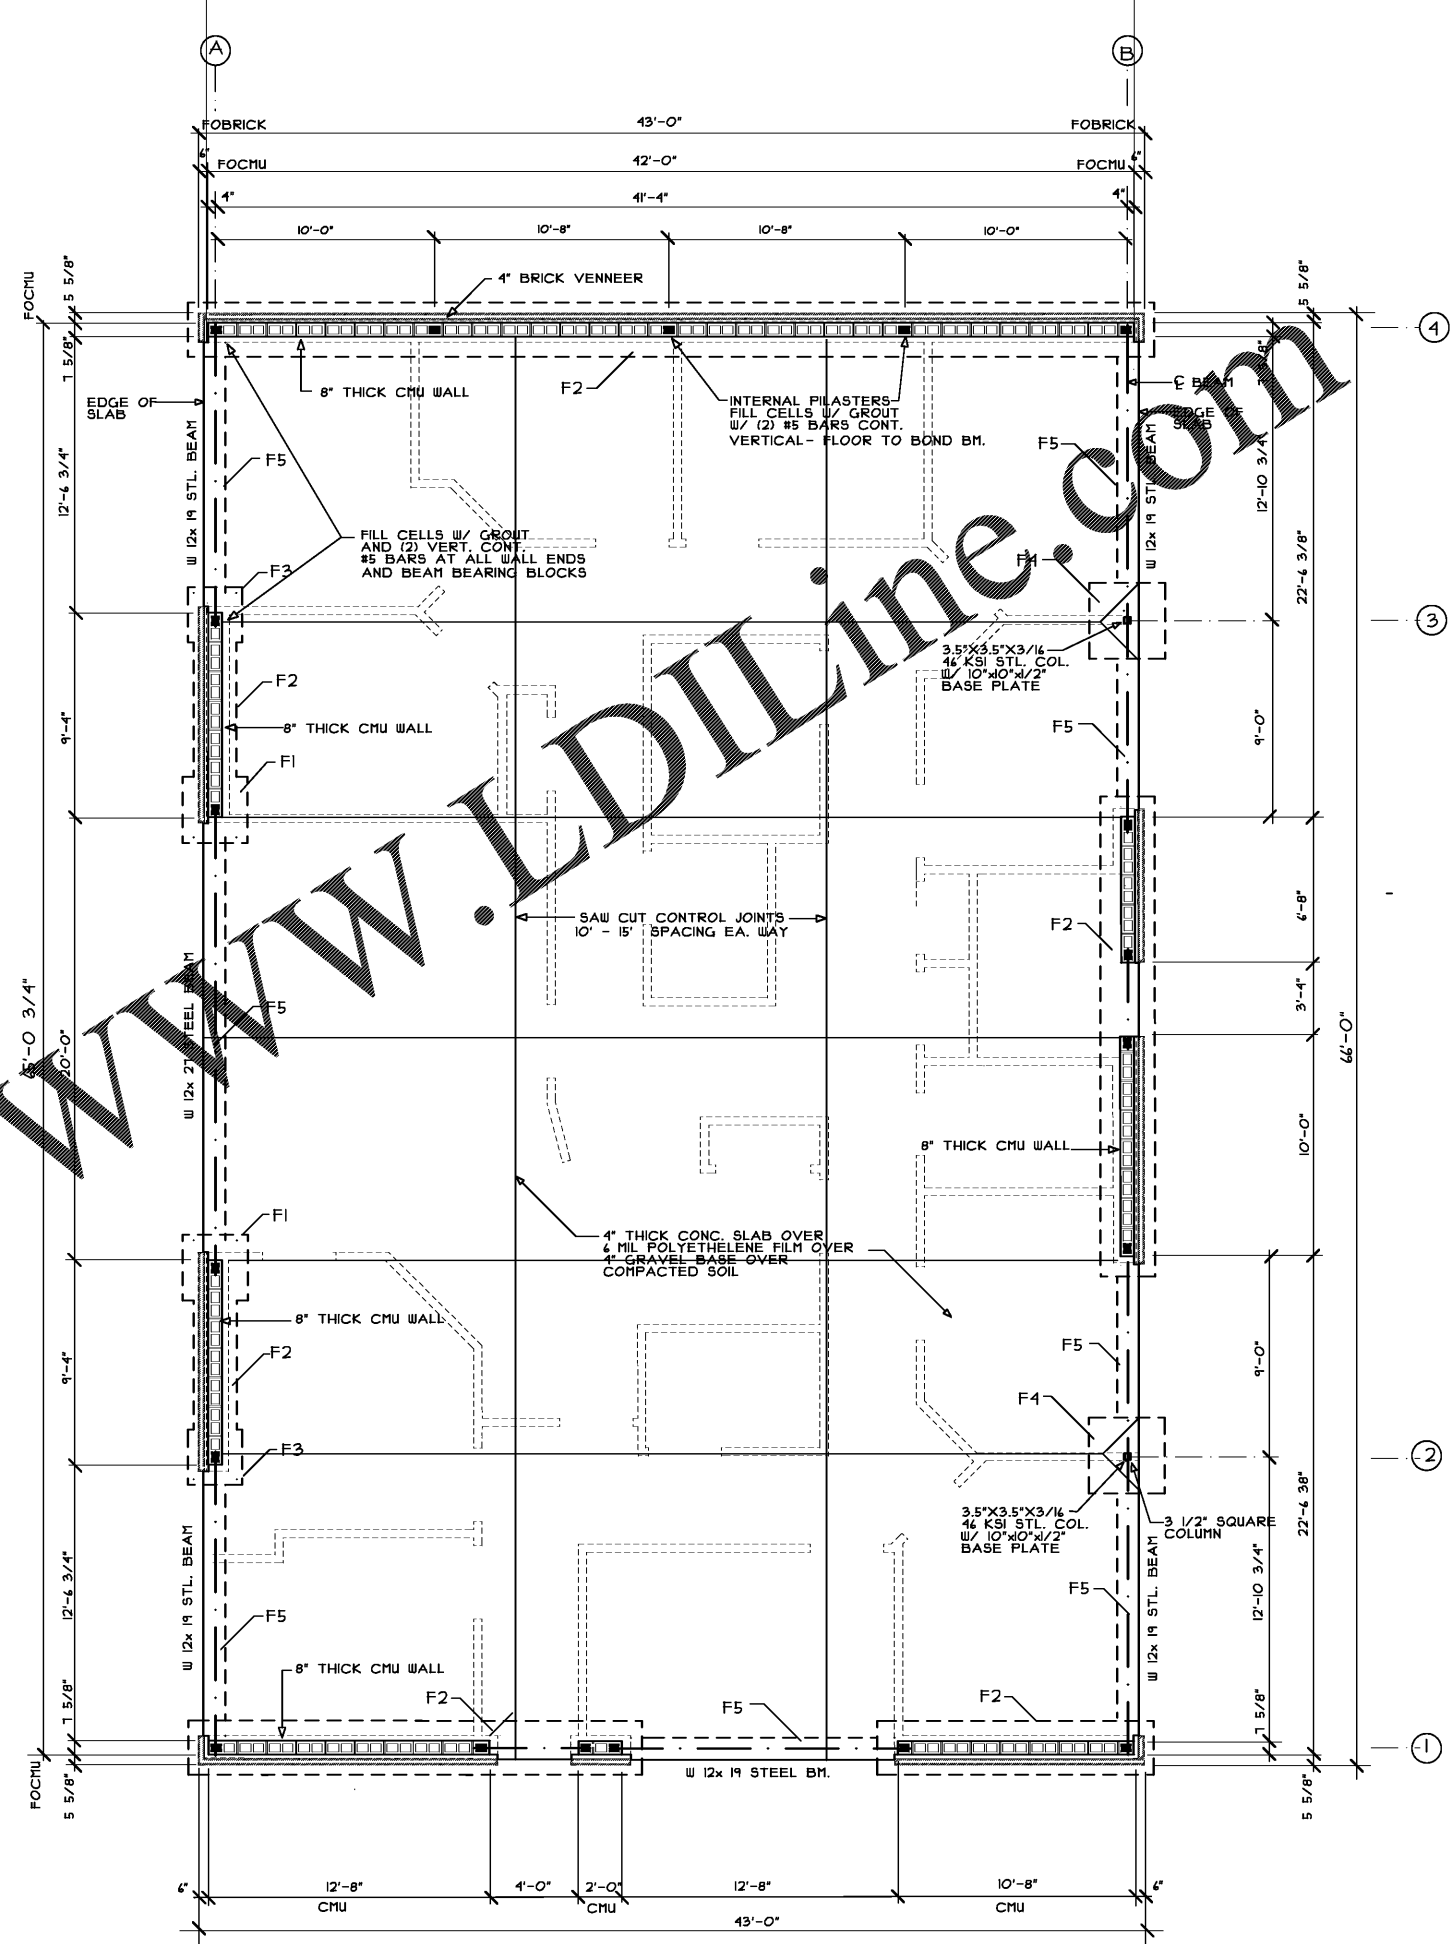

FOUNDATION PLAN
SCALE: 1/4" = 1'-0"

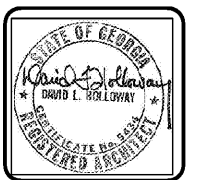

DAVID L. HOLLOWAY & ASSOCIATES
ARCHITECT
1888 WINDCREST DRIVE
LILBURN, GA. 30049
(770) 908-6654

NO.	REVISION	BY	DLH
1			

MEDICAL OFFICE LEASE SPACE BUILDING
FOR
CRESCENT MEDICAL CENTRE, LLC
AT
CRESCENT MEDICAL CENTER
1404 MONTREAL ROAD
TUCKER, GEORGIA

DRAWN : DLH	CHECKED : DLH
DATE :	
SCALE : AS NOTED	
JOB NO. :	
SHEET	
JANUARY 21, 2020	

RELEASED FOR CONSTRUCTION