



Order Plans @ www.LDILine.com

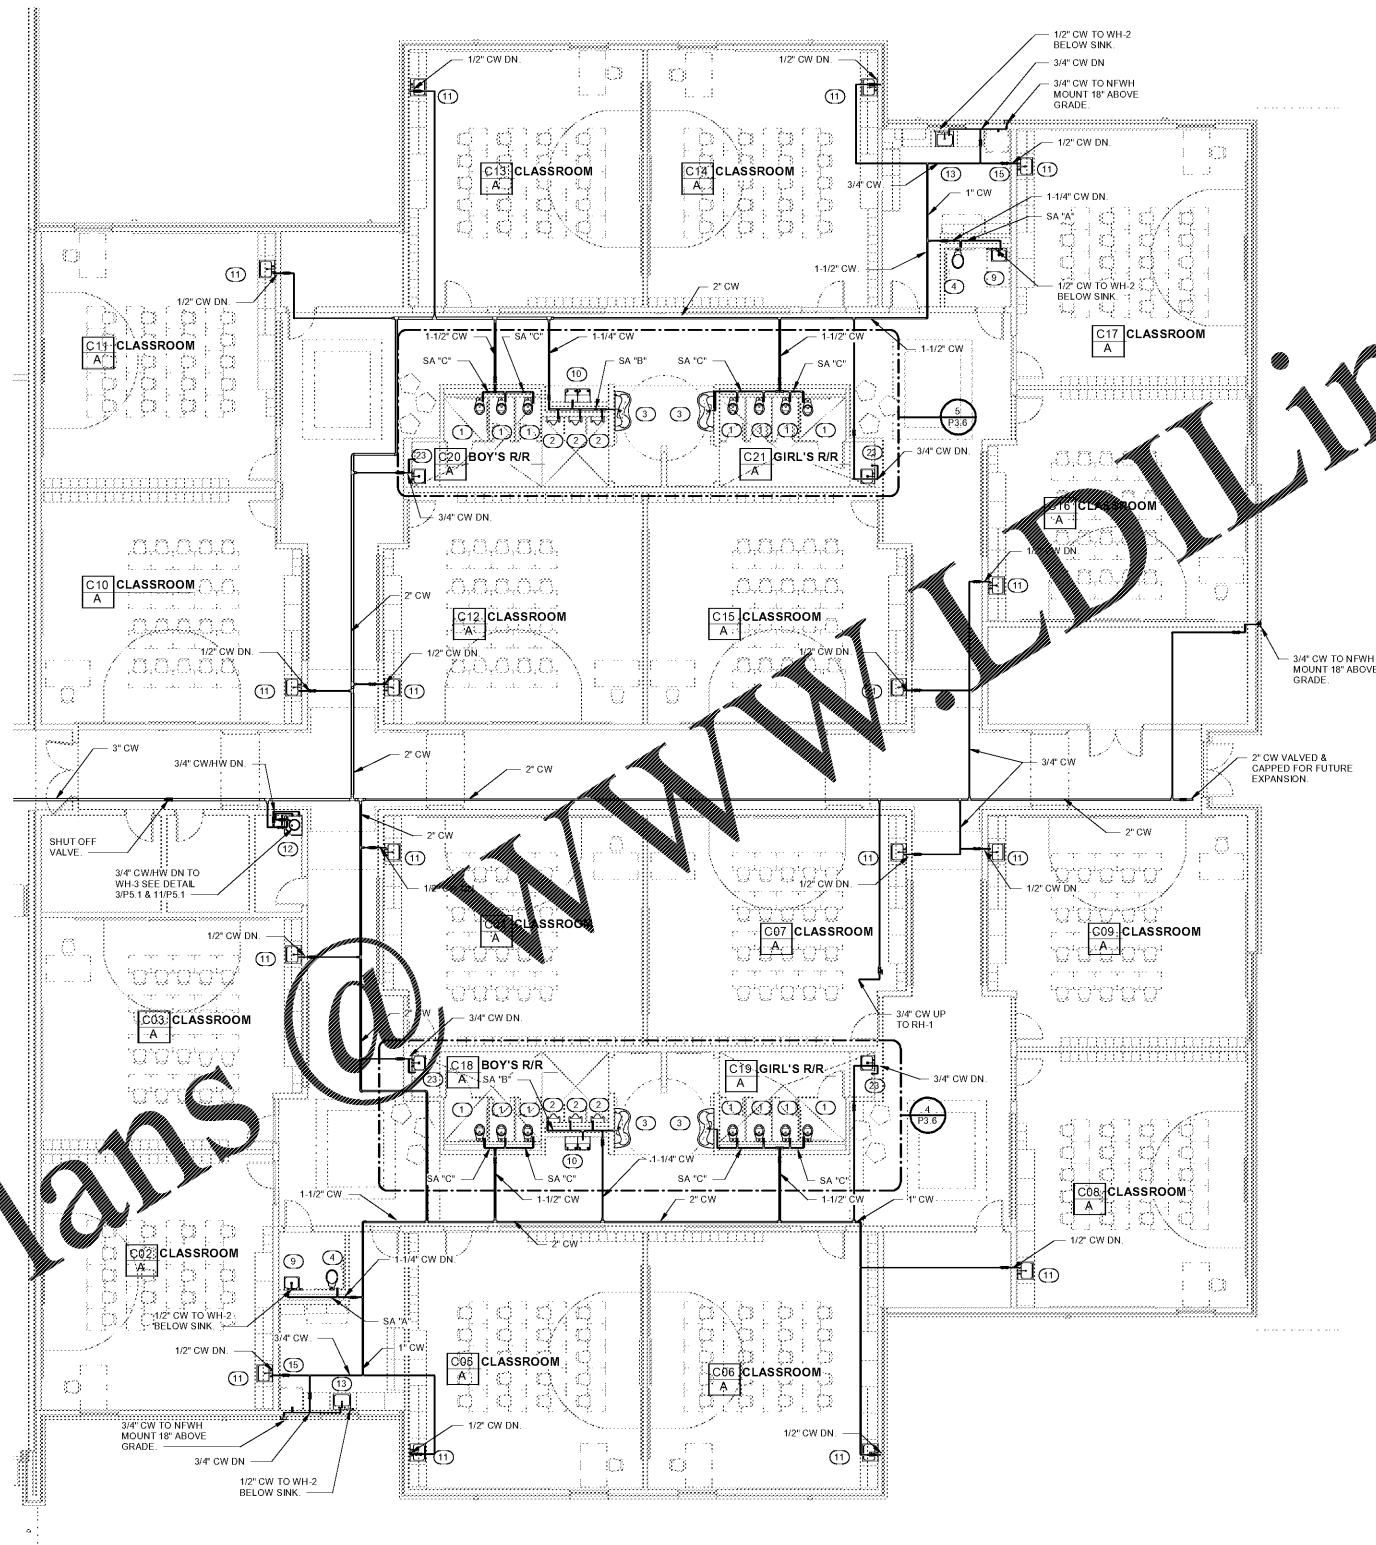

1 WATER FLOOR PLAN AREA "D"
P2.8 1/8" = 1'-0"

SEE PLUMBING NOTES ON SHEET P6.1 AND DETAILS ON SHEET P5.1.

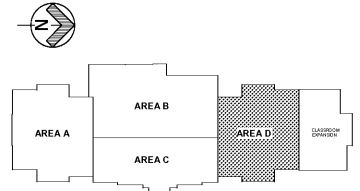

KEY PLAN



Facility No. 765-0108

CALHOUN EARLY LEARNING ACADEMY
FOR Calhoun City Schools
Overall square footage: 81,706 s.f.
P.T.E. # 550

REVISIONS

DATE: 01/15/2020
PROJECT NUMBER: 19-186
SHEET NUMBER: P2.8

DATE: 01/15/2020
PROJECT NUMBER: 19-186
SHEET NUMBER: P2.8