



WLA
 WATTS LEAF ARCHITECTS, PA
 101 North McDowell Street, Suite 112
 Charlotte, North Carolina 28204
 PH 704 376 1200 FX 704 376 5111


CRABTREE NORTH APTS.
 2251 Charles Drive
 Raleigh, North Carolina
 EYC COMPANIES

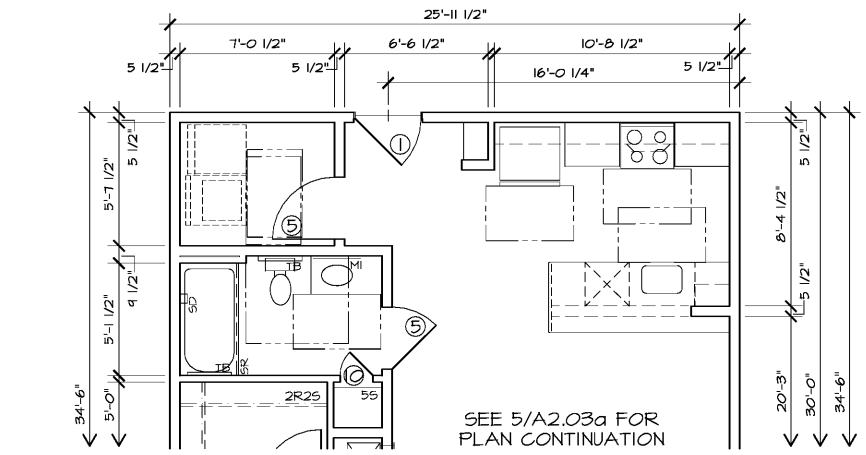


5a UNIT TYPE B5a - FLOOR PLAN
 A2.03a 816 HEATED SQ FT / 816 GROSS SQ FT
 I.B.C. TYPE 'B' H.C. UNIT 1/4"=1'-0"

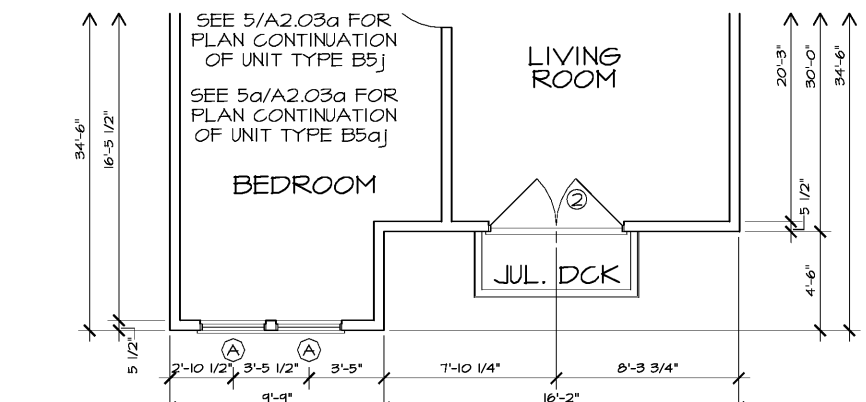


5j UNIT TYPE B5j / B5aj - FLOOR PLAN
 A2.03a 816 HEATED SQ FT / 834 GROSS SQ FT
 I.B.C. TYPE 'B' H.C. UNIT 1/4"=1'-0"

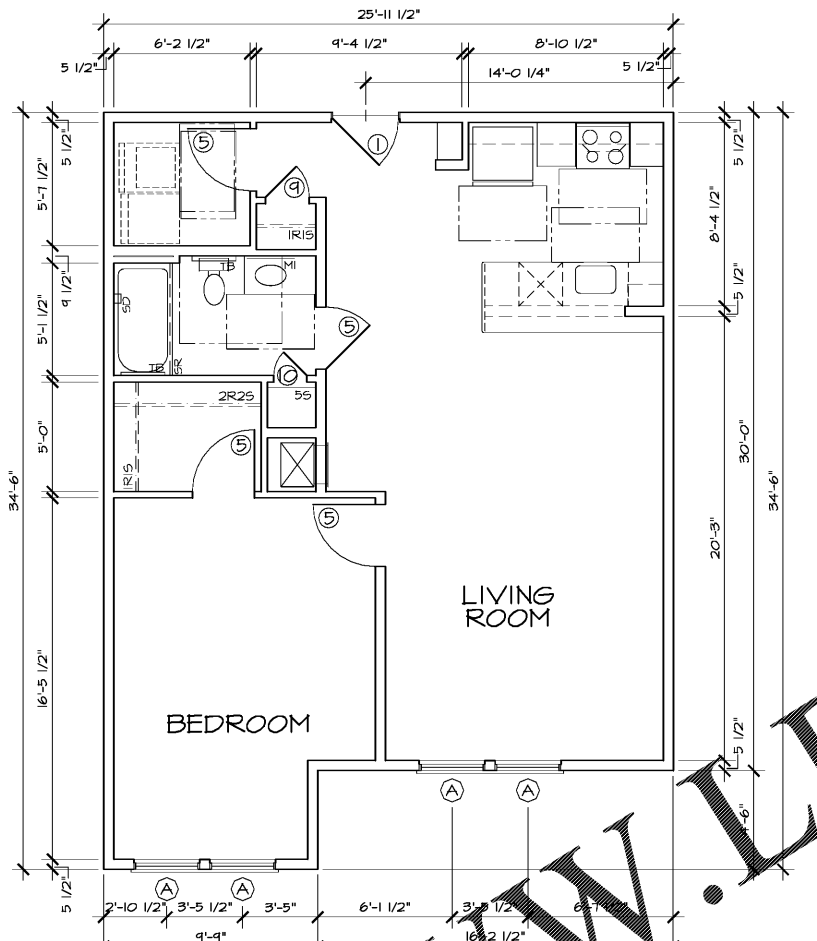


5 UNIT TYPE B5 - FLOOR PLAN
 A2.03a 816 HEATED SQ FT / 816 GROSS SQ FT
 I.B.C. TYPE 'B' H.C. UNIT 1/4"=1'-0"

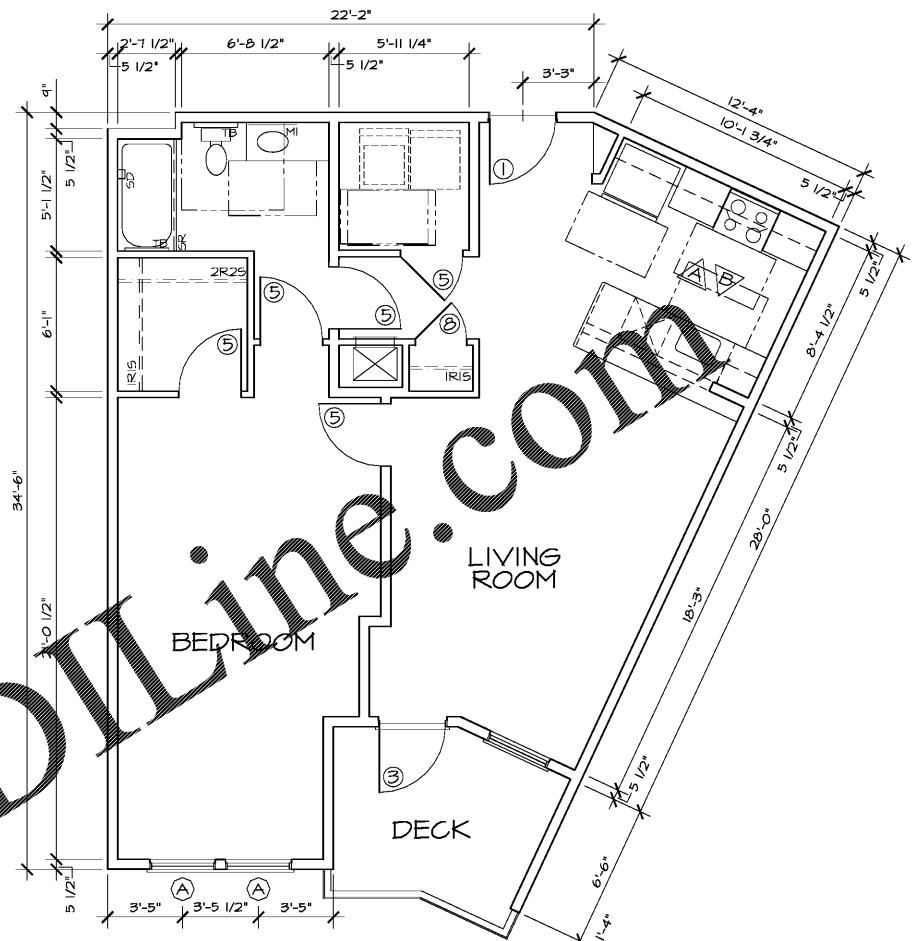


4 UNIT TYPE B4 - FLOOR PLAN
 A2.03a 857 HEATED SQ FT / 939 GROSS SQ FT
 I.B.C. TYPE 'B' H.C. UNIT 1/4"=1'-0"

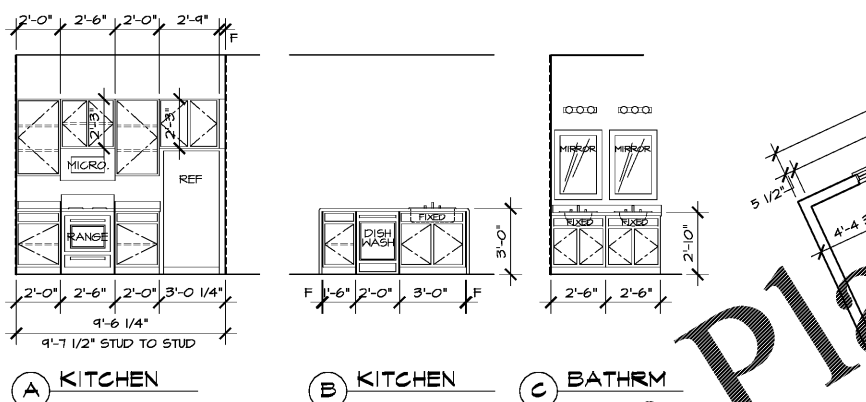


UNIT TYPES B6/B6j - INT. ELEVATIONS
 SEE SHEET A2.03 FOR INTERIOR ELEVATIONS FOR UNIT TYPES B4 & B5

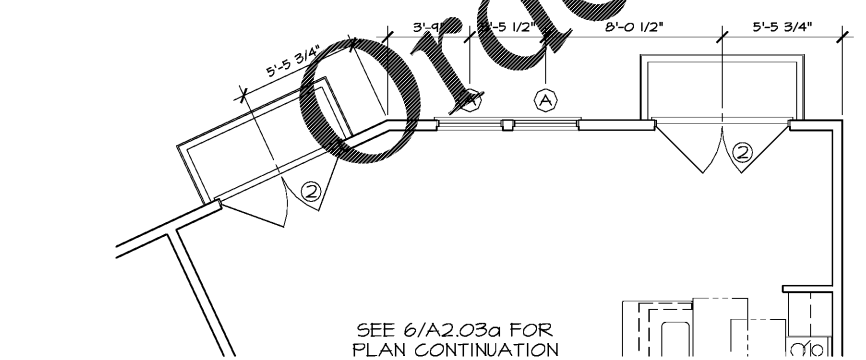


6j UNIT TYPE B6j - FLOOR PLAN
 A2.03a 1092 HEATED SQ FT / 1157 GROSS SQ FT
 I.B.C. TYPE 'B' H.C. UNIT 1/4"=1'-0"

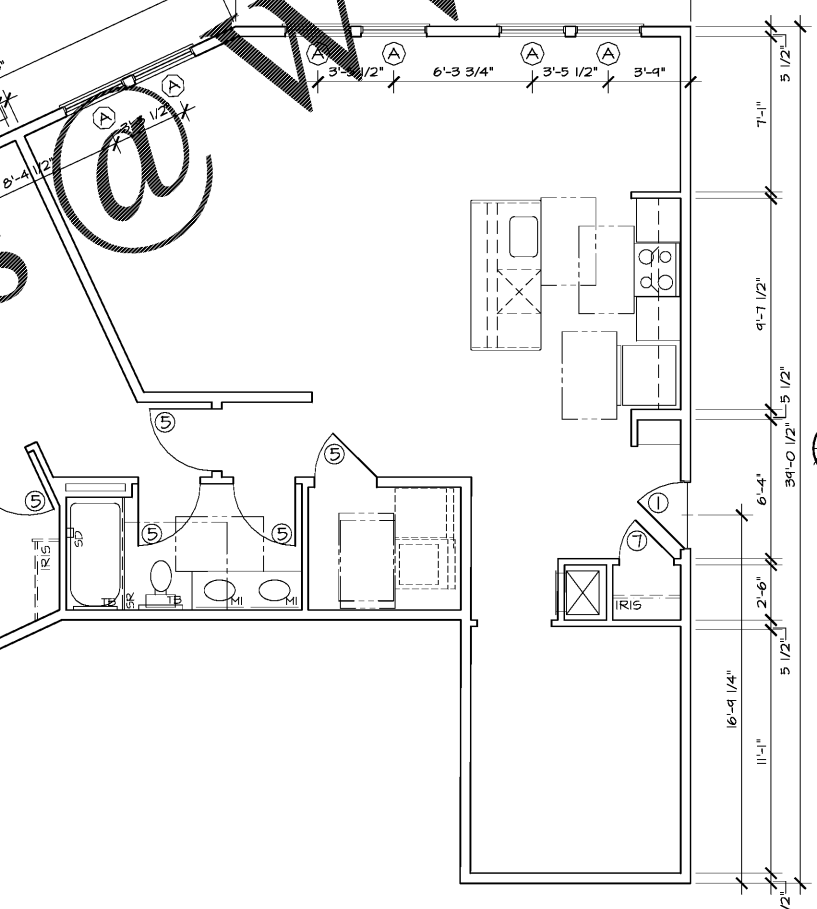

6 UNIT TYPE B6 - FLOOR PLAN
 A2.03a 1092 HEATED SQ FT / 1092 GROSS SQ FT
 I.B.C. TYPE 'B' H.C. UNIT 1/4"=1'-0"

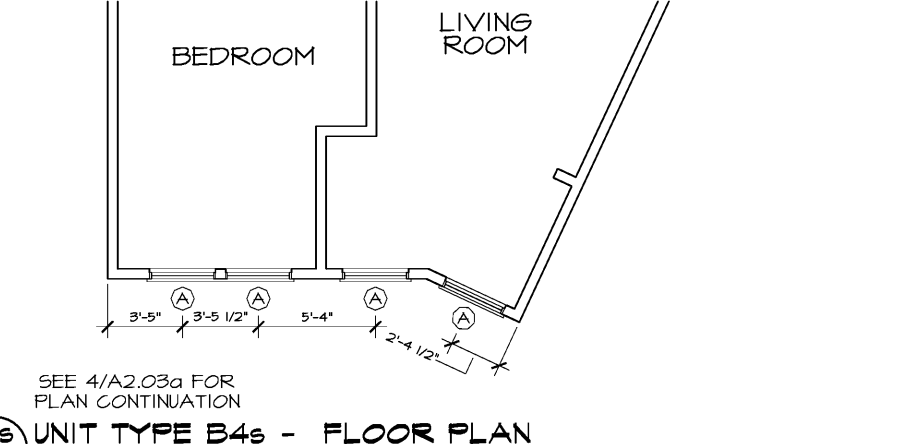

4s UNIT TYPE B4s - FLOOR PLAN
 A2.03a 926 HEATED SQ FT / 926 GROSS SQ FT
 I.B.C. TYPE 'B' H.C. UNIT 1/4"=1'-0"

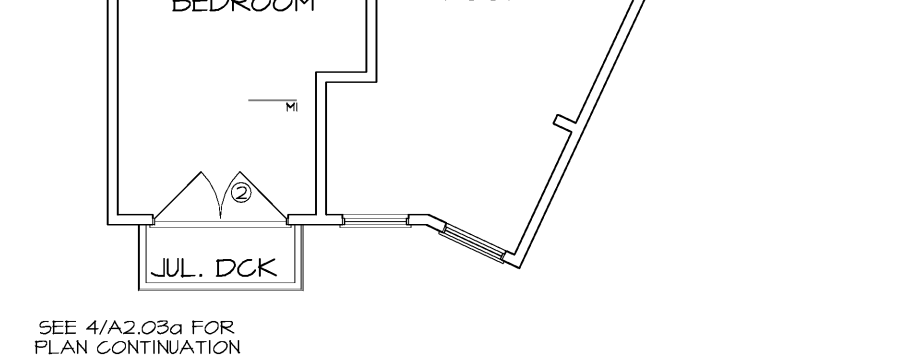

4j UNIT TYPE B4sj - FLOOR PLAN
 A2.03a 926 HEATED SQ FT / 949 GROSS SQ FT
 I.B.C. TYPE 'B' H.C. UNIT 1/4"=1'-0"

PROJECT	1915
DATE	03FEB20
DRAWN BY	WJP
CHECKED BY	CMW
B4, B5 & B6 UNIT TYPES - PLANS AND INTERIOR ELEVATIONS	
A2.03a	