



Order Plans @

WWW.DLine.com

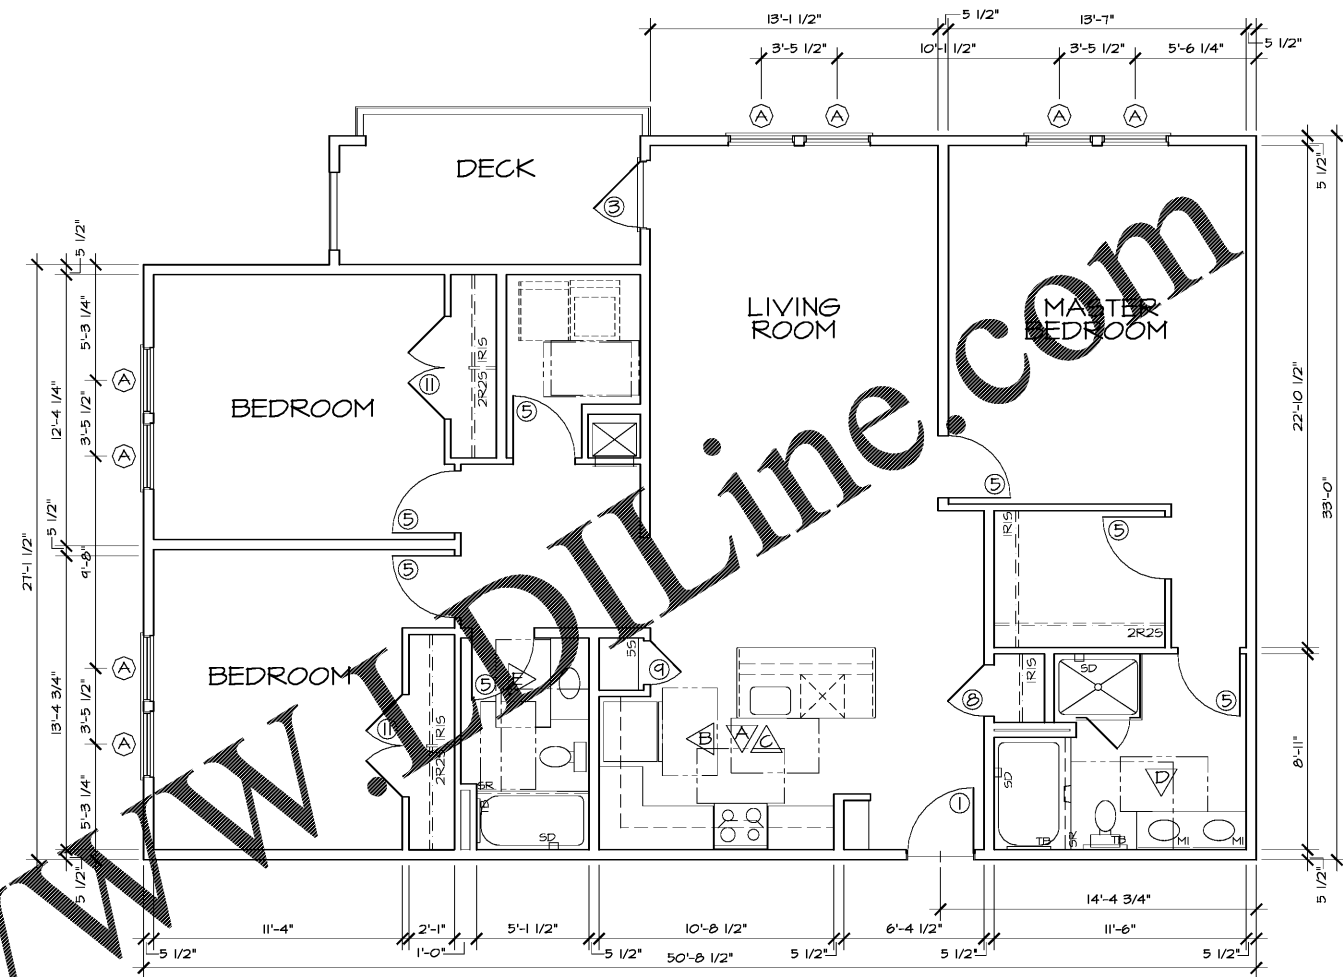

UNIT TYPE D1 - FLOOR PLAN  
 A2.05 1540 HEATED SQ FT / 1638 GROSS SQ FT  
 I.B.C. TYPE 'B' H.C. UNIT  
 1/4"=1'-0"

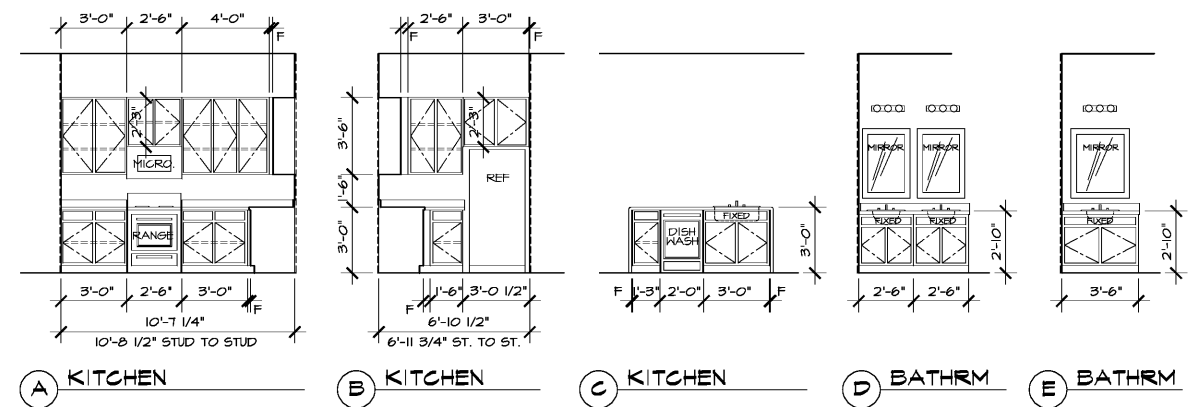

UNIT TYPE D1 - INTERIOR ELEVATIONS



**WLA**  
 WATTS LEAF ARCHITECTS, PA  
 101 North McDowell Street, Suite 112  
 Charlotte, North Carolina 28204  
 PH 704 376 1200 FX 704 376 5111

**CRABTREE NORTH APTS.**  
 2251 Charles Drive  
 Raleigh, North Carolina  
 EYC COMPANIES

PROJECT 1915  
 DATE 03FEB20  
 DRAWN BY WJP  
 CHECKED BY CMW

D1 UNIT TYPE -  
 PLAN AND INTERIOR  
 ELEVATIONS

**A2.05**