



**WLA**  
 WATTS LEAF ARCHITECTS, PA  
 101 North McDowell Street, Suite 112  
 Charlotte, North Carolina 28204  
 PH 704 376 1200 FX 704 376 5111

**CRABTREE NORTH APTS.**  
 2251 Charles Drive  
 Raleigh, North Carolina  
 EYC COMPANIES

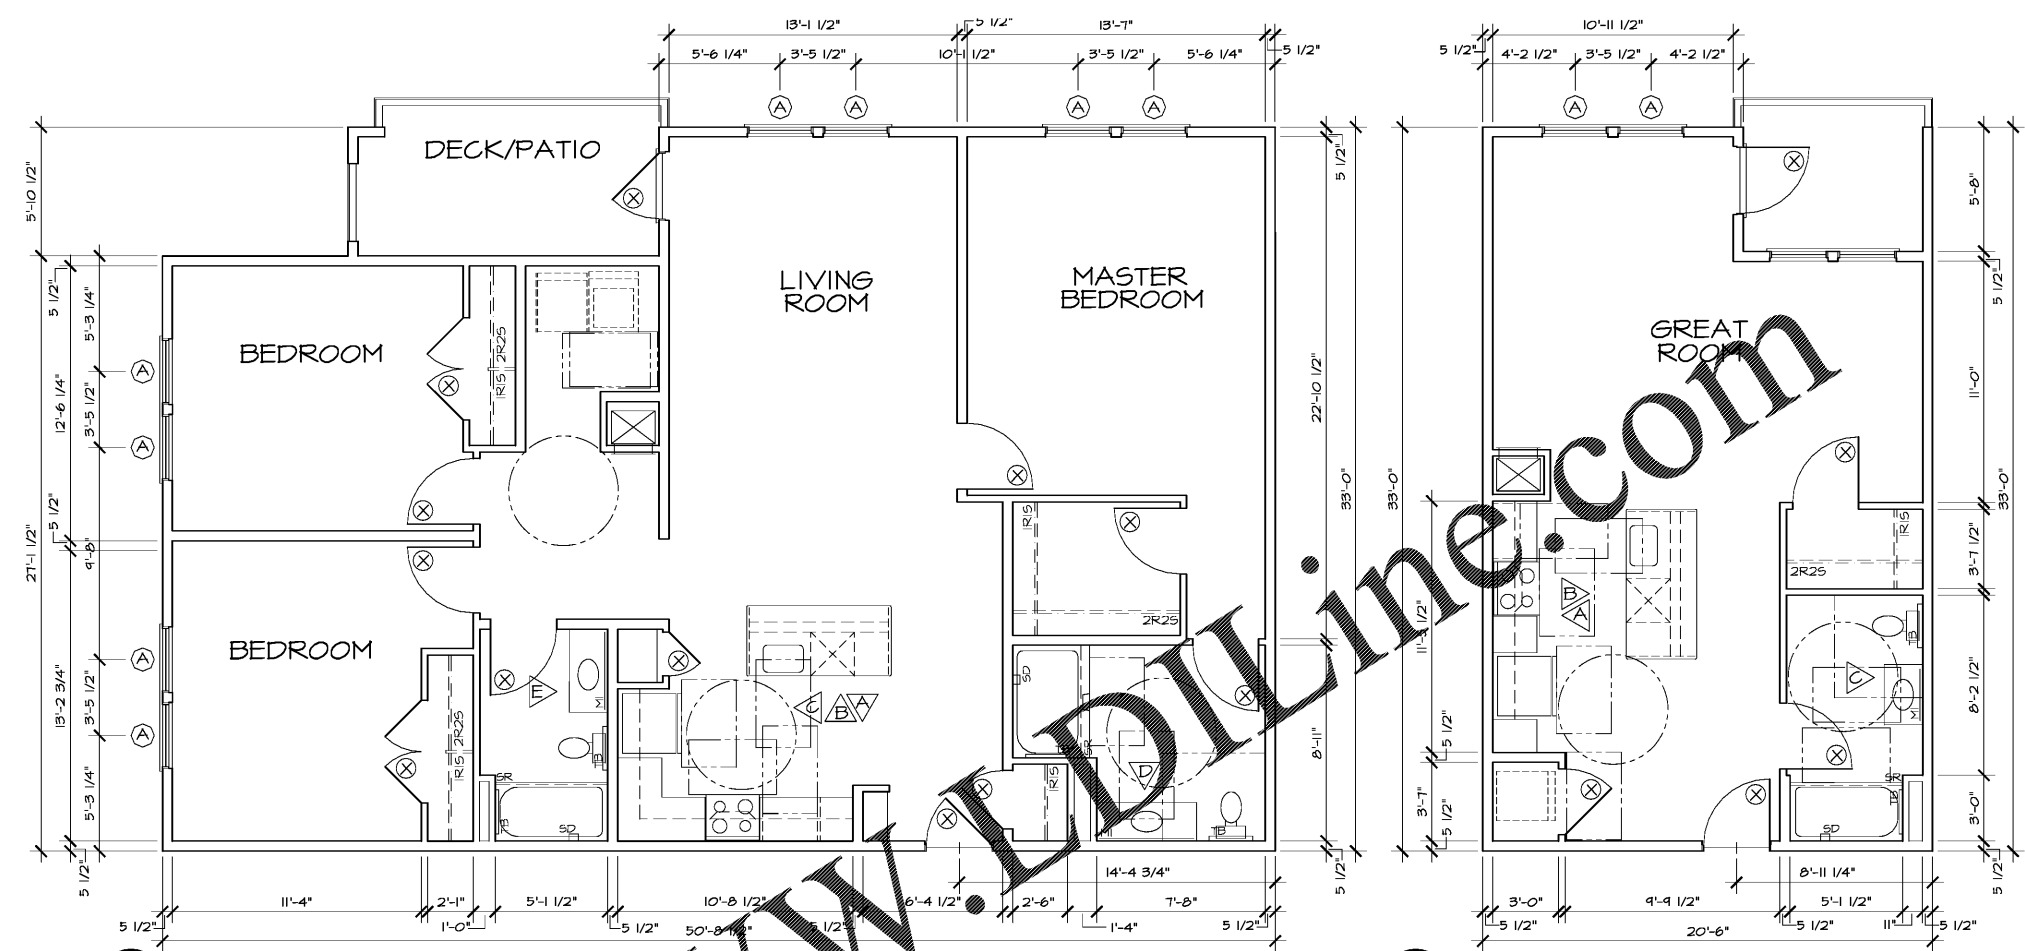


**4 HC UNIT TYPE D1 - FLOOR PLAN**  
 A2.06 1540 HEATED SQ FT / 1638 GROSS SQ FT  
 I.B.C. TYPE 'A' H.C. UNIT - UNIT #105  
 1/4"=1'-0"

**1 HC UNIT TYPE A1 - FLR PLAN**  
 A2.06 628 HEATED SQ FT / 688 GROSS SQ FT  
 I.B.C. TYPE 'A' H.C. UNIT - UNIT #s 50, 99 & 106  
 1/4"=1'-0"

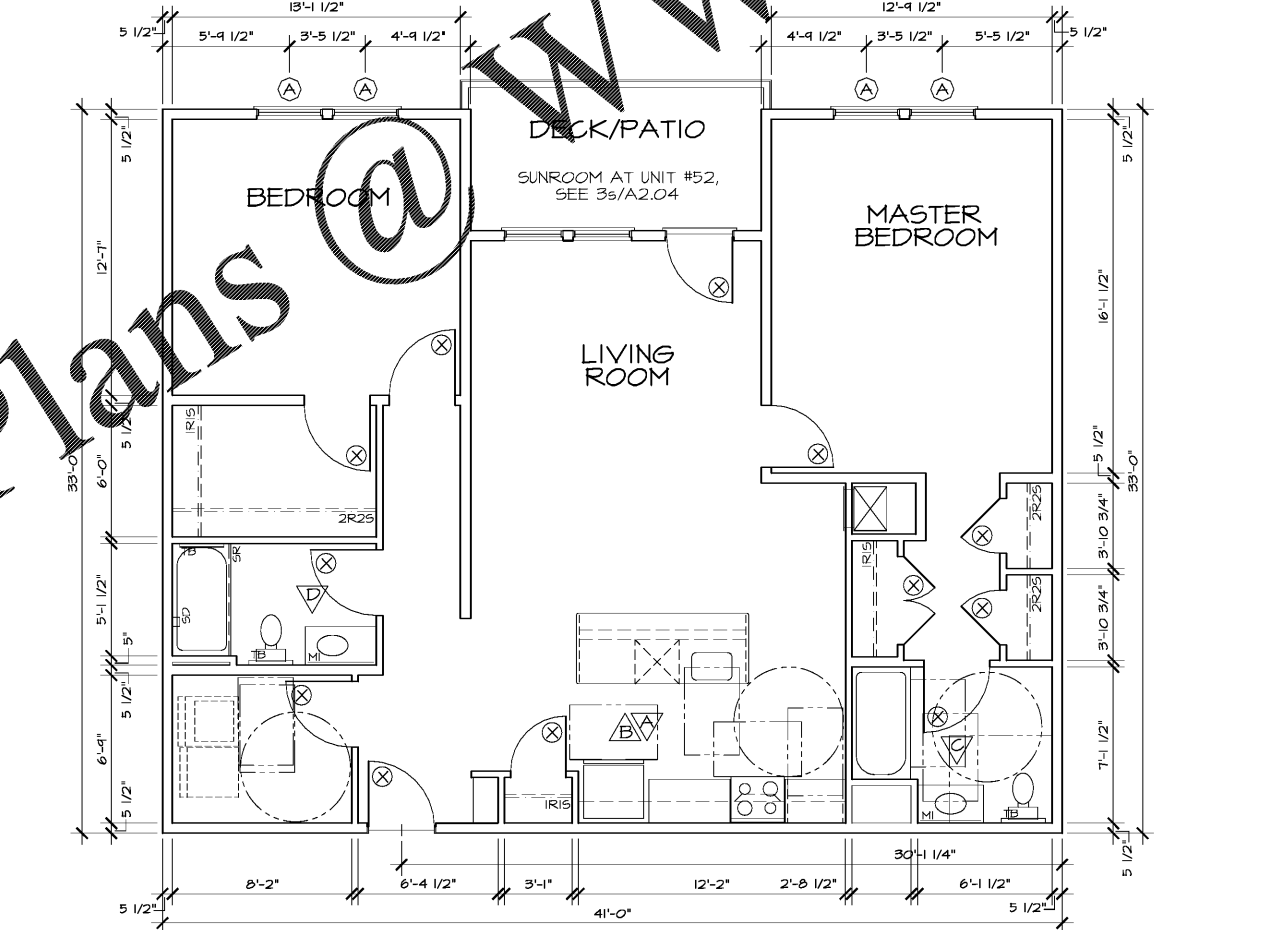

**3 HC UNIT TYPE C3 - FLOOR PLAN**  
 A2.06 1280 HEATED SQ FT / 1369 GROSS SQ FT  
 I.B.C. TYPE 'A' H.C. UNIT - UNIT #s 52 (A C3s UNIT TYPE, SEE 3s/A2.04) & 115  
 1/4"=1'-0"

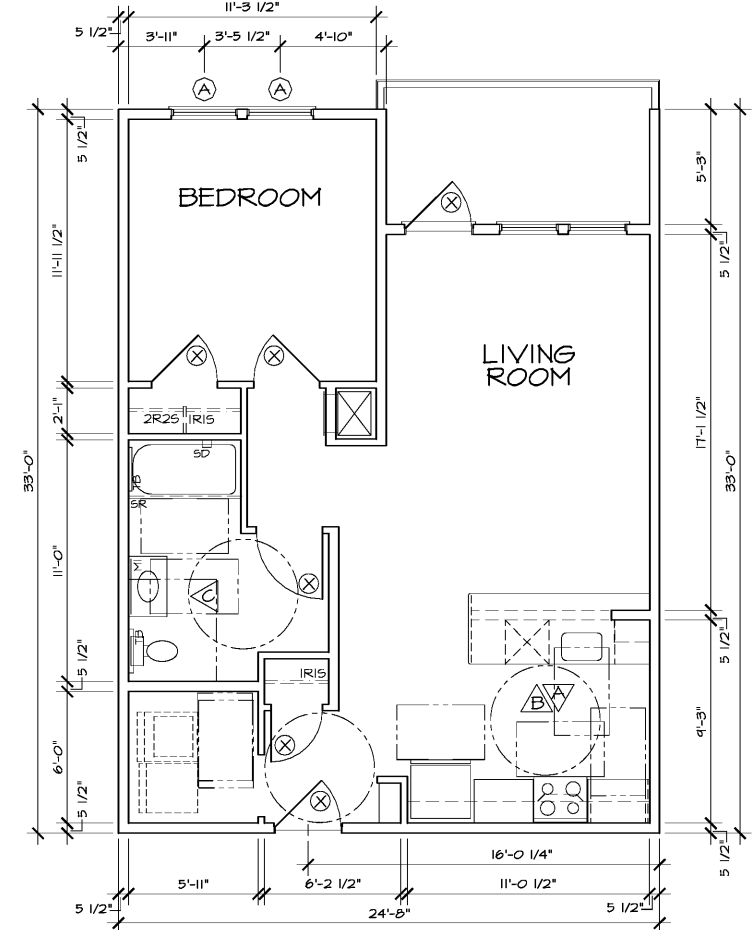

**2 HC UNIT TYPE B1 - FLOOR PLAN**  
 A2.06 741 HEATED SQ FT / 838 GROSS SQ FT  
 I.B.C. TYPE 'A' H.C. UNIT - UNIT #s 17, 59 & 95  
 1/4"=1'-0"

Order Plans @

PROJECT	1915
DATE	30JAN20
DRAWN BY	WJP
CHECKED BY	CMW
HC TYPE 'A' UNIT PLANS AND ELEVATIONS	
<b>A2.06</b>	