


MECHANICAL CONDENSERS, ON DIVERSITECH ISOLATORS, LOCATED IN FLAT ROOF AREAS, SEE A4.08

RIGID INSULATION SLOPED TO DRAINS AT 1/4" PER FOOT

4" DRAINS DOWN TO BELOW SLAB - COOR. W/PLUMBING SHEETS

4" OVERFLOW DRAINS IN FLAT ROOF MECHANICAL WELLS - RUN TO BUILDING SOFFIT - NOT OVER PECKS AND AT LEAST 12" AWAY FROM ABOVE WINDOWS

COMP. SHINGLES ON 15# FELT ON 5/8" ROOF SHEATHING W/CLIPS. PROVIDE METAL GANT DAM TO LAP OVER CEVEN. TRIM
PNTD. CEVENTICIOUS SIDING ON HOUSE WRAP ON 5/8" EXT SIDING ATTACHED TO PREFAB ROOF TRUSSES PER STRUCTURAL MEMBER MECHANICALLY FASTENED 60 MIL TPO MEMBRANE OVER POLYISO INSULATION. RUN TPO 2'-0" UP VERTICAL LEG OF TRUSS

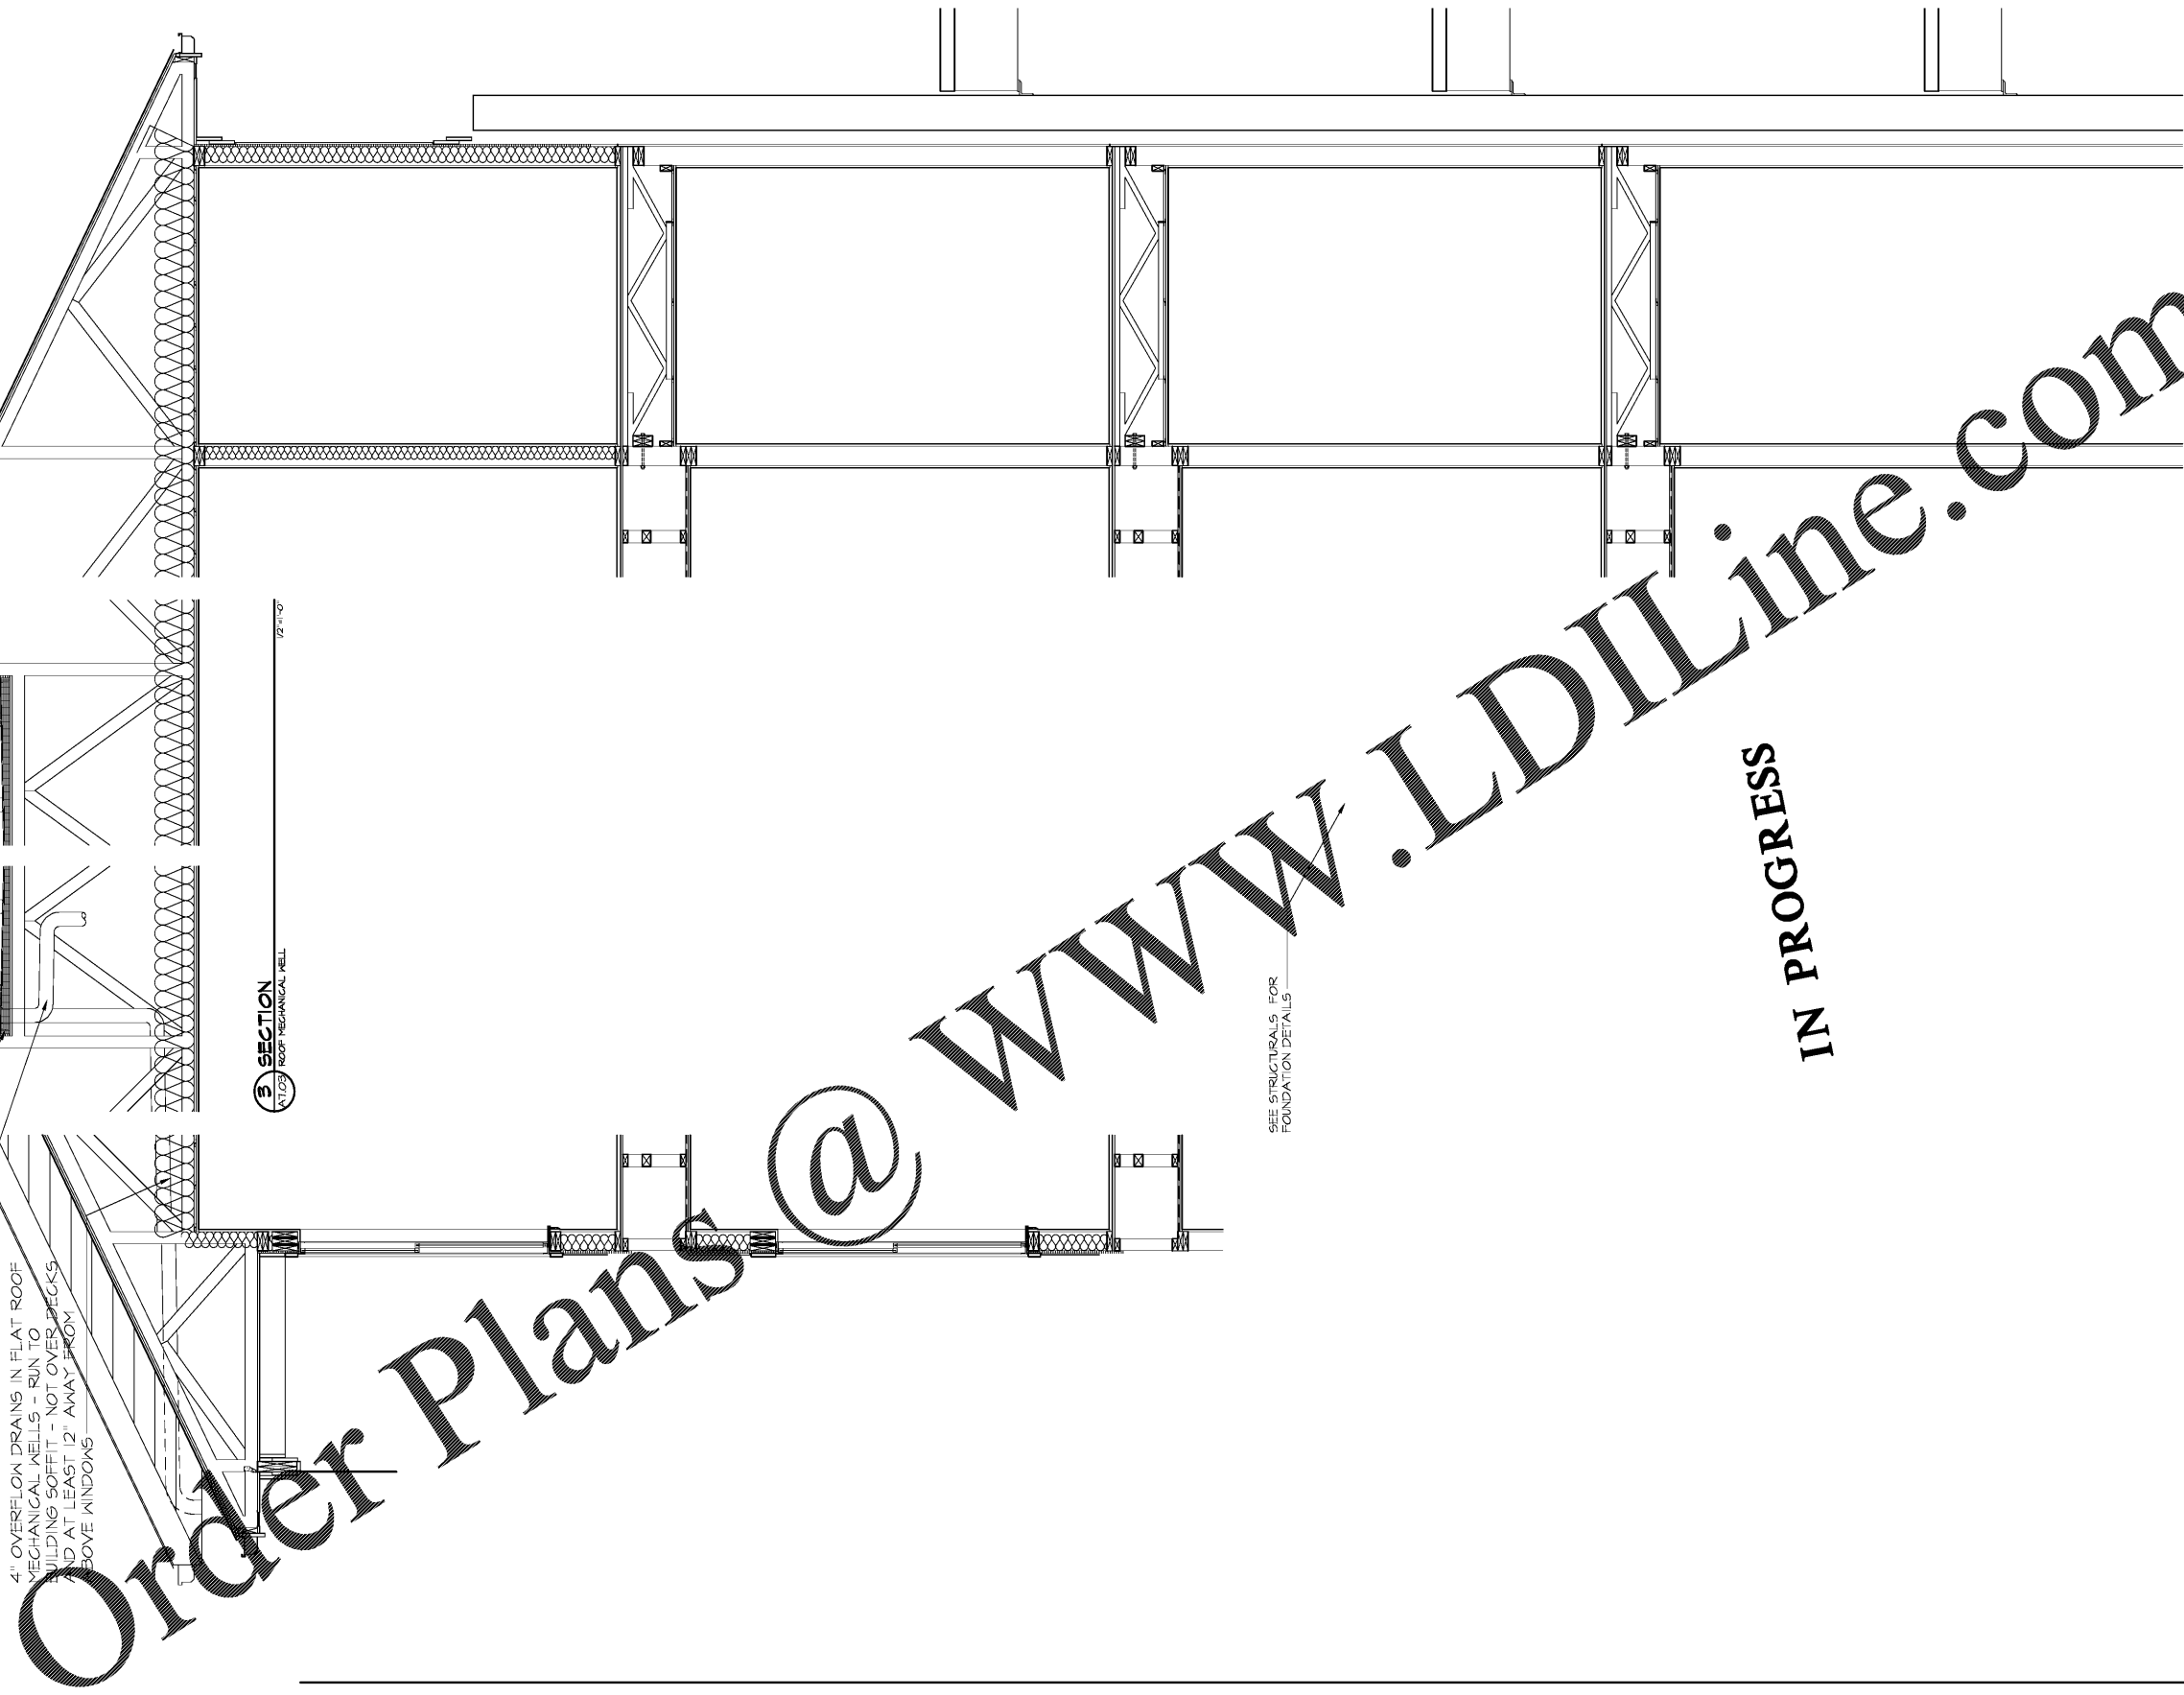

SEE STRUCTURALS FOR FOUNDATION DETAILS

IN PROGRESS

2 SECTION AT 03

1 SECTION AT 03

PROJECT 1915
DATE 14JAN20
DRAWN BY WJP
CHECKED BY CMW

WALL SECTIONS

A7.03

CRABTREE NORTH APTS.

2251 Charles Drive
Raleigh, North Carolina
EYC COMPANIES

