



Structural Consulting Group, LLC
 6250 shiloh road - suite 20 - alpharetta, ga 30005
 phone (678) 513-4242 fax (678) 513-4232
 SCG Project No. 191003
 N.C. C.O.A.: P-0573

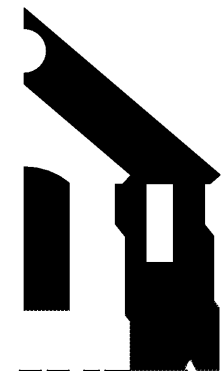

WLA
 WATTS LEAF ARCHITECTS, PA
 371 North McDowell Street, Suite 102
 Charlotte, North Carolina 28204
 PH 704 876 1800 FX 704 876 6111

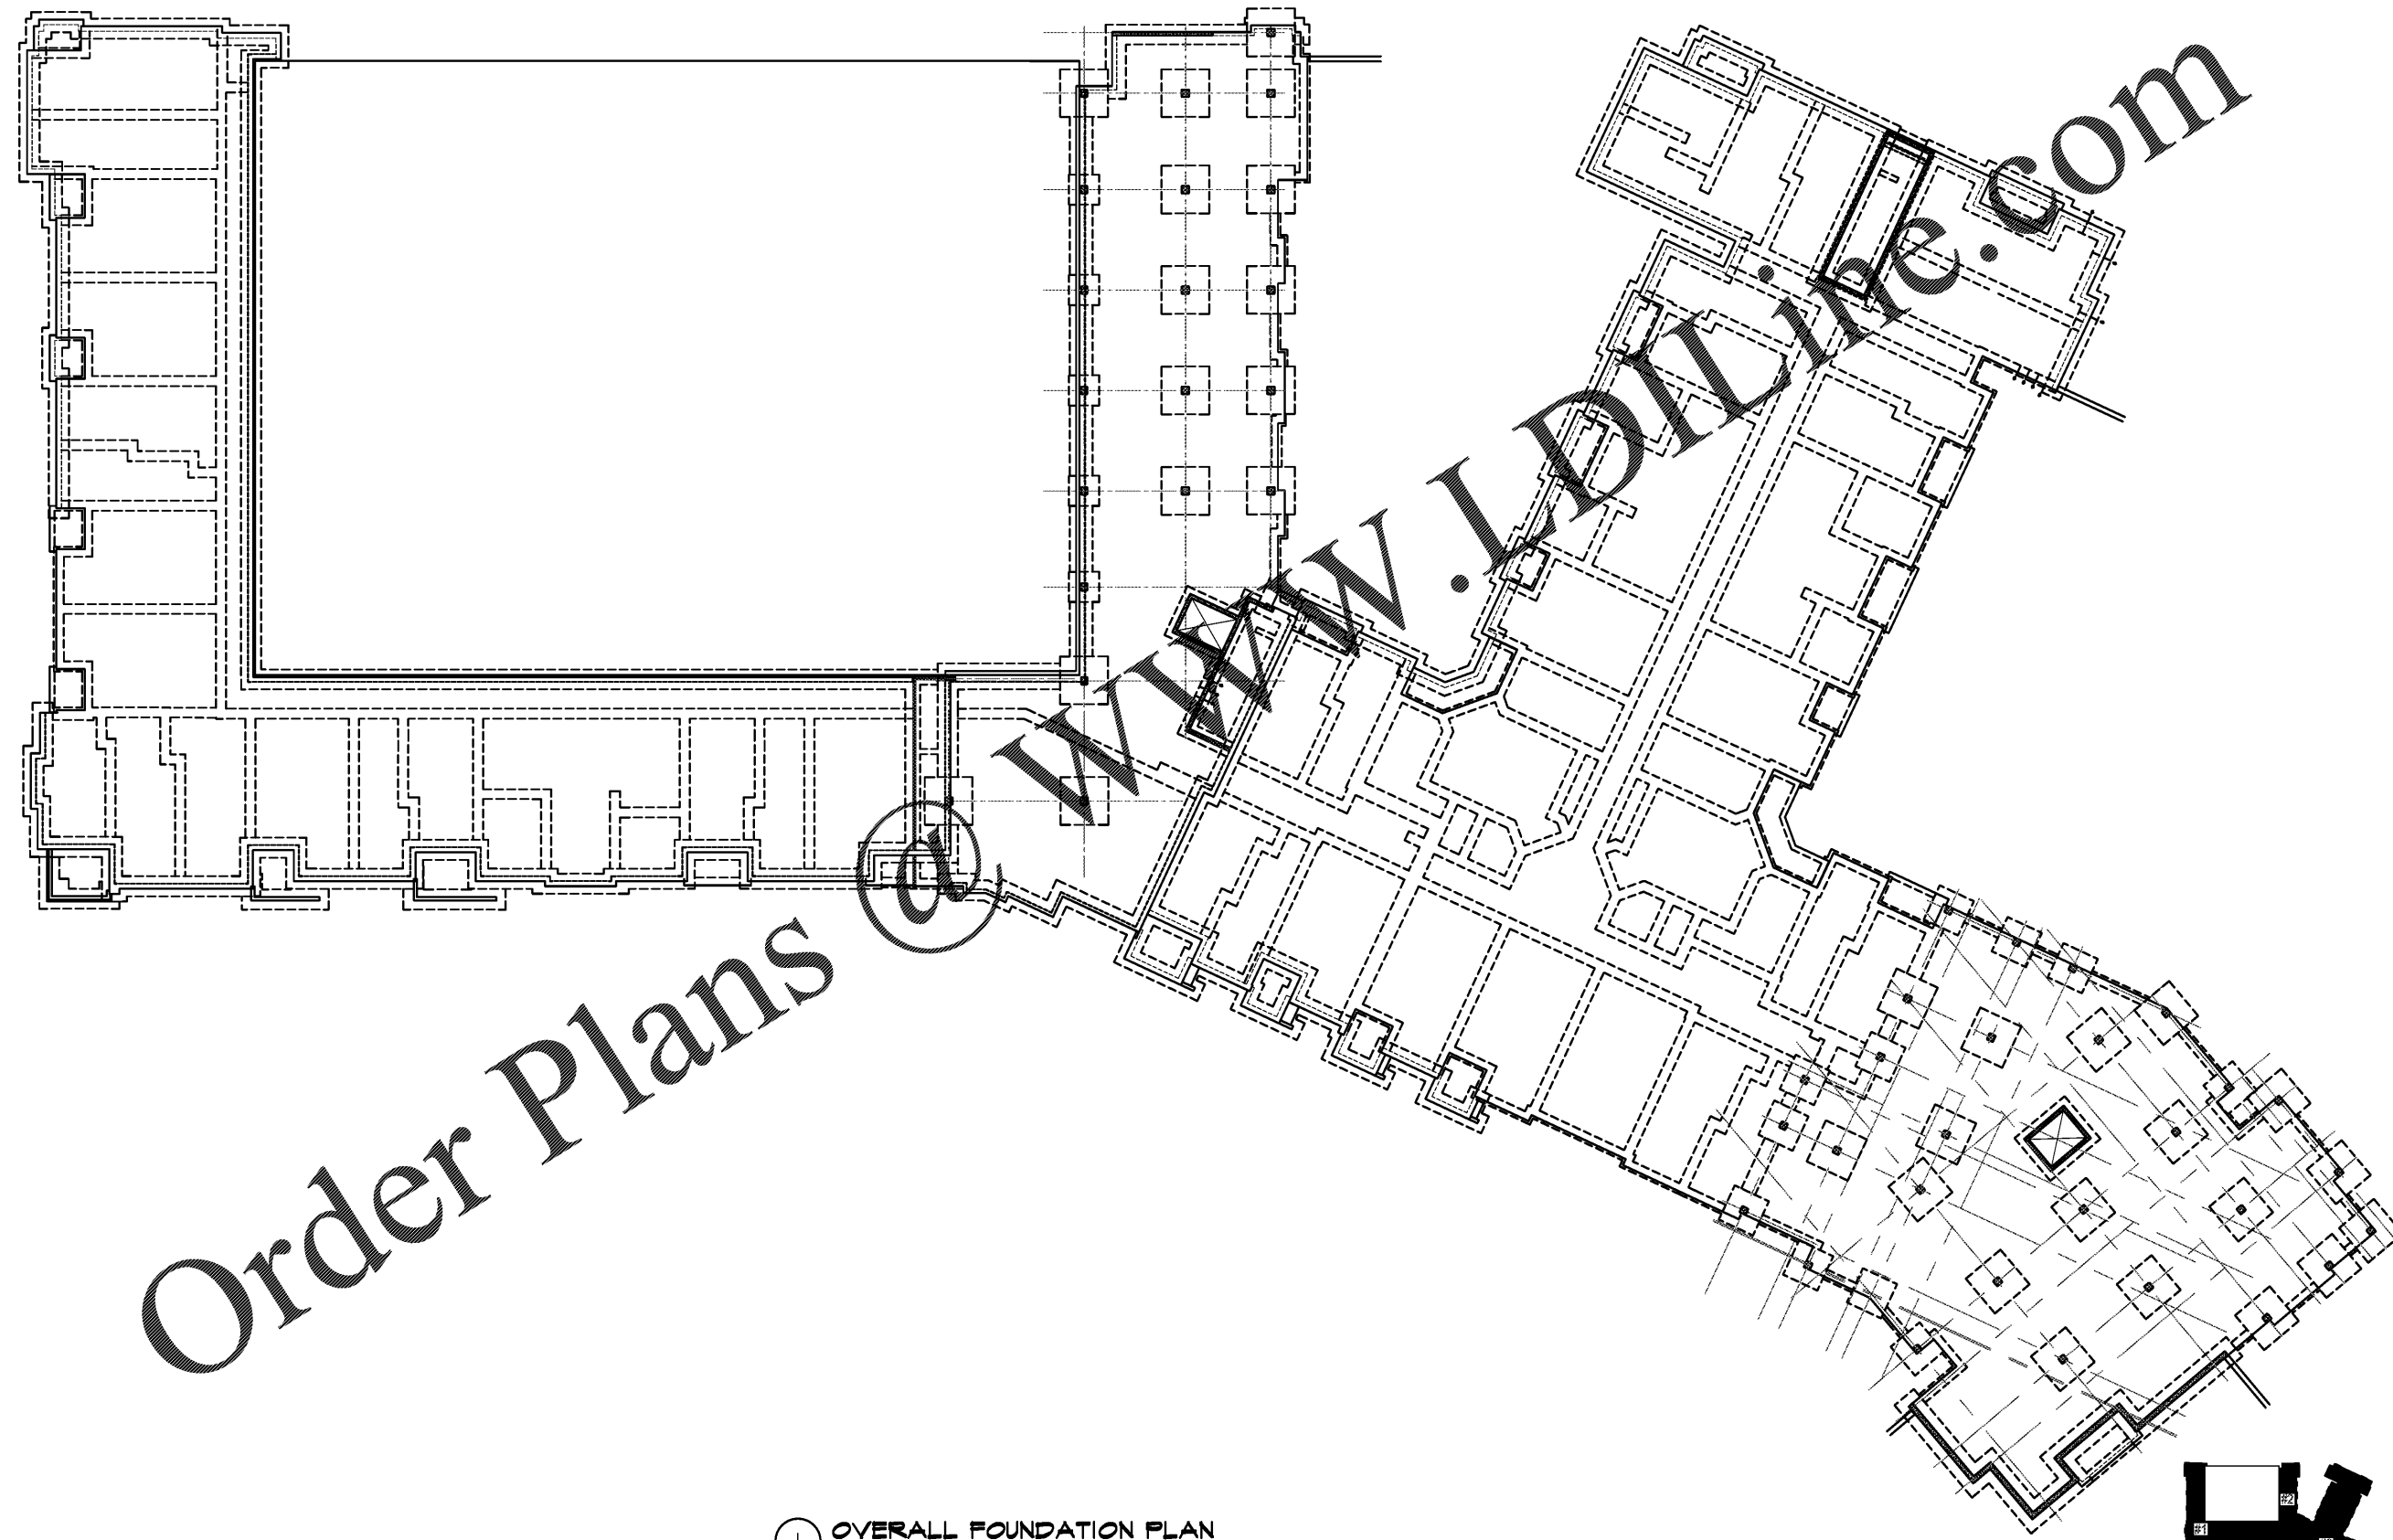

Order Plans

CRABTREE NORTH APTS.

2251 Charles Drive
 Raleigh, North Carolina
 EYC COMPANIES

03FEB20
 PRICING
 SET

PROJECT 1915
 DATE 06NOV19
 DRAWN BY SCG
 CHECKED BY F80

OVERALL FOUNDATION
 PLAN

S2.1.0

1 OVERALL FOUNDATION PLAN
 SCALE: 1/8" = 1'-0"

