
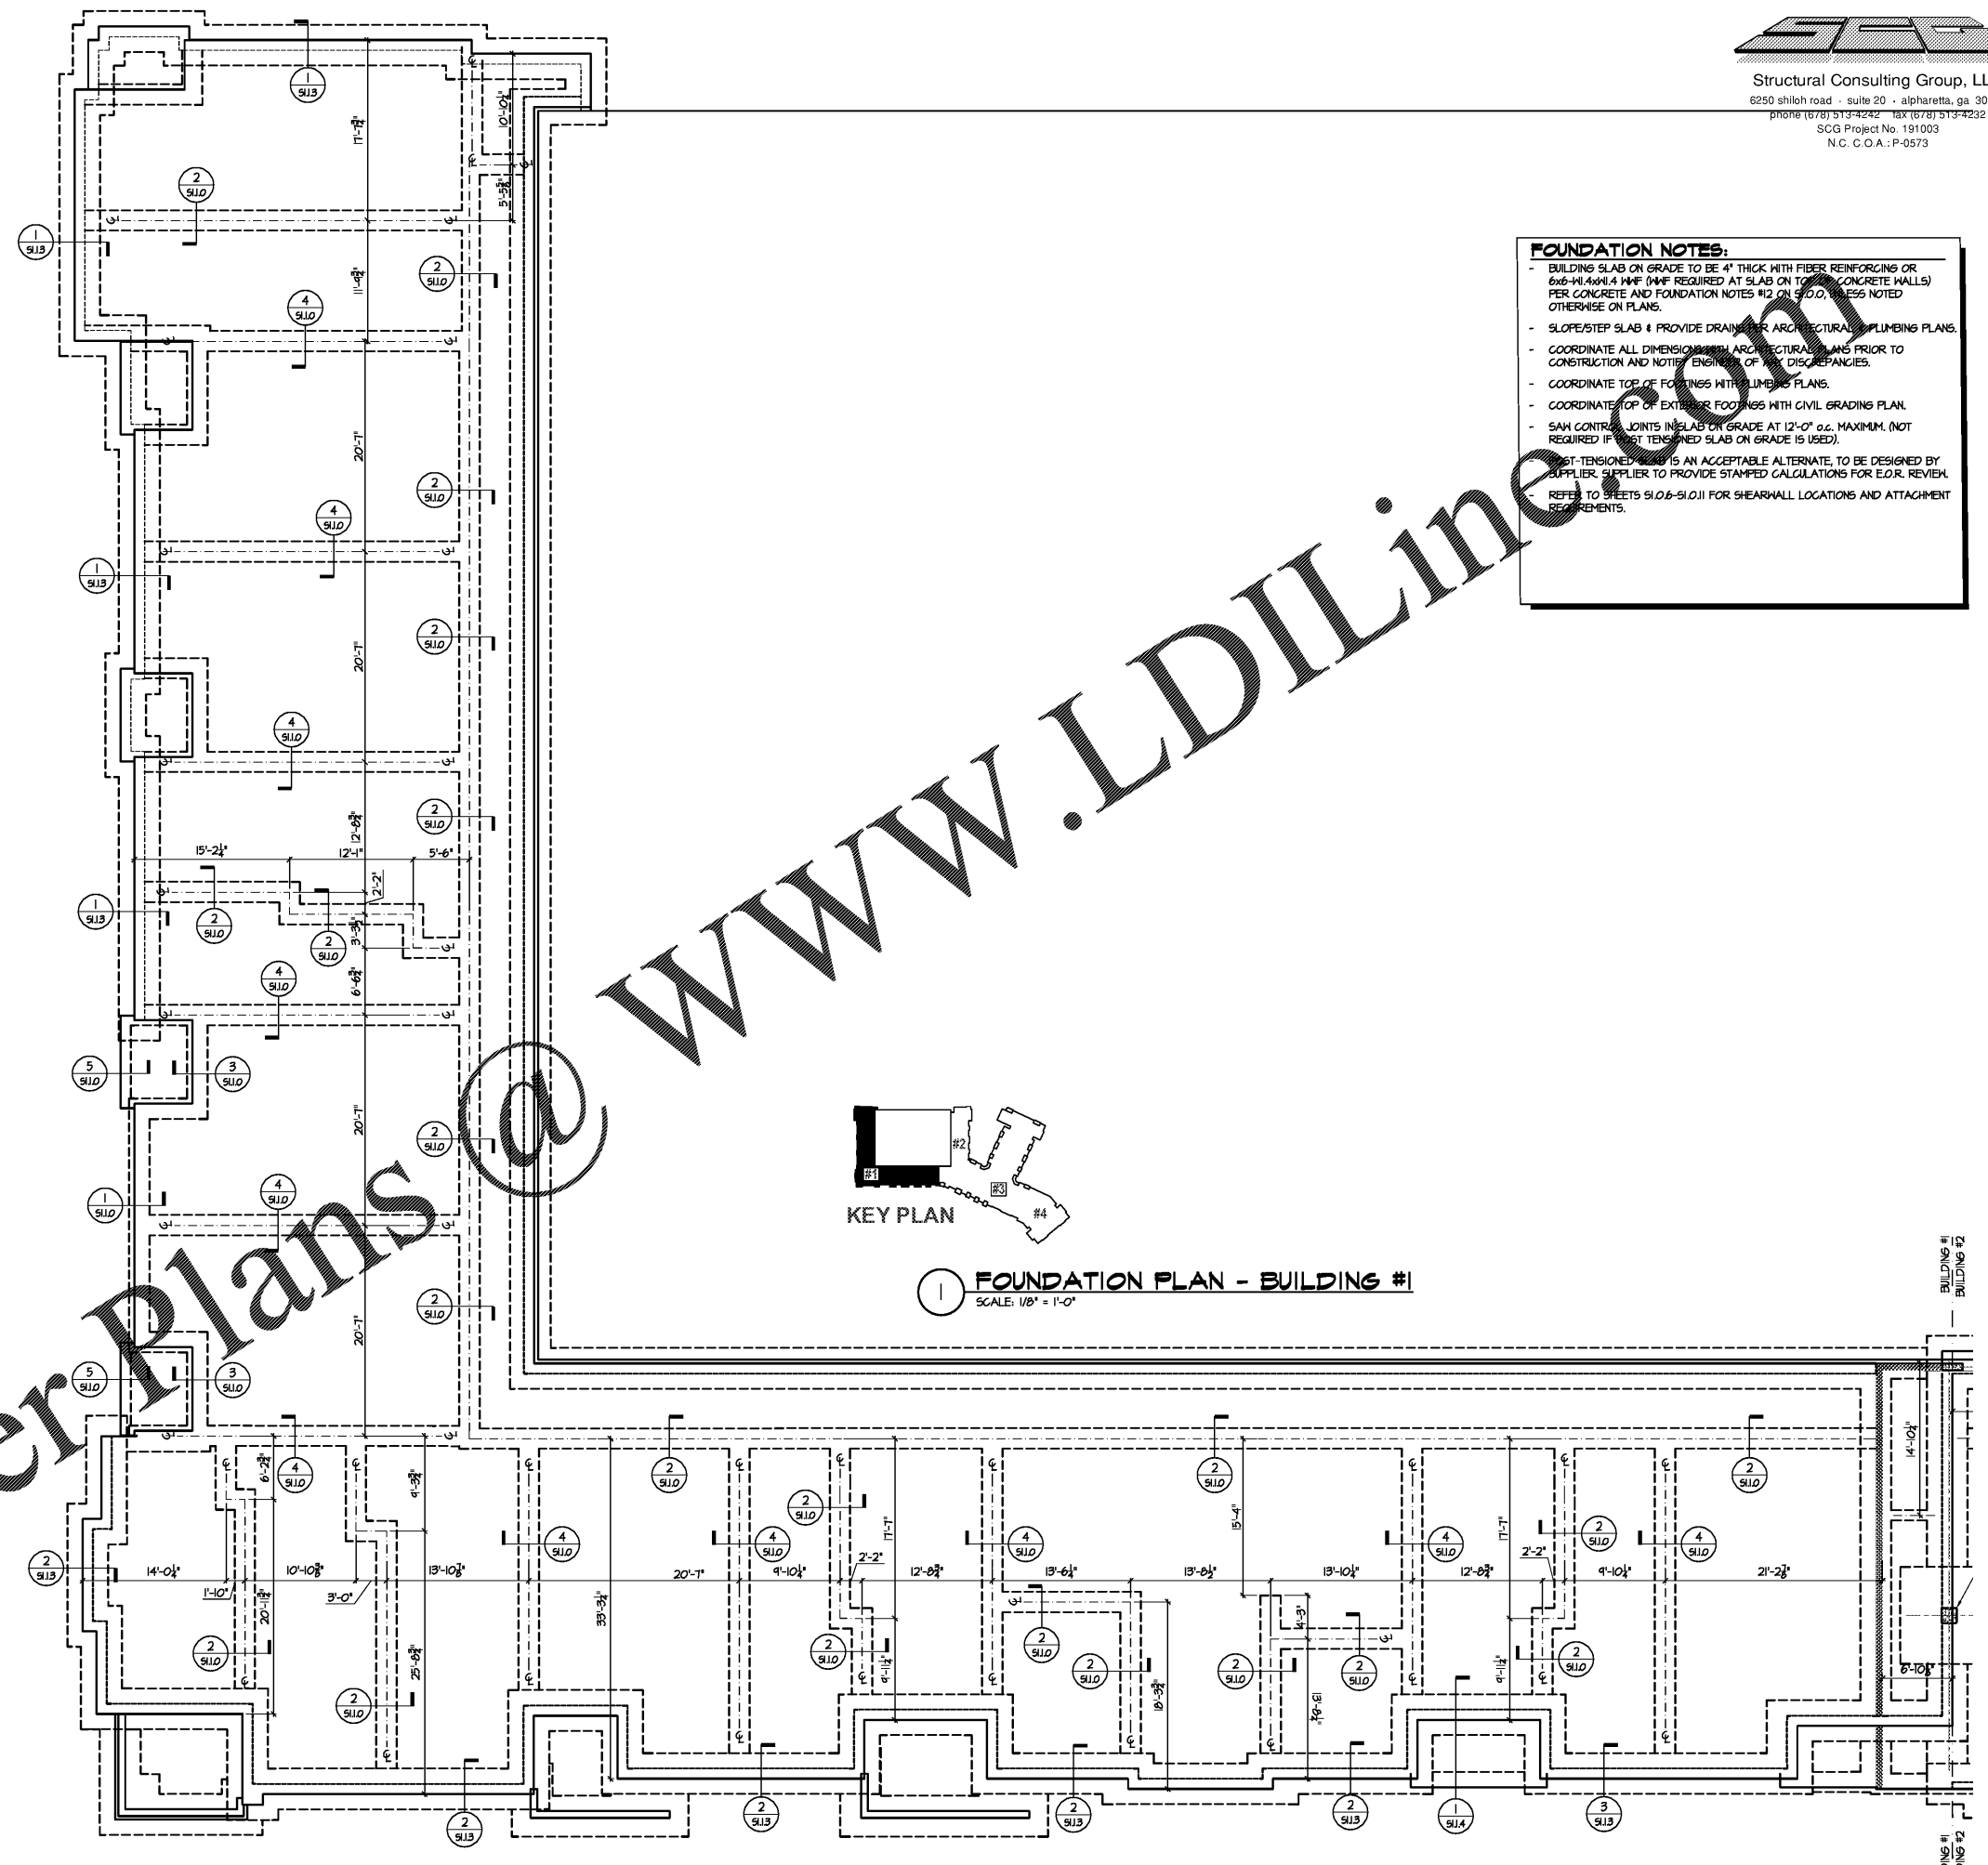


**FOUNDATION NOTES:**

- BUILDING SLAB ON GRADE TO BE 4" THICK WITH FIBER REINFORCING OR 6x6-W-4x4-4 MMF (MMF REQUIRED AT SLAB ON TOP OF CONCRETE WALLS) PER CONCRETE AND FOUNDATION NOTES #12 ON S.I.O., UNLESS NOTED OTHERWISE ON PLANS.
- SLOPE/STEP SLAB & PROVIDE DRAINAGE FOR ARCHITECTURAL/PLUMBING PLANS.
- COORDINATE ALL DIMENSIONS WITH ARCHITECTURAL PLANS PRIOR TO CONSTRUCTION AND NOTIFY ENGINEER OF ANY DISCREPANCIES.
- COORDINATE TOP OF FOOTINGS WITH PLUMBING PLANS.
- COORDINATE TOP OF EXTERIOR FOOTINGS WITH CIVIL GRADING PLAN.
- SAW CONTROL JOINTS IN SLAB ON GRADE AT 12'-0" o.c. MAXIMUM. (NOT REQUIRED IF POST-TENSIONED SLAB ON GRADE IS USED).
- POST-TENSIONING IS AN ACCEPTABLE ALTERNATE TO BE DESIGNED BY SUPPLIER. SUPPLIER TO PROVIDE STAMPED CALCULATIONS FOR E.O.R. REVIEW.
- REFER TO SHEETS S.I.O.6-S.I.O.11 FOR SHEARWALL LOCATIONS AND ATTACHMENT REQUIREMENTS.

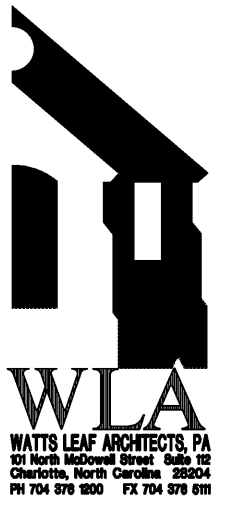

Order Plans @

WWW.LDILine.com

**CRABTREE NORTH APTS.**  
 2251 Charles Drive  
 Raleigh, North Carolina  
 EYC COMPANIES

**03FEB20  
 PRICING  
 SET**

PROJECT 1915  
 DATE 06NOV19  
 DRAWN BY SCG  
 CHECKED BY F80

FOUNDATION PLAN -  
 BUILDING #1

**S2.1.1**