





Structural Consulting Group, LLC
 6250 shiloh road - suite 20 - alpharetta, ga 30005
 phone (678) 513-4242 fax (678) 513-4232
 SCG Project No. 191003
 N.C. C.O.A.: P-0573

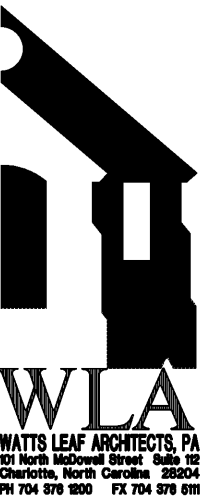


WLA
 WATTS LEAF ARCHITECTS, PA
 171 North McDowell Street, Suite 102
 Charlotte, North Carolina 28204
 PH 704 376 1800 FX 704 376 6111

Order Plans @ www.LDILine.com

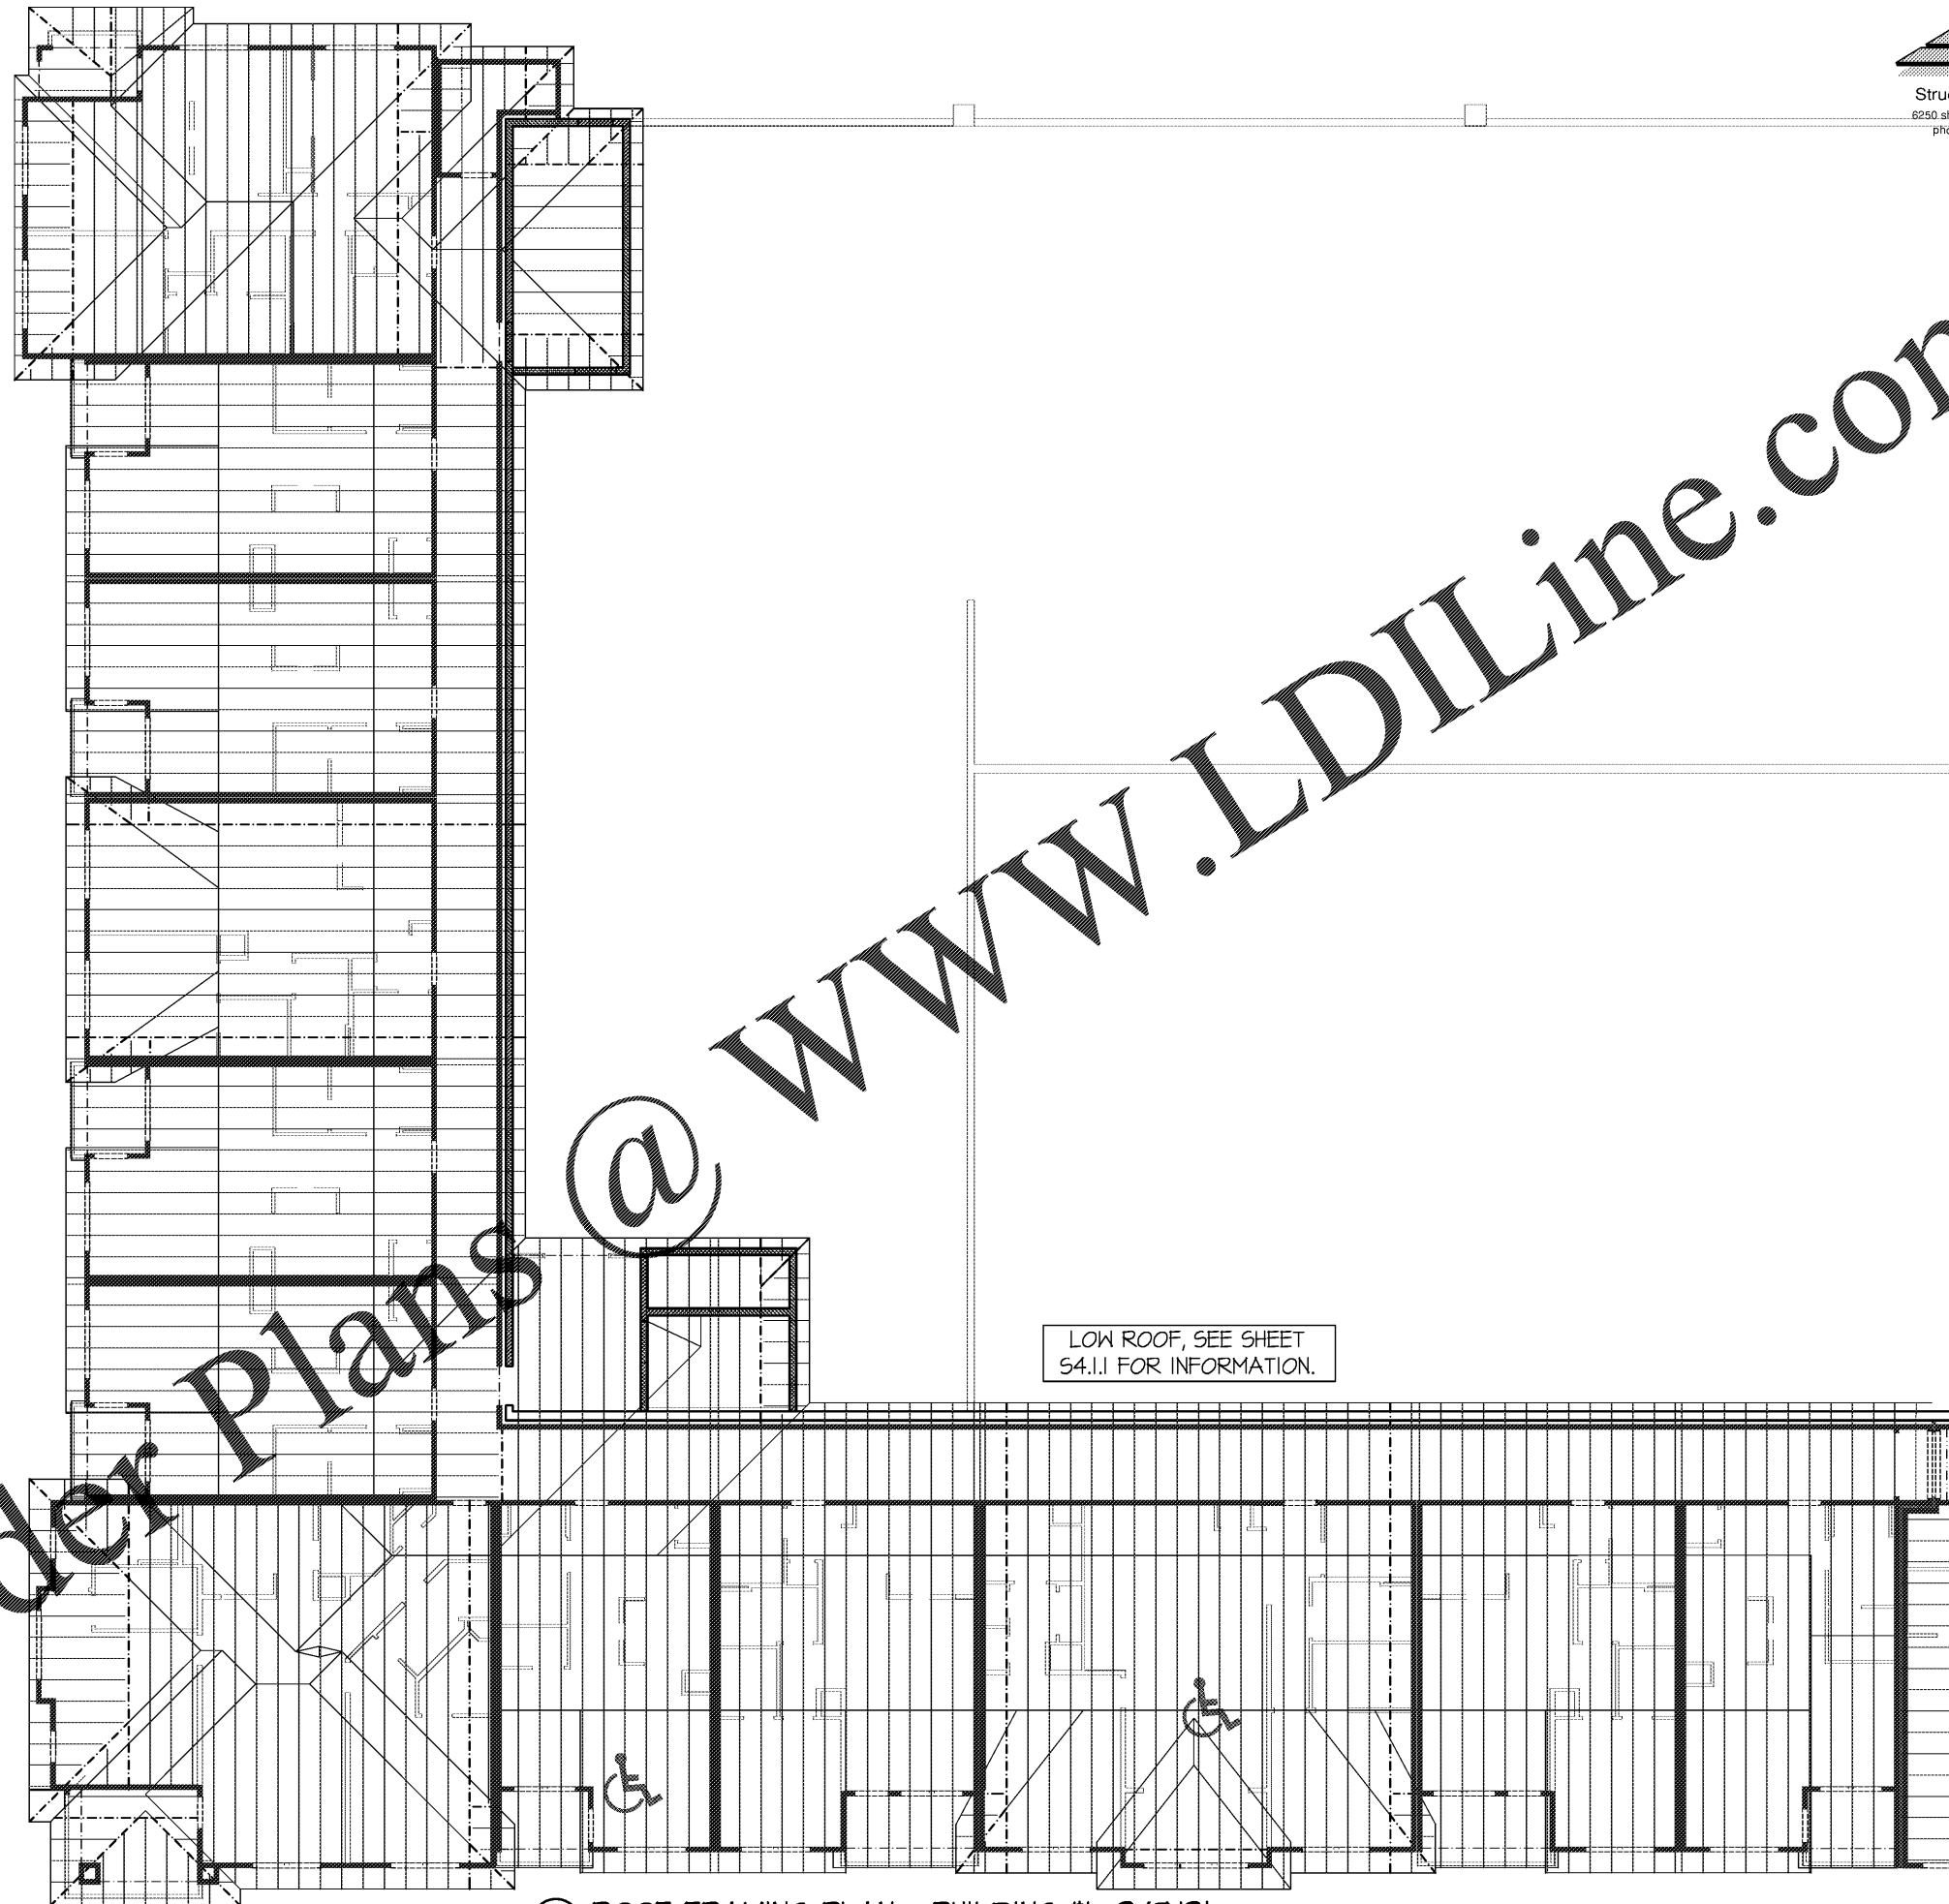

LOW ROOF, SEE SHEET
 S4.1.I FOR INFORMATION.

1 ROOF FRAMING PLAN - BUILDING #- 347.13'
 SCALE: 1/8" = 1'-0"

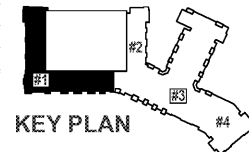

KEY PLAN

CRABTREE NORTH APTS.
 2251 Charles Drive
 Raleigh, North Carolina
 EYC COMPANIES

03FEB20
 PRICING
 SET

PROJECT 1915
 DATE 06NOV19
 DRAWN BY SCG
 CHECKED BY F80

ROOF FRAMING PLAN -
 BUILDING #1- 347.13'

S3.5.1