




1 UNIT A1 HC PLUMBING PLAN
1/4" = 1'-0"

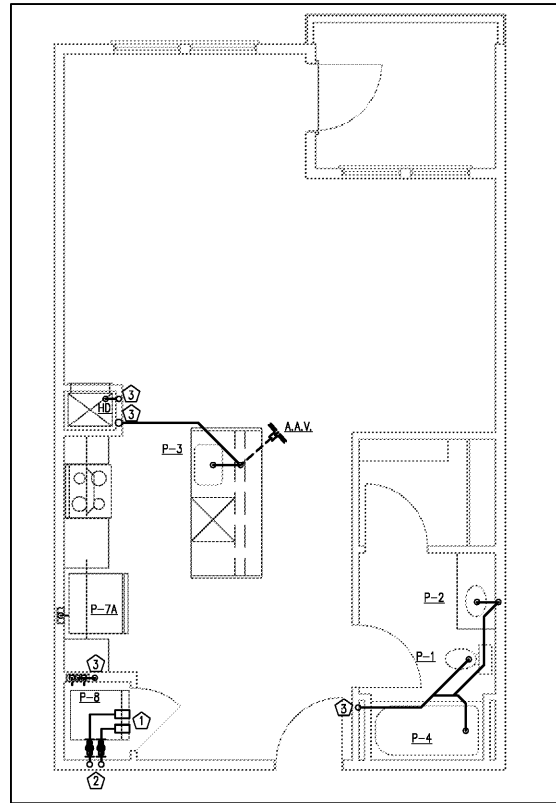


2 UNIT A1 PLUMBING PLAN
1/4" = 1'-0" (UNIT A1F, A2, A2E, A3, A3L, A3R, A4, A4J, A5, A5J, A6 & A6J SIMILAR)

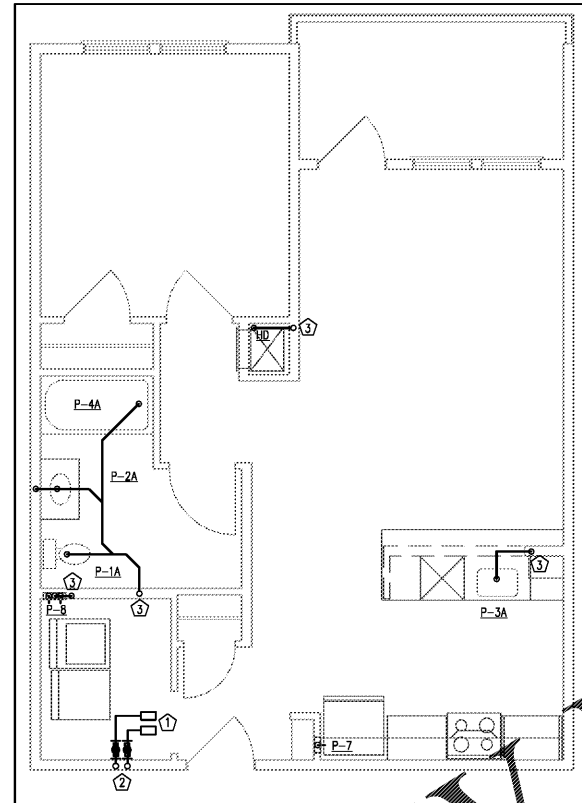


3 UNIT B1 HC PLUMBING PLAN
1/4" = 1'-0"

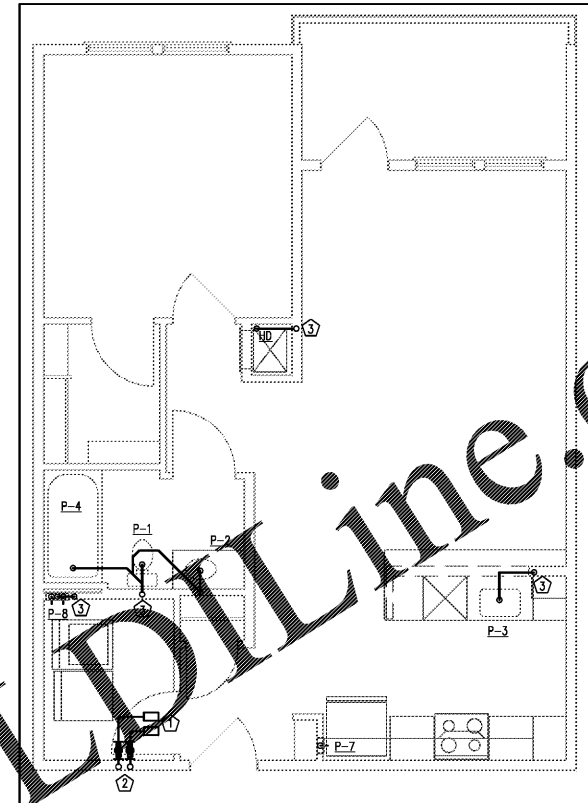


4 UNIT B1 PLUMBING PLAN
1/4" = 1'-0" (UNIT B1F, B2, B2F, B3, B3L & B3R SIMILAR)

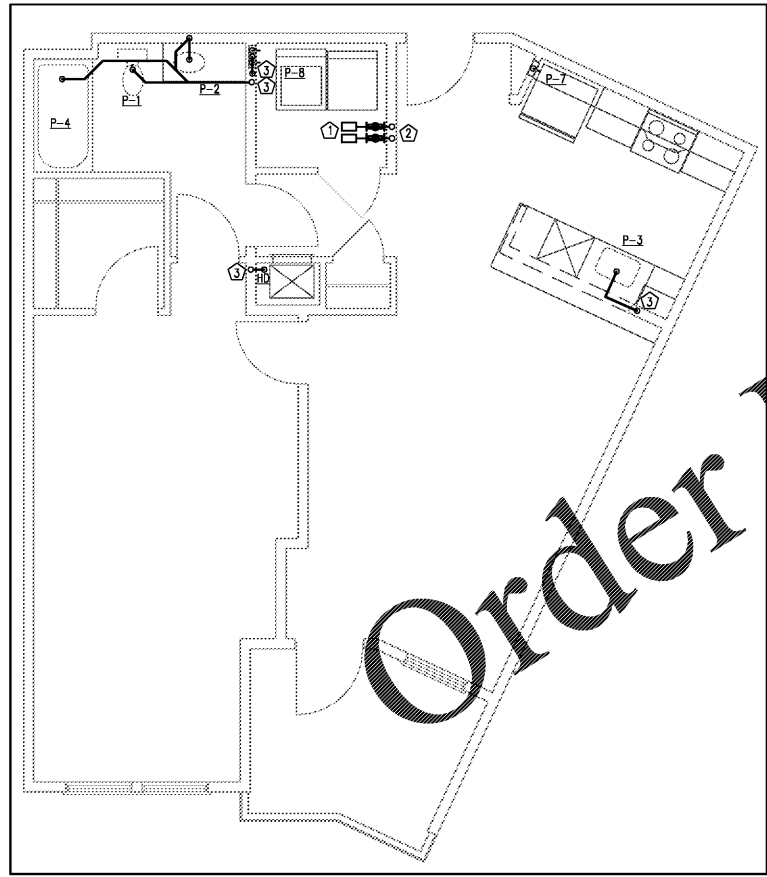

5 UNIT B4 PLUMBING PLAN
1/4" = 1'-0" (UNIT B4S & B4SJ SIMILAR)

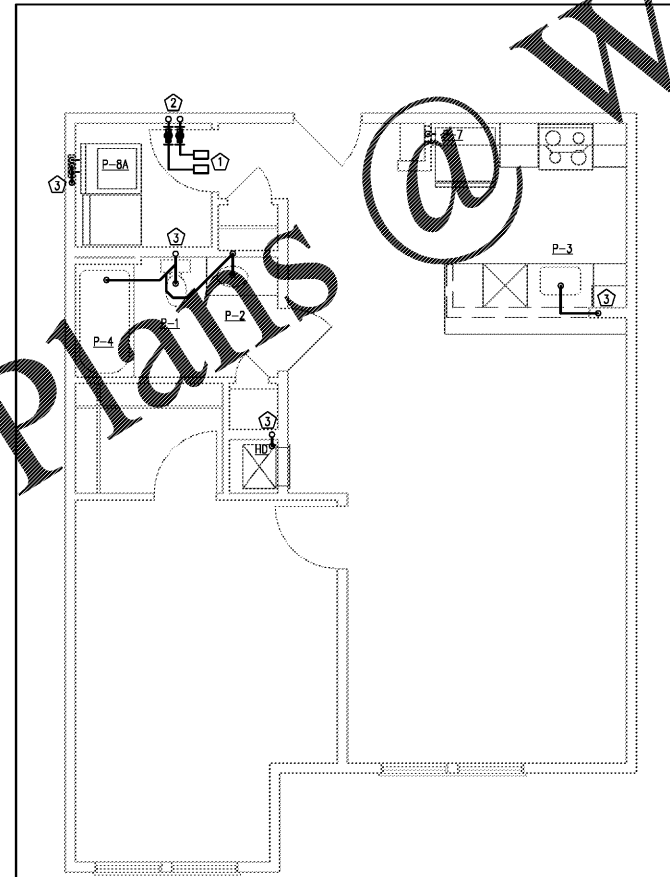

6 UNIT B5 PLUMBING PLAN
1/4" = 1'-0" (UNIT B5J SIMILAR)

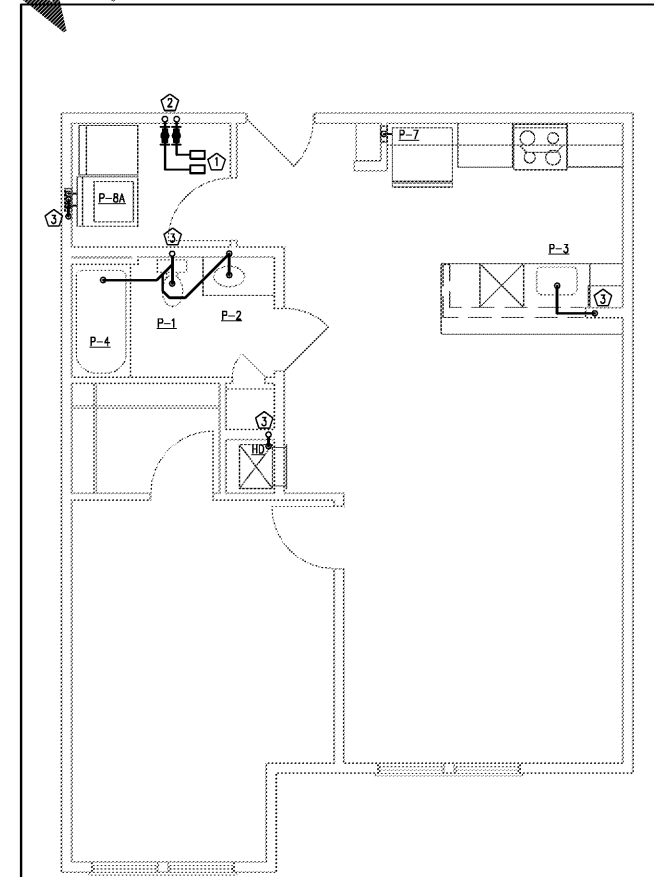


6 UNIT B5A PLUMBING PLAN
1/4" = 1'-0" (UNIT B5AJ SIMILAR)

KEYED NOTES

- ① HOT WATER & COLD WATER PEX DISTRIBUTION MANIFOLDS LOCATED IN CEILING. P.C. TO FIELD VERIFY & DETERMINE EXACT LOCATION. SEE PEX MANIFOLD DIAGRAM ON SHEET P1.2 FOR ADDITIONAL INFORMATION.
- ② WATER RISER. SEE OVERALL BLDG. PLAN FOR RISER DIAGRAM NUMBER.
- ③ WASTE OR STORM STACK. SEE OVERALL BLDG. PLAN FOR RISER DIAGRAM NUMBER.

NOTES THIS SHEET

1. SEE SHEET P1.1 FOR FIXTURE SCHEDULE AND CONNECTION SIZES.
2. ALL WATER SUPPLY LINES IN AN EXTERIOR WALL SHALL BE RUN ON INTERIOR SIDE OF WALL INSULATION.
3. PROVIDE SHUTOFF VALVE IN EACH UNIT IN AN ACCESSIBLE LOCATION THAT CONTROLS ALL WATER SUPPLY TO THAT UNIT.
4. ALL WATER PIPING IS 1/2" UNLESS OTHERWISE NOTED.
5. PROVIDE ALL REQUIRED PLUMBING CONNECTIONS FOR DISHWASHER (IF APPLICABLE) PER MFR. RECOMMENDATIONS.

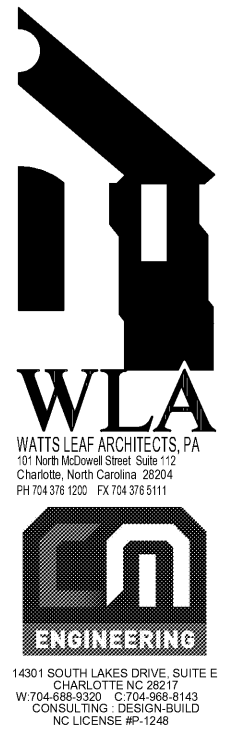

CRABTREE NORTH APTS.
2251 Charles Drive
Raleigh, North Carolina
EYC COMPANIES

PROJECT 1915
DATE 01OCT19
DRAWN BY CME
CHECKED BY CME
UNIT PLUMBING PLANS

P2.01