




1 UNIT B6 PLUMBING PLAN
 1/4" = 1'-0" (UNIT B6J SIMILAR)

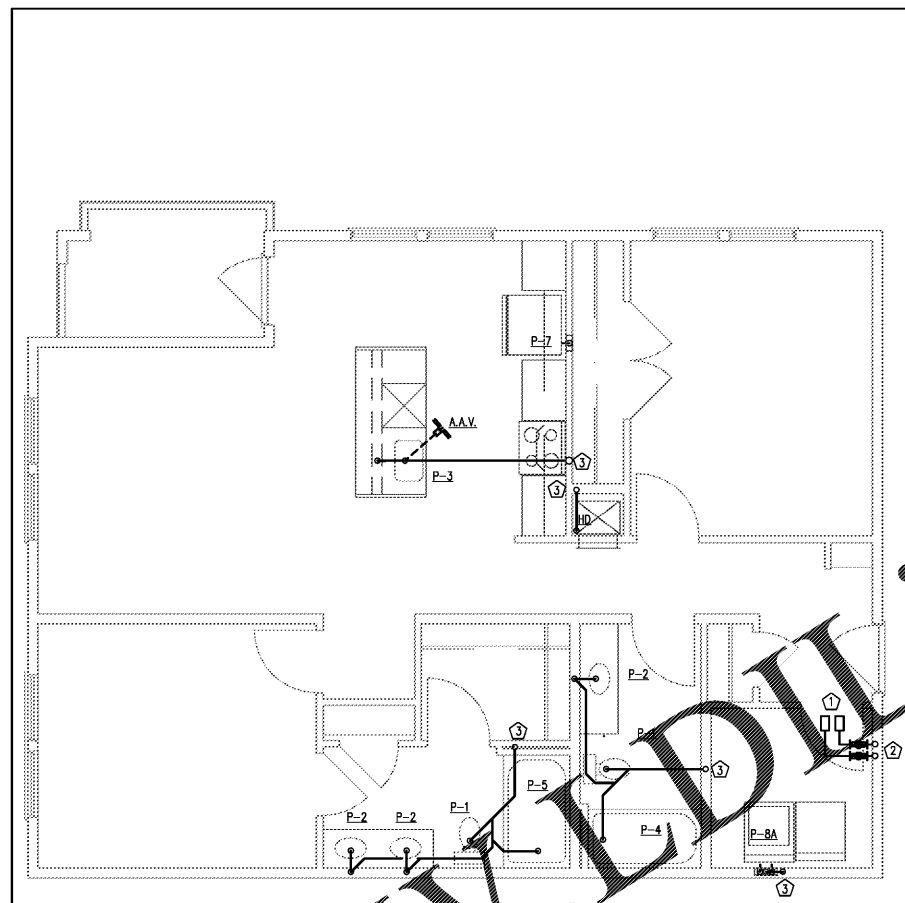

2 UNIT C1 PLUMBING PLAN
 1/4" = 1'-0"

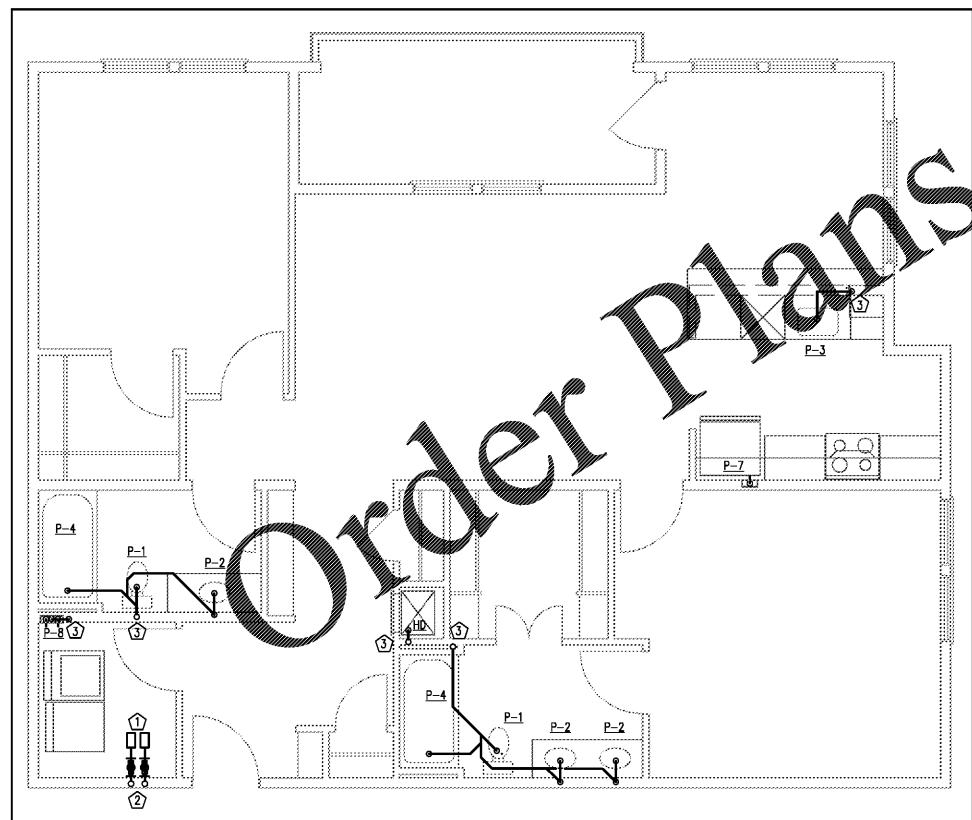

3 UNIT C2 PLUMBING PLAN
 1/4" = 1'-0" (UNIT C2E SIMILAR)

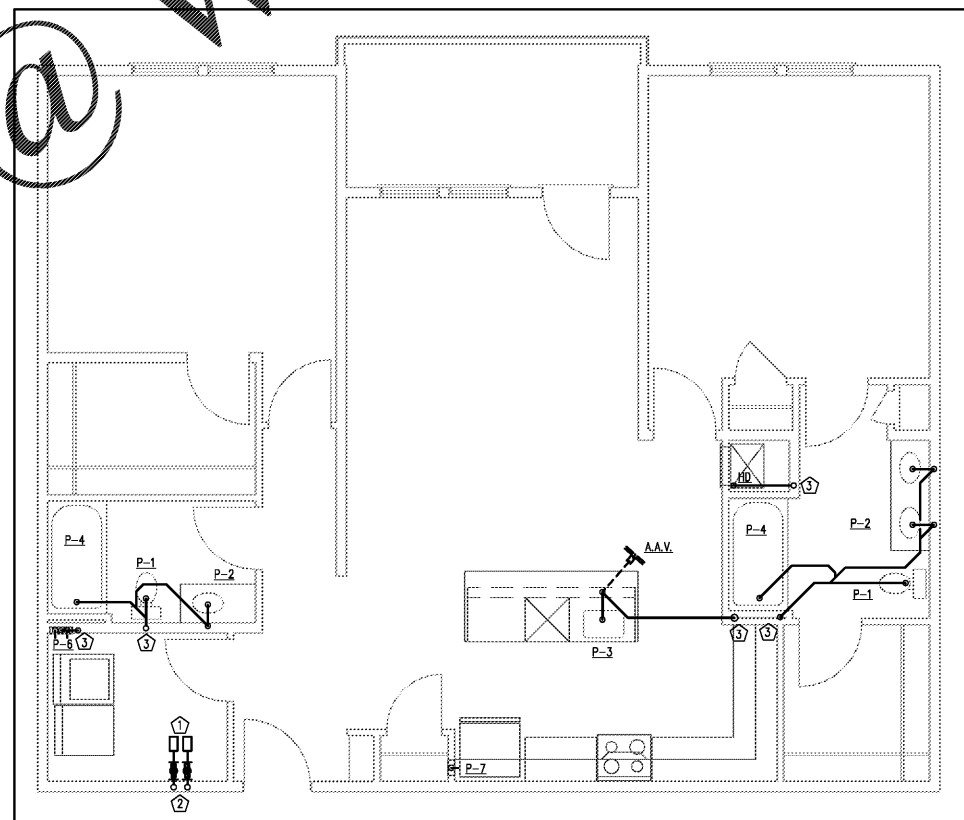

6 UNIT C3 PLUMBING PLAN
 1/4" = 1'-0" (UNIT C3S & C4 SIMILAR)

KEYED NOTES	
①	HOT WATER & COLD WATER PEX DISTRIBUTION MANIFOLDS LOCATED IN CEILING. P.C. TO FIELD VERIFY & DETERMINE EXACT LOCATION. SEE PEX MANIFOLD DIAGRAM ON SHEET P1.2 FOR ADDITIONAL INFORMATION.
②	WATER RISER. SEE OVERALL BLDG. PLAN FOR RISER DIAGRAM NUMBER.
③	WASTE OR STORM STACK. SEE OVERALL BLDG. PLAN FOR RISER DIAGRAM NUMBER.

NOTES THIS SHEET	
1.	SEE SHEET P1.1 FOR FIXTURE SCHEDULE AND CONNECTION SIZES.
2.	ALL WATER SUPPLY LINES IN AN EXTERIOR WALL SHALL BE RUN ON INTERIOR SIDE OF WALL INSULATION.
3.	PROVIDE SHUTOFF VALVE IN EACH UNIT IN AN ACCESSIBLE LOCATION THAT CONTROLS ALL WATER SUPPLY TO THAT UNIT.
4.	ALL WATER PIPING IS 1/2" UNLESS OTHERWISE NOTED.
5.	PROVIDE ALL REQUIRED PLUMBING CONNECTIONS FOR DISHWASHER (IF APPLICABLE) PER MFR. RECOMMENDATIONS.



14301 SOUTH LAKES DRIVE, SUITE E
 CHARLOTTE NC 28217
 W 704-688-9320 C 704-968-6143
 CONSULTING DESIGN-BUILD
 NC LICENSE #P-1248

CRABTREE NORTH APTS.
 2251 Charles Drive
 Raleigh, North Carolina
 EYC COMPANIES

PROJECT 1915
 DATE 01OCT19
 DRAWN BY CME
 CHECKED BY CME
 UNIT PLUMBING PLANS

P2.02