




1 UNIT C3 HC PLUMBING PLAN
1/4" = 1'-0"

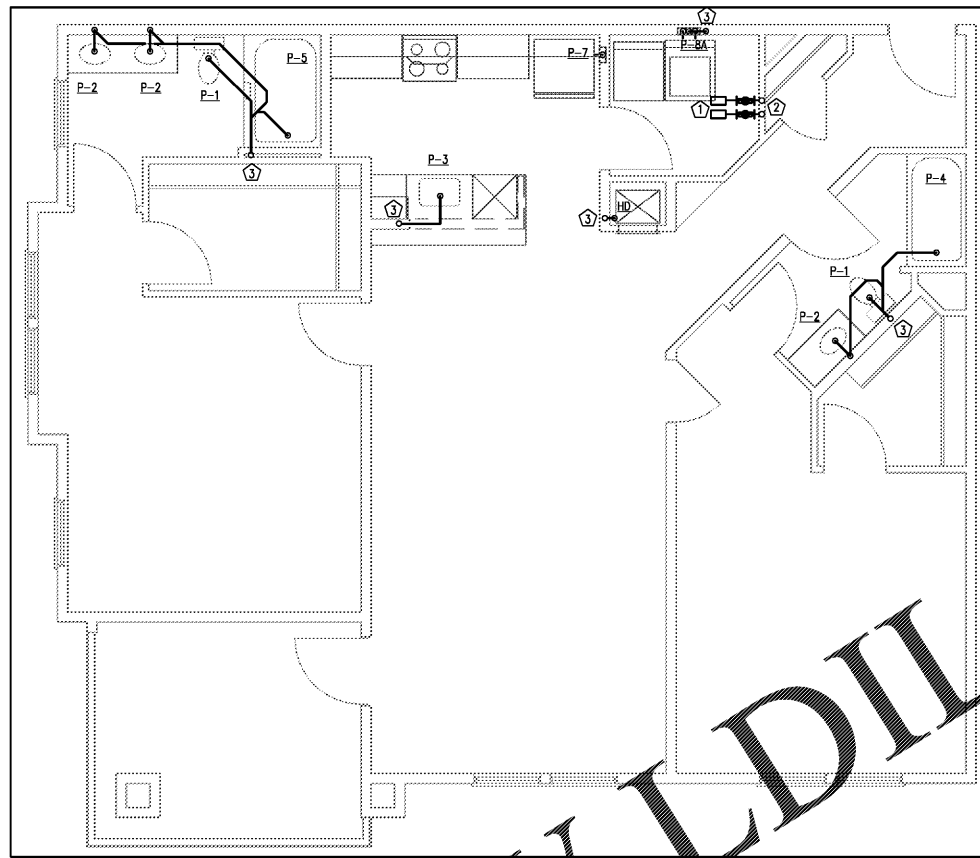

2 UNIT C5 PLUMBING PLAN
1/4" = 1'-0"

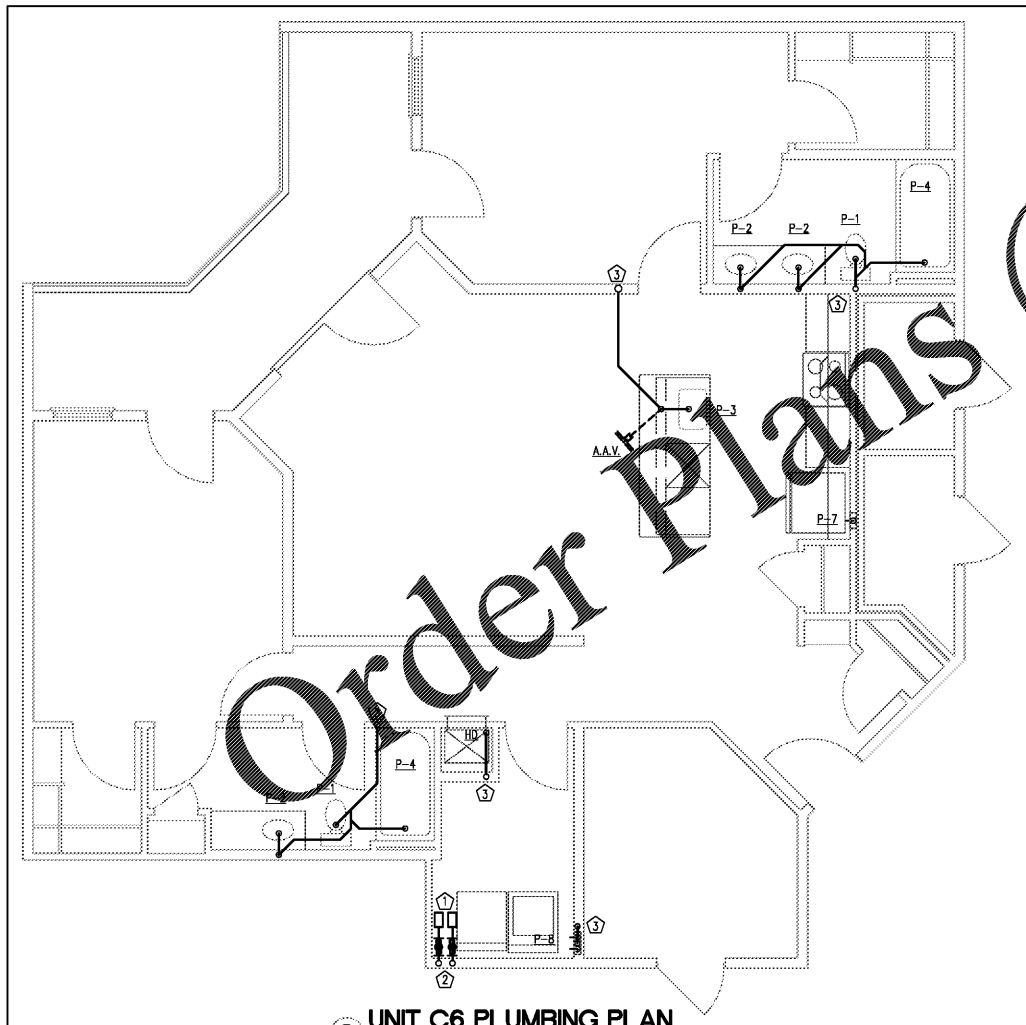

3 UNIT C6 PLUMBING PLAN
1/4" = 1'-0"

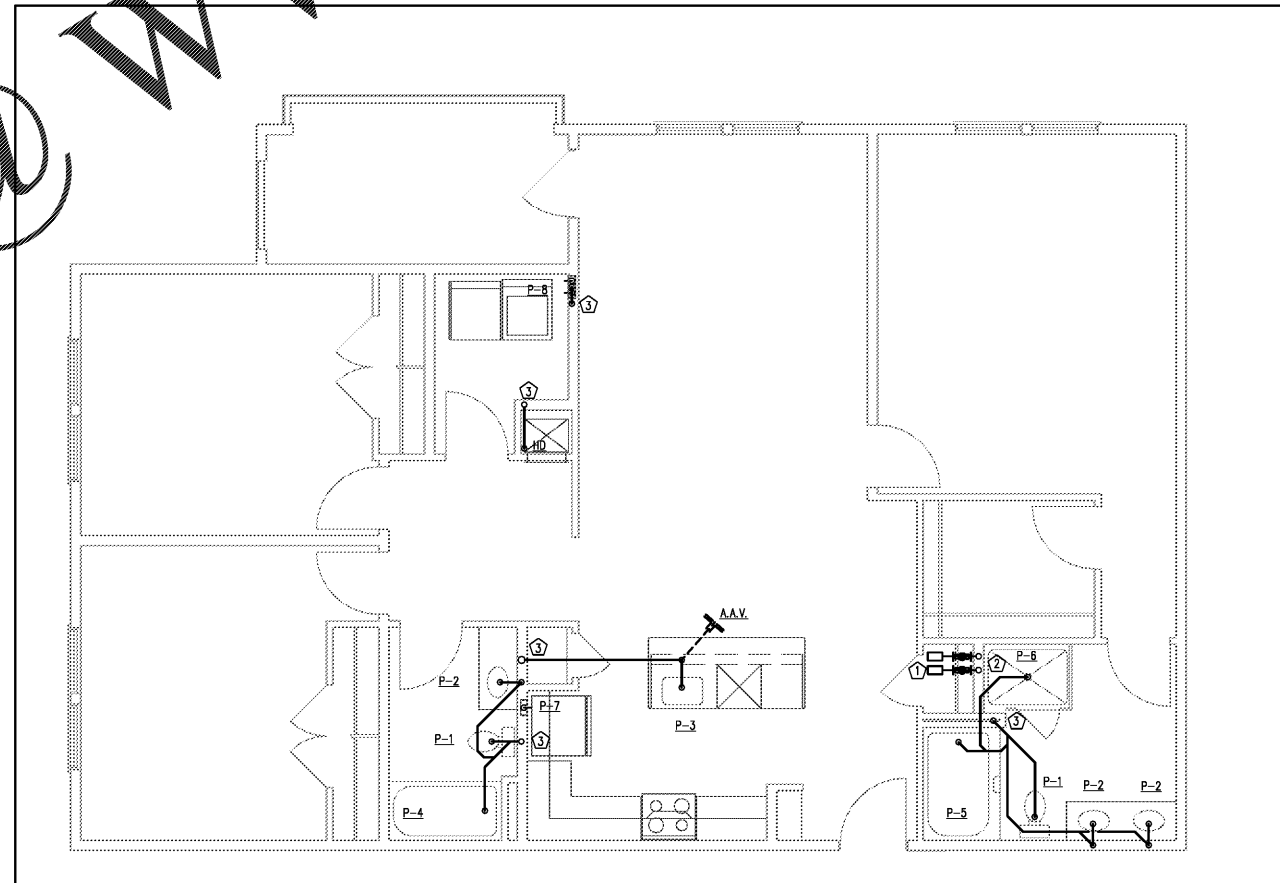

6 UNIT D1 PLUMBING PLAN
1/4" = 1'-0"

KEYED NOTES

- ① HOT WATER / COLD WATER PEX DISTRIBUTION MANIFOLDS LOCATED IN CEILING. FIELD VERIFY & DETERMINE EXACT LOCATION. SEE PEX MANIFOLD DIAGRAM ON SHEET P1.2 FOR ADDITIONAL INFORMATION.
- ② WATER RISER. SEE OVERALL BLDG. PLAN FOR RISER DIAGRAM NUMBER.
- ③ WASTE OR STORM STACK. SEE OVERALL BLDG. PLAN FOR RISER DIAGRAM NUMBER.

NOTES THIS SHEET

1. SEE SHEET P1.1 FOR FIXTURE SCHEDULE AND CONNECTION SIZES.
2. ALL WATER SUPPLY LINES IN AN EXTERIOR WALL SHALL BE RUN ON INTERIOR SIDE OF WALL INSULATION.
3. PROVIDE SHUTOFF VALVE IN EACH UNIT IN AN ACCESSIBLE LOCATION THAT CONTROLS ALL WATER SUPPLY TO THAT UNIT.
4. ALL WATER PIPING IS 1/2" UNLESS OTHERWISE NOTED.
5. PROVIDE ALL REQUIRED PLUMBING CONNECTIONS FOR DISHWASHER (IF APPLICABLE) PER MFR. RECOMMENDATIONS.

WWW.LDILINE.COM

Order plans @



WLA
WATTS LEAF ARCHITECTS, PA
191 North McDowell Street, Suite 112
Charlotte, North Carolina 28204
PH 704.376.1200 FX 704.376.5111

CRABTREE NORTH APTS.
2251 Charles Drive
Raleigh, North Carolina
EYC COMPANIES

PROJECT	1915
DATE	01OCT19
DRAWN BY	CME
CHECKED BY	CME
UNIT PLUMBING PLANS	

P2.03