
 


Order Plans @ [www.LDILine.com](http://www.LDILine.com)

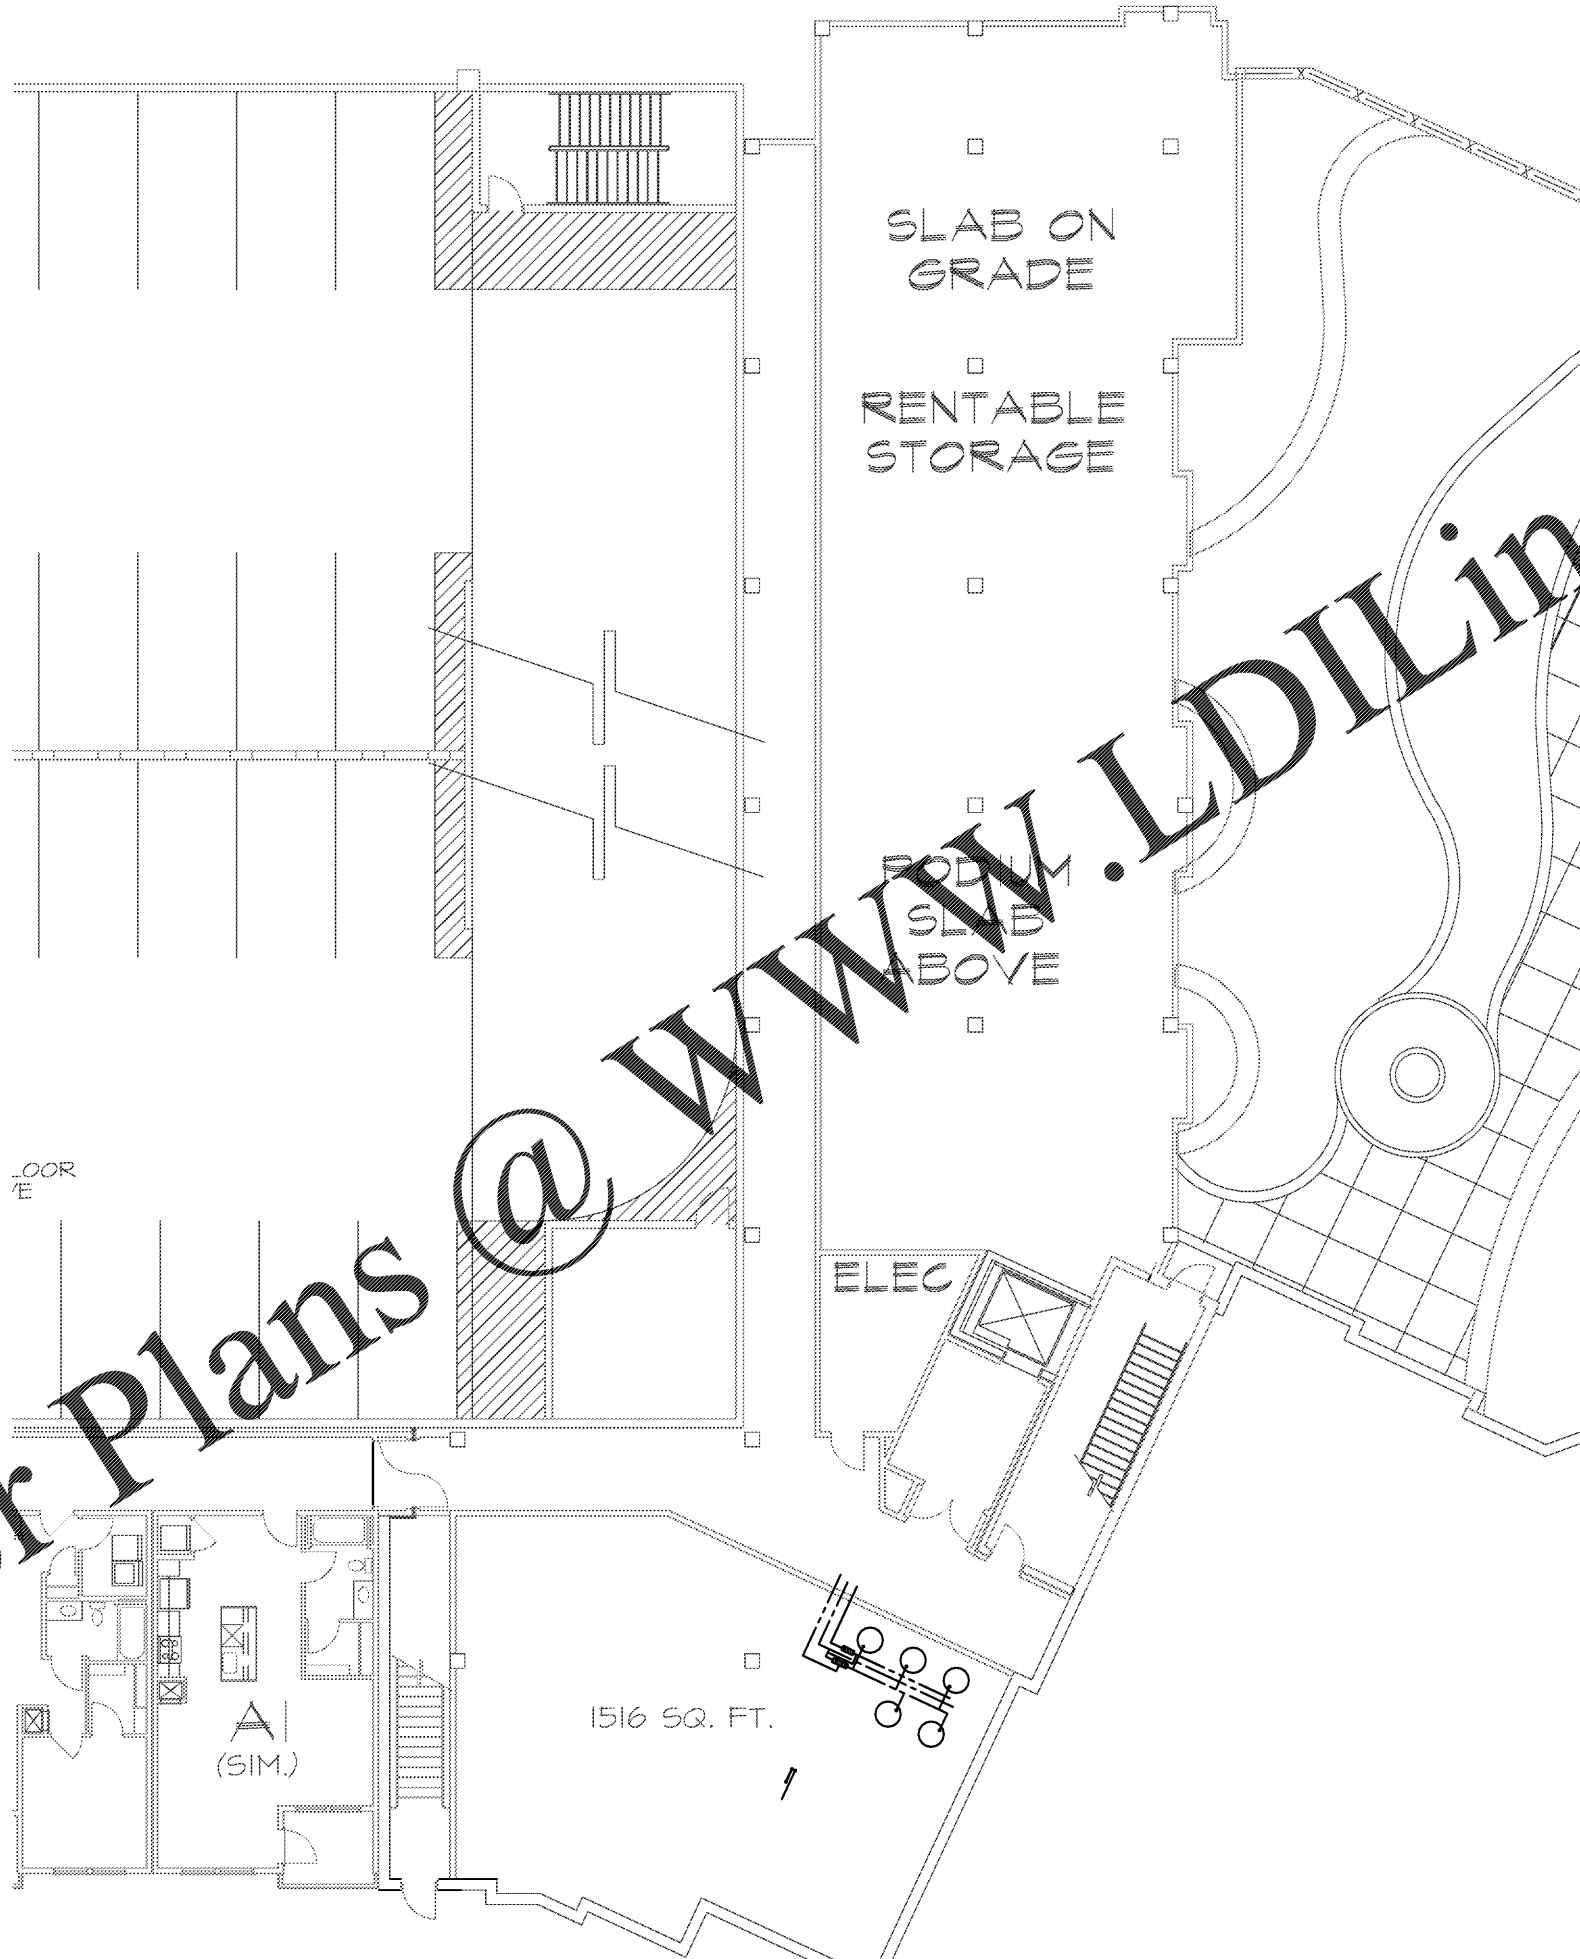

1 FIRST LEVEL BUILDING #2- PLUMBING PLAN  
1/8" = 1'-0"



PROJECT 1915  
DATE 01OCT19  
DRAWN BY CME  
CHECKED BY CME

FIRST LEVEL  
BUILDING #2-  
PLUMBING PLAN

P3.09

**WLA**  
WATTS LEAF ARCHITECTS, PA  
101 North McDowell Street Suite 112  
Charlotte, North Carolina 28204  
PH 704 376 1220 FX 704 376 5111

**ME**  
ENGINEERING

14301 SOUTH LAKES DRIVE, SUITE E  
CHARLOTTE NC 28217  
W.704-688-9320 C.704-968-8143  
CONSULTING DESIGN-BUILD  
NC LICENSE #P-1248

**CRABTREE NORTH APTS.**  
2251 Charles Drive  
Raleigh, North Carolina  
EYC COMPANIES