
 


Order Plans @

WWW.LDILine.com

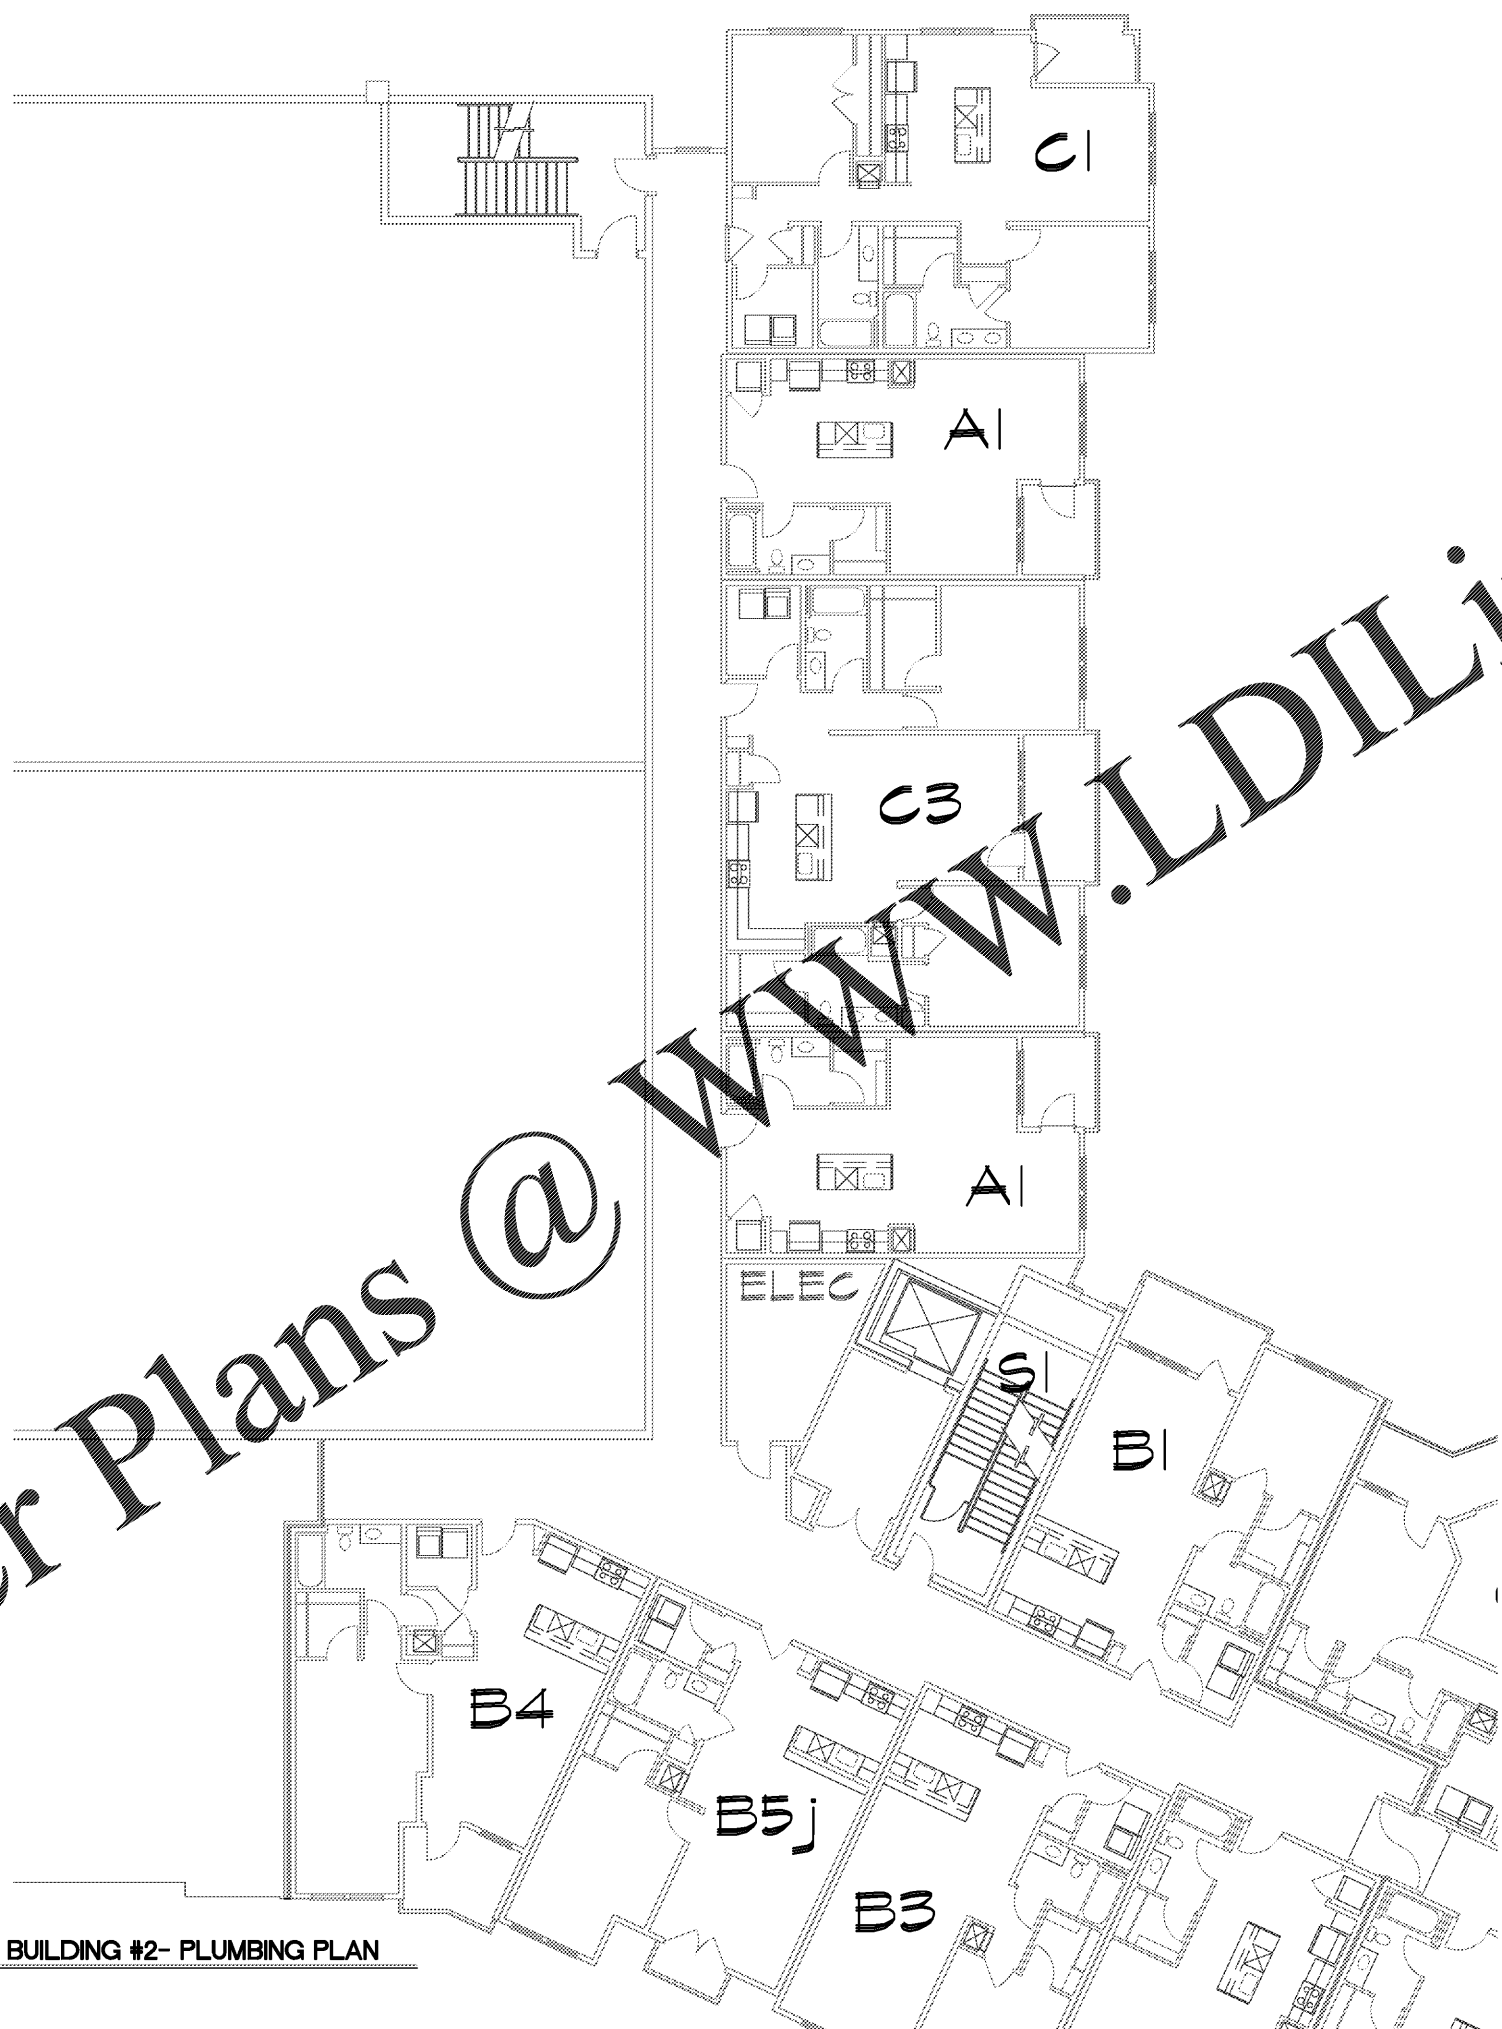

1 FIFTH LEVEL BUILDING #2- PLUMBING PLAN
1/8" = 1'-0"



PROJECT	1915
DATE	01OCT19
DRAWN BY	CME
CHECKED BY	CME
FIFTH LEVEL BUILDING #2- PLUMBING PLAN	
P3.13	

CRABTREE NORTH APTS.
2251 Charles Drive
Raleigh, North Carolina
EYC COMPANIES



WLA
WATTS LEAF ARCHITECTS, PA
101 North McDowell Street Suite 112
Charlotte, North Carolina 28204
PH 704 376 1220 FX 704 376 5111



ENGINEERING
14301 SOUTH LAKES DRIVE, SUITE E
CHARLOTTE NC 28217
W.704-688-9320 C.704-968-8143
CONSULTING DESIGN-BUILD
NC LICENSE #P-1248